


C:\Revit Local Files\080321 Duluth PD A10 Central_brlan.rvt
8/17/2010 1:25:08 PM

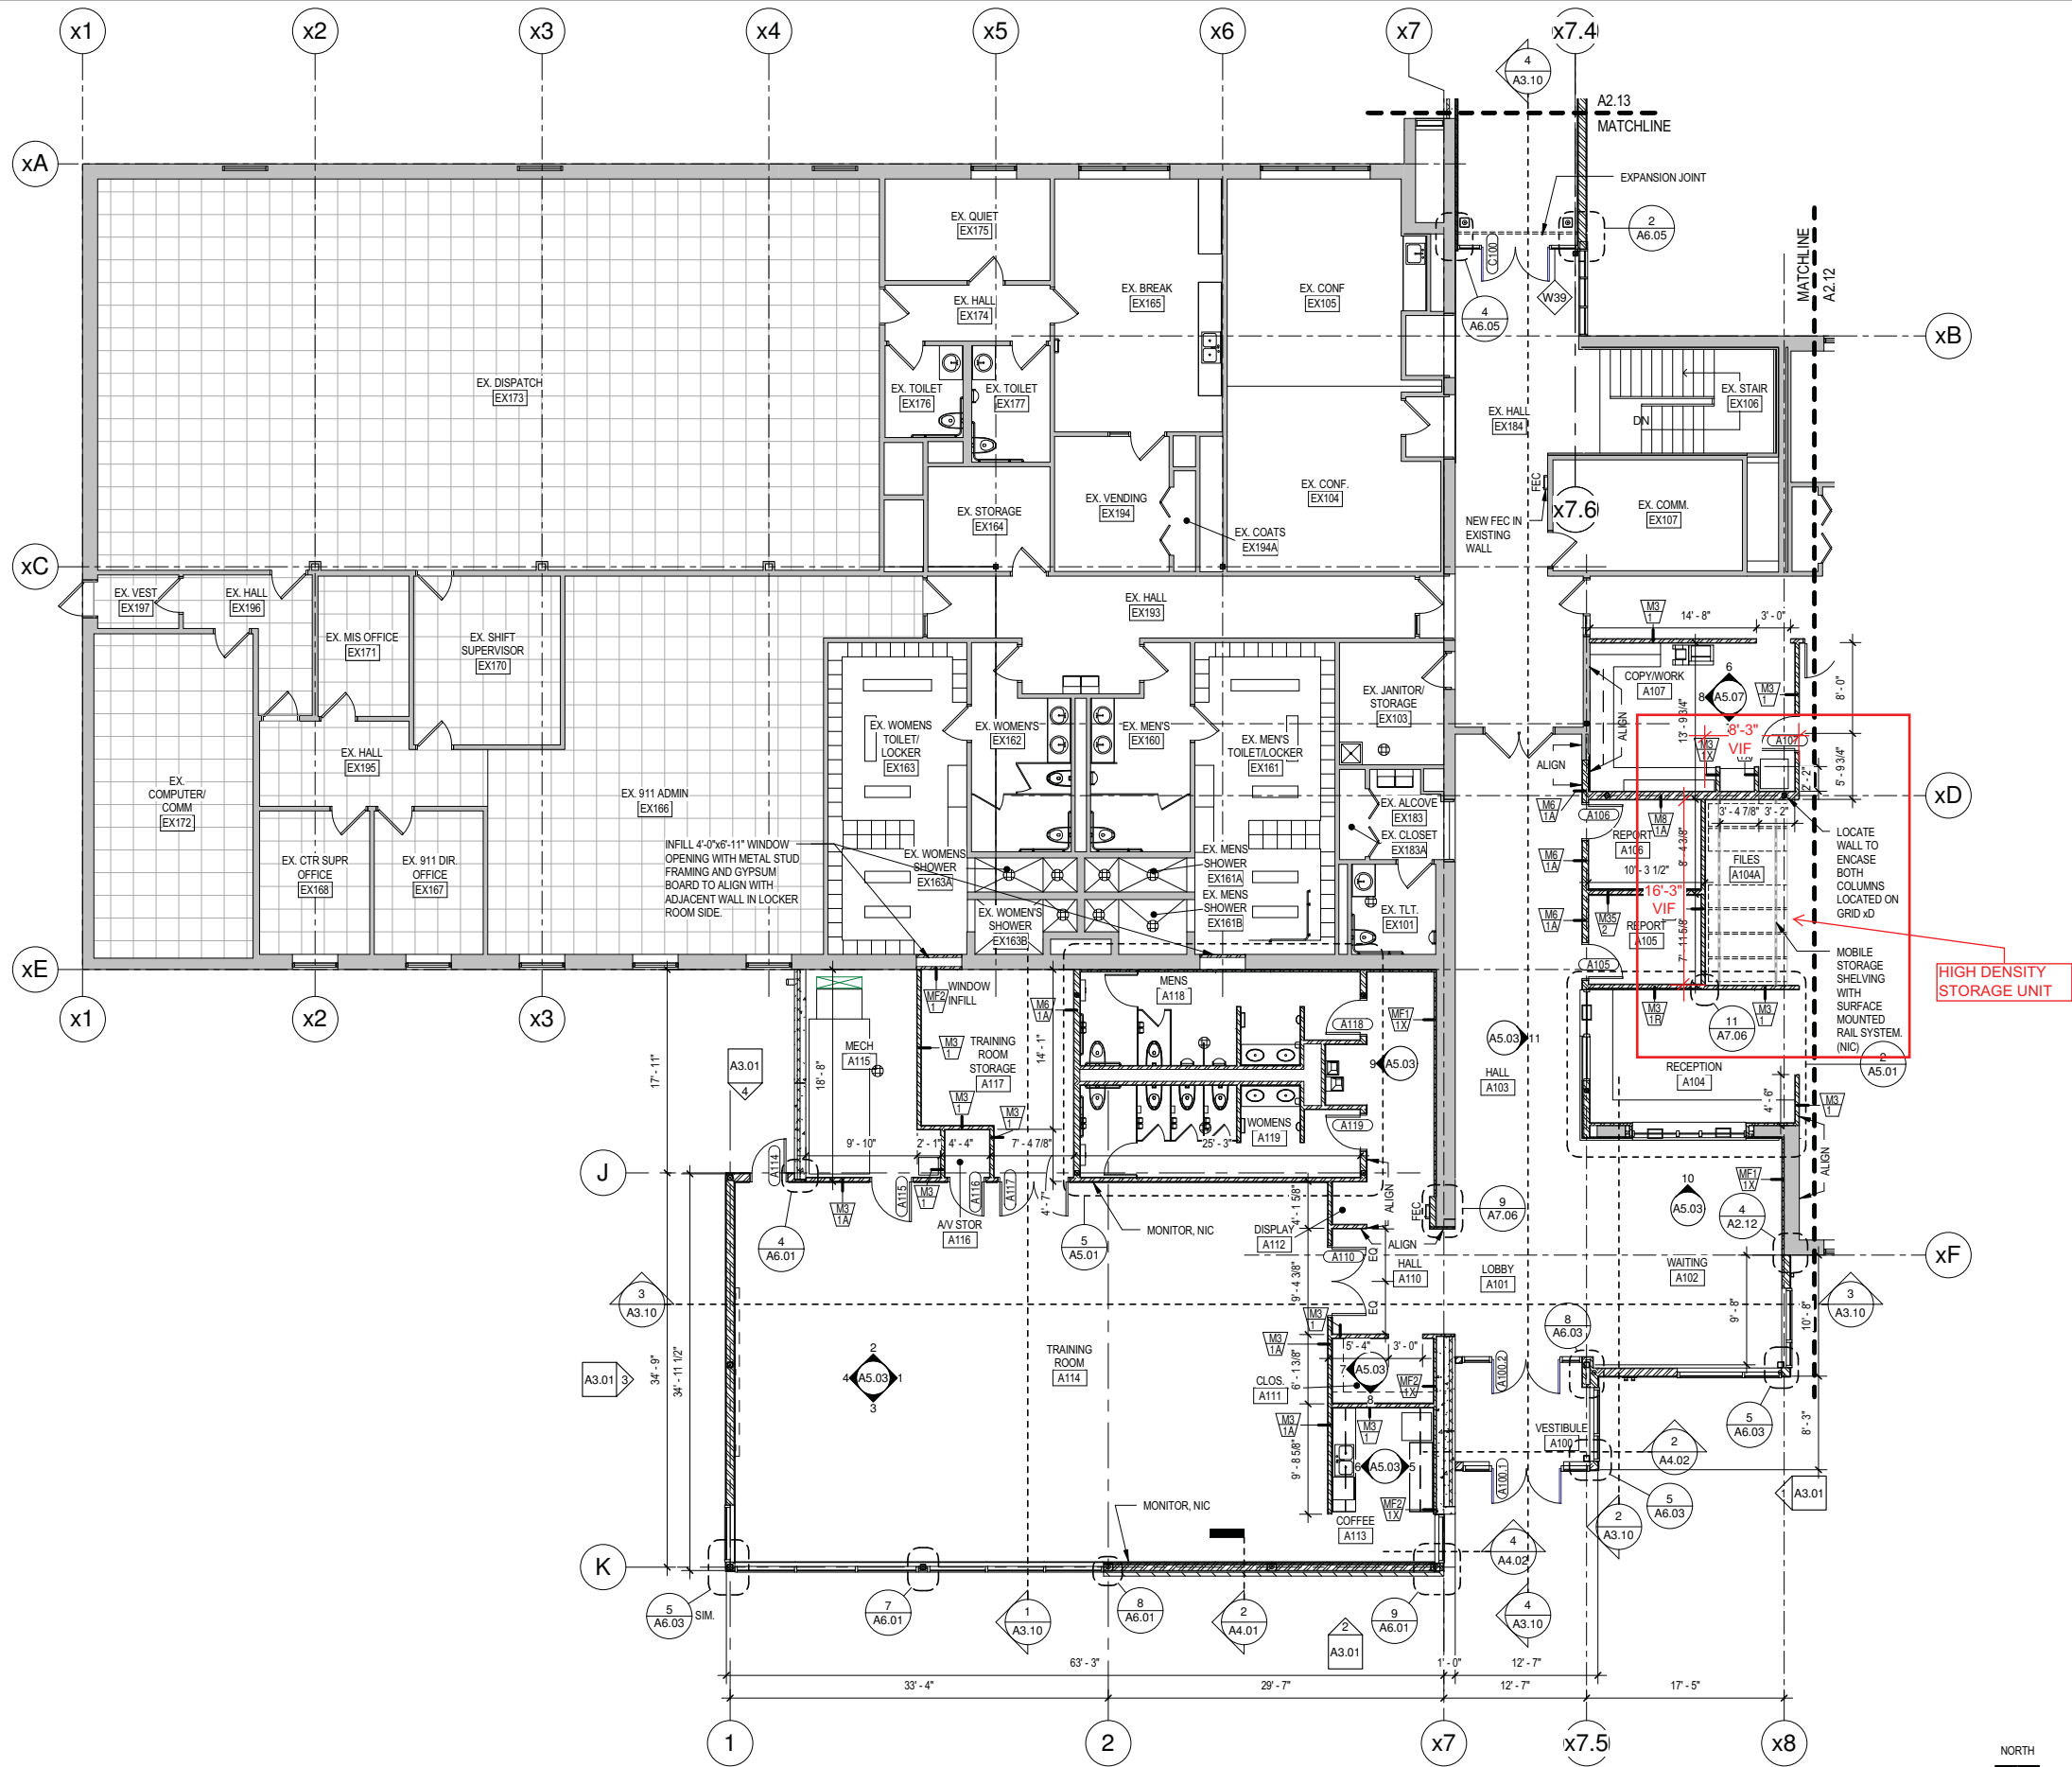

1 MAIN LEVEL AREA A
1/8" = 1'-0"

GENERAL PLAN NOTES

1. SEE SHEET G0.02 FOR STANDARD MOUNTING HEIGHTS OF FIXTURES AND ACCESSORIES.
2. SEE SHEET A7.01 FOR PARTITION TYPES. ALL WALLS ARE M3/1A UNLESS NOTED OTHERWISE.
3. DIMENSIONS OF INTERIOR WALLS ARE TO FACE OF STUD, FACE OF CMU, OR FACE OF CONCRETE RESPECTIVE TO WALL TYPE. DIMENSIONS AT THE EXTERIOR WALLS WITH FURRING ARE TO THE INTERIOR FACE OF THE PRECAST WALL PANELS.
4. FURRING WALLS AT EXTERIOR WALLS ARE TO BE HELD AWAY FROM PRECAST PANELS BY 3/4" MIN. PROVIDE RIPPED WOOD BLOCKING AT OPENINGS/TRANSITIONS.
5. AT 'ALIGN' NOTE, FINISHED FACE OF WALLS TO ALIGN.
6. SEE SHEET A8.01 FOR DOOR SCHEDULE.
7. SEE SHEET A9.01 FOR ROOM SCHEDULE.
8. REFER TO PLUMBING PLANS FOR FLOOR DRAINS AND CLEAN OUTS NOT SHOWN HERE.
9. REFER TO EXTERIOR ELEVATIONS AND A8.02 FOR WINDOW TYPES.

21 W. Superior Street
Suite 500
Duluth, MN 55802

TEL 218/727-8446
FAX 218/727-8456

<http://www.LHBcorp.com>

DULUTH □ MINNEAPOLIS



CONSULTANT


1161-A Lake Cook Rd.
Deerfield, IL 60015

TEL 847.272.9500
FAX 847.272.9510

srblarchitects.com

SRBL ARCHITECTS

KEYPLAN:

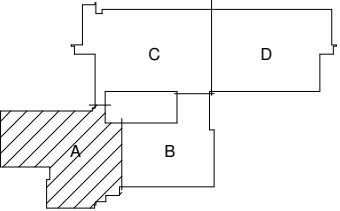

THIS SQUARE APPEARS 1/2"x1/2" ON
FULL SIZE SHEETS

NOTED FOR OWNER EQUIPMENT
PROCUREMENT 1/11/11

NO	DATE	100% SUBMITTAL	REVISION
	08/17/2010		

I HEREBY CERTIFY that this plan, specification or report was prepared by me or under my direct supervision and that I am a duly Licensed Architect under the laws of the State of Minnesota.

Signature: *Cynthia I. Poirer*

Typed or Printed Name: CYNTHIA I. POIRER

Date: 08/17/10 Reg. No.: 22021

COPYRIGHT 2010 BY LHB, INC. ALL RIGHTS RESERVED

PROJECT TITLE:

CITY OF DULUTH
POLICE
HEADQUARTERS

DRAWING TITLE:

MAIN LEVEL FLOOR
PLAN AREA A

FILE: 080321 Duluth PD.rvt

DRAWN BY: BNLMH


CHECKED BY: CIP

PROJ. NO: 080321

DRAWING NO:


A2.11

C:\Revit Local Files\080321 Duluth PD A10 Central_Bldg.rvt
8/17/2010 1:25:11 PM

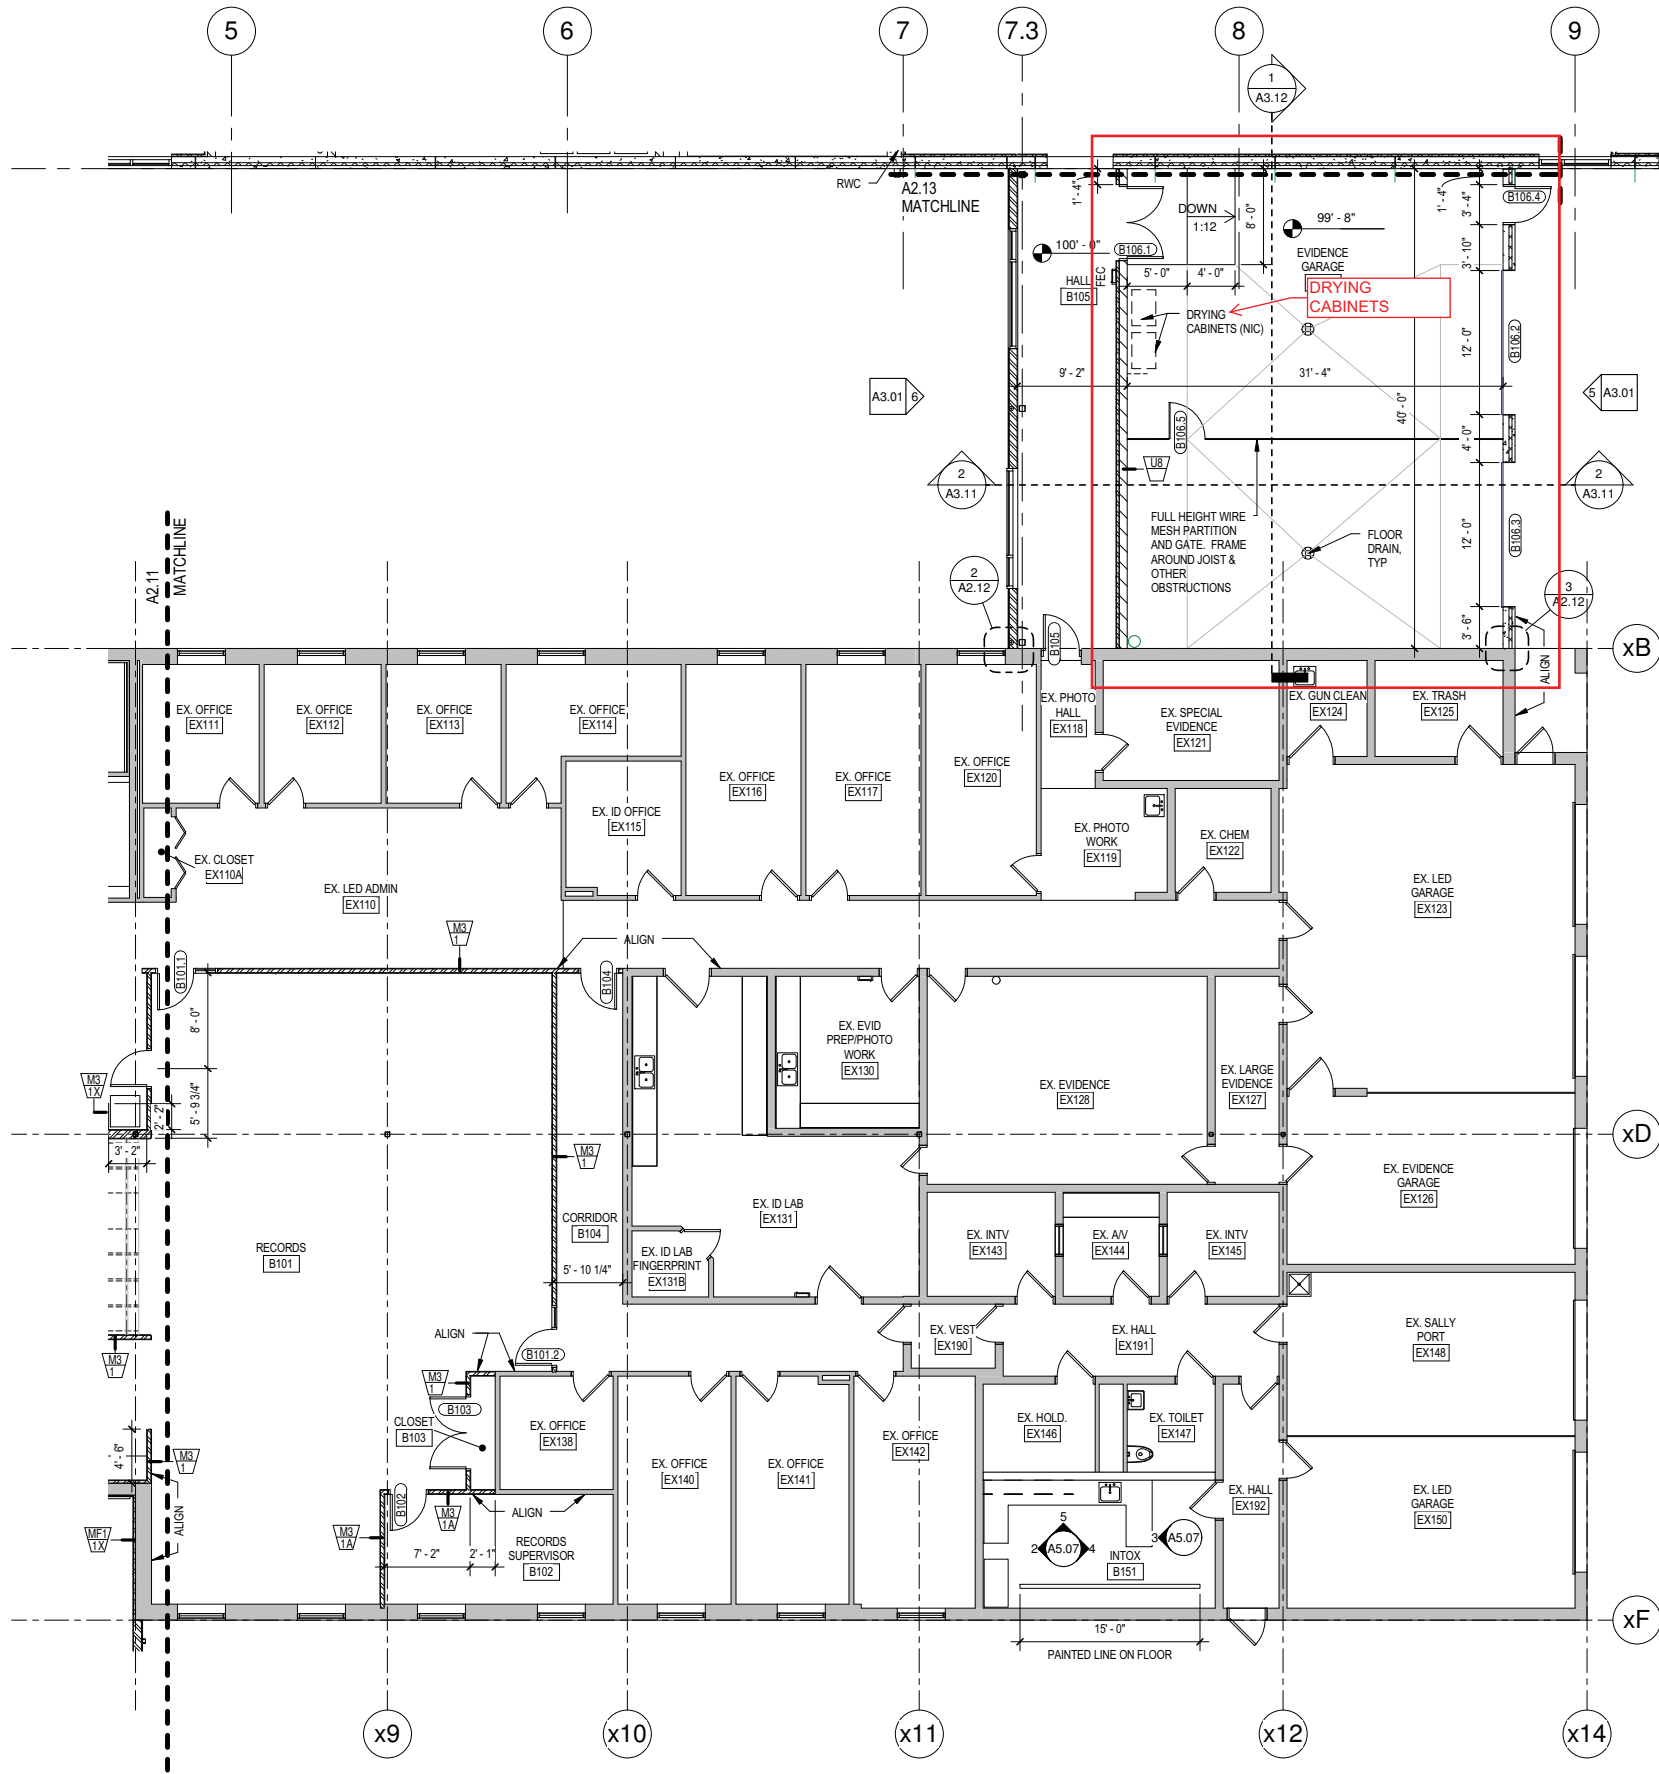


1 MAIN LEVEL AREA B
1/8" = 1'-0"


2 PLAN DETAIL AT EVIDENCE GARAGE METAL PANEL
1" = 1'-0"

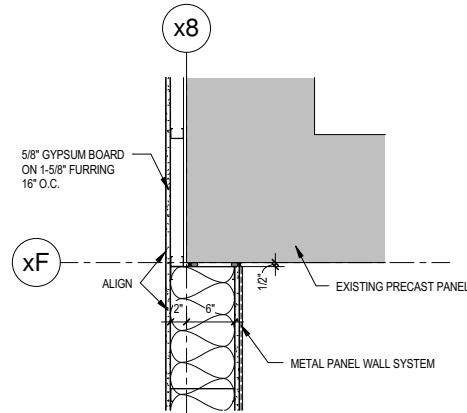

4 PLAN DETAIL AT TRAINING TO EXISTING
1" = 1'-0"

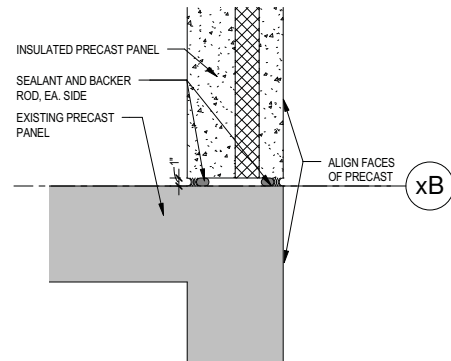

3 PLAN DETAIL AT EVIDENCE GARAGE PC
1" = 1'-0"

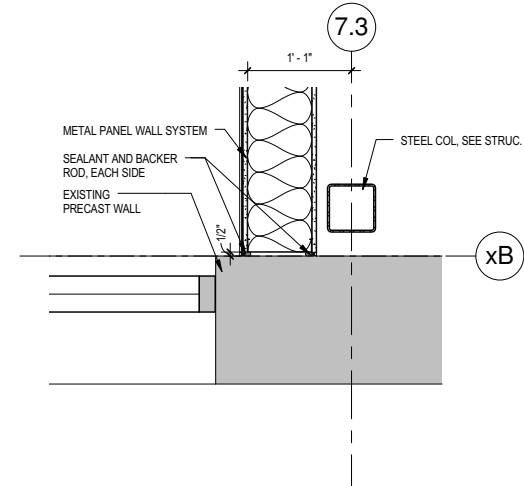

GENERAL PLAN NOTES


- SEE SHEET G0.02 FOR STANDARD MOUNTING HEIGHTS OF FIXTURES AND ACCESSORIES.
- SEE SHEET A7.01 FOR PARTITION TYPES. ALL WALLS ARE M3/1A UNLESS NOTED OTHERWISE.
- DIMENSIONS OF INTERIOR WALLS ARE TO FACE OF STUD, FACE OF CMU, OR FACE OF CONCRETE RESPECTIVE TO WALL TYPE. DIMENSIONS AT THE EXTERIOR WALLS WITH FURRING ARE TO THE INTERIOR FACE OF THE PRECAST WALL PANELS.
- FURRING WALLS AT EXTERIOR WALLS ARE TO BE HELD AWAY FROM PRECAST PANELS BY 3/4\"/>
- AT 'ALIGN' NOTE, FINISHED FACE OF WALLS TO ALIGN.
- SEE SHEET A8.01 FOR DOOR SCHEDULE.
- SEE SHEET A9.01 FOR ROOM SCHEDULE.
- REFER TO PLUMBING PLANS FOR FLOOR DRAINS AND CLEAN OUTS NOT SHOWN HERE.
- REFER TO EXTERIOR ELEVATIONS AND A8.02 FOR WINDOW TYPES

21 W. Superior Street
Suite 500
Duluth, MN 55802

TEL 218/727-8446
FAX 218/727-8456

http://www.LHBcorp.com

DULUTH □ MINNEAPOLIS

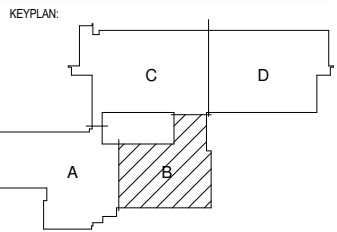

THIS SQUARE APPEARS 1/2\"/>

NOTED FOR OWNER EQUIPMENT
PROCUREMENT 1/11/11

NO	DATE	100% SUBMITTAL	REVISION
	08/17/2010		

I HEREBY CERTIFY that this plan, specification or report was prepared by me or under my direct supervision and that I am a duly Licensed Architect under the laws of the State of Minnesota.

Signature: *Cynthia I. Poirer*

Typed or Printed Name: CYNTHIA I. POIRER

Date: 08/17/10 Reg. No.: 22021

COPYRIGHT 2010 BY LHB, INC. ALL RIGHTS RESERVED


PROJECT TITLE:

CITY OF DULUTH POLICE HEADQUARTERS

DRAWING TITLE:
MAIN LEVEL FLOOR
PLAN AREA B

FILE: 080321 Duluth PD.rvt
DRAWN BY: BN/UMH
CHECKED BY: CIP
PROJ. NO: 080321
DRAWING NO:

A2.12

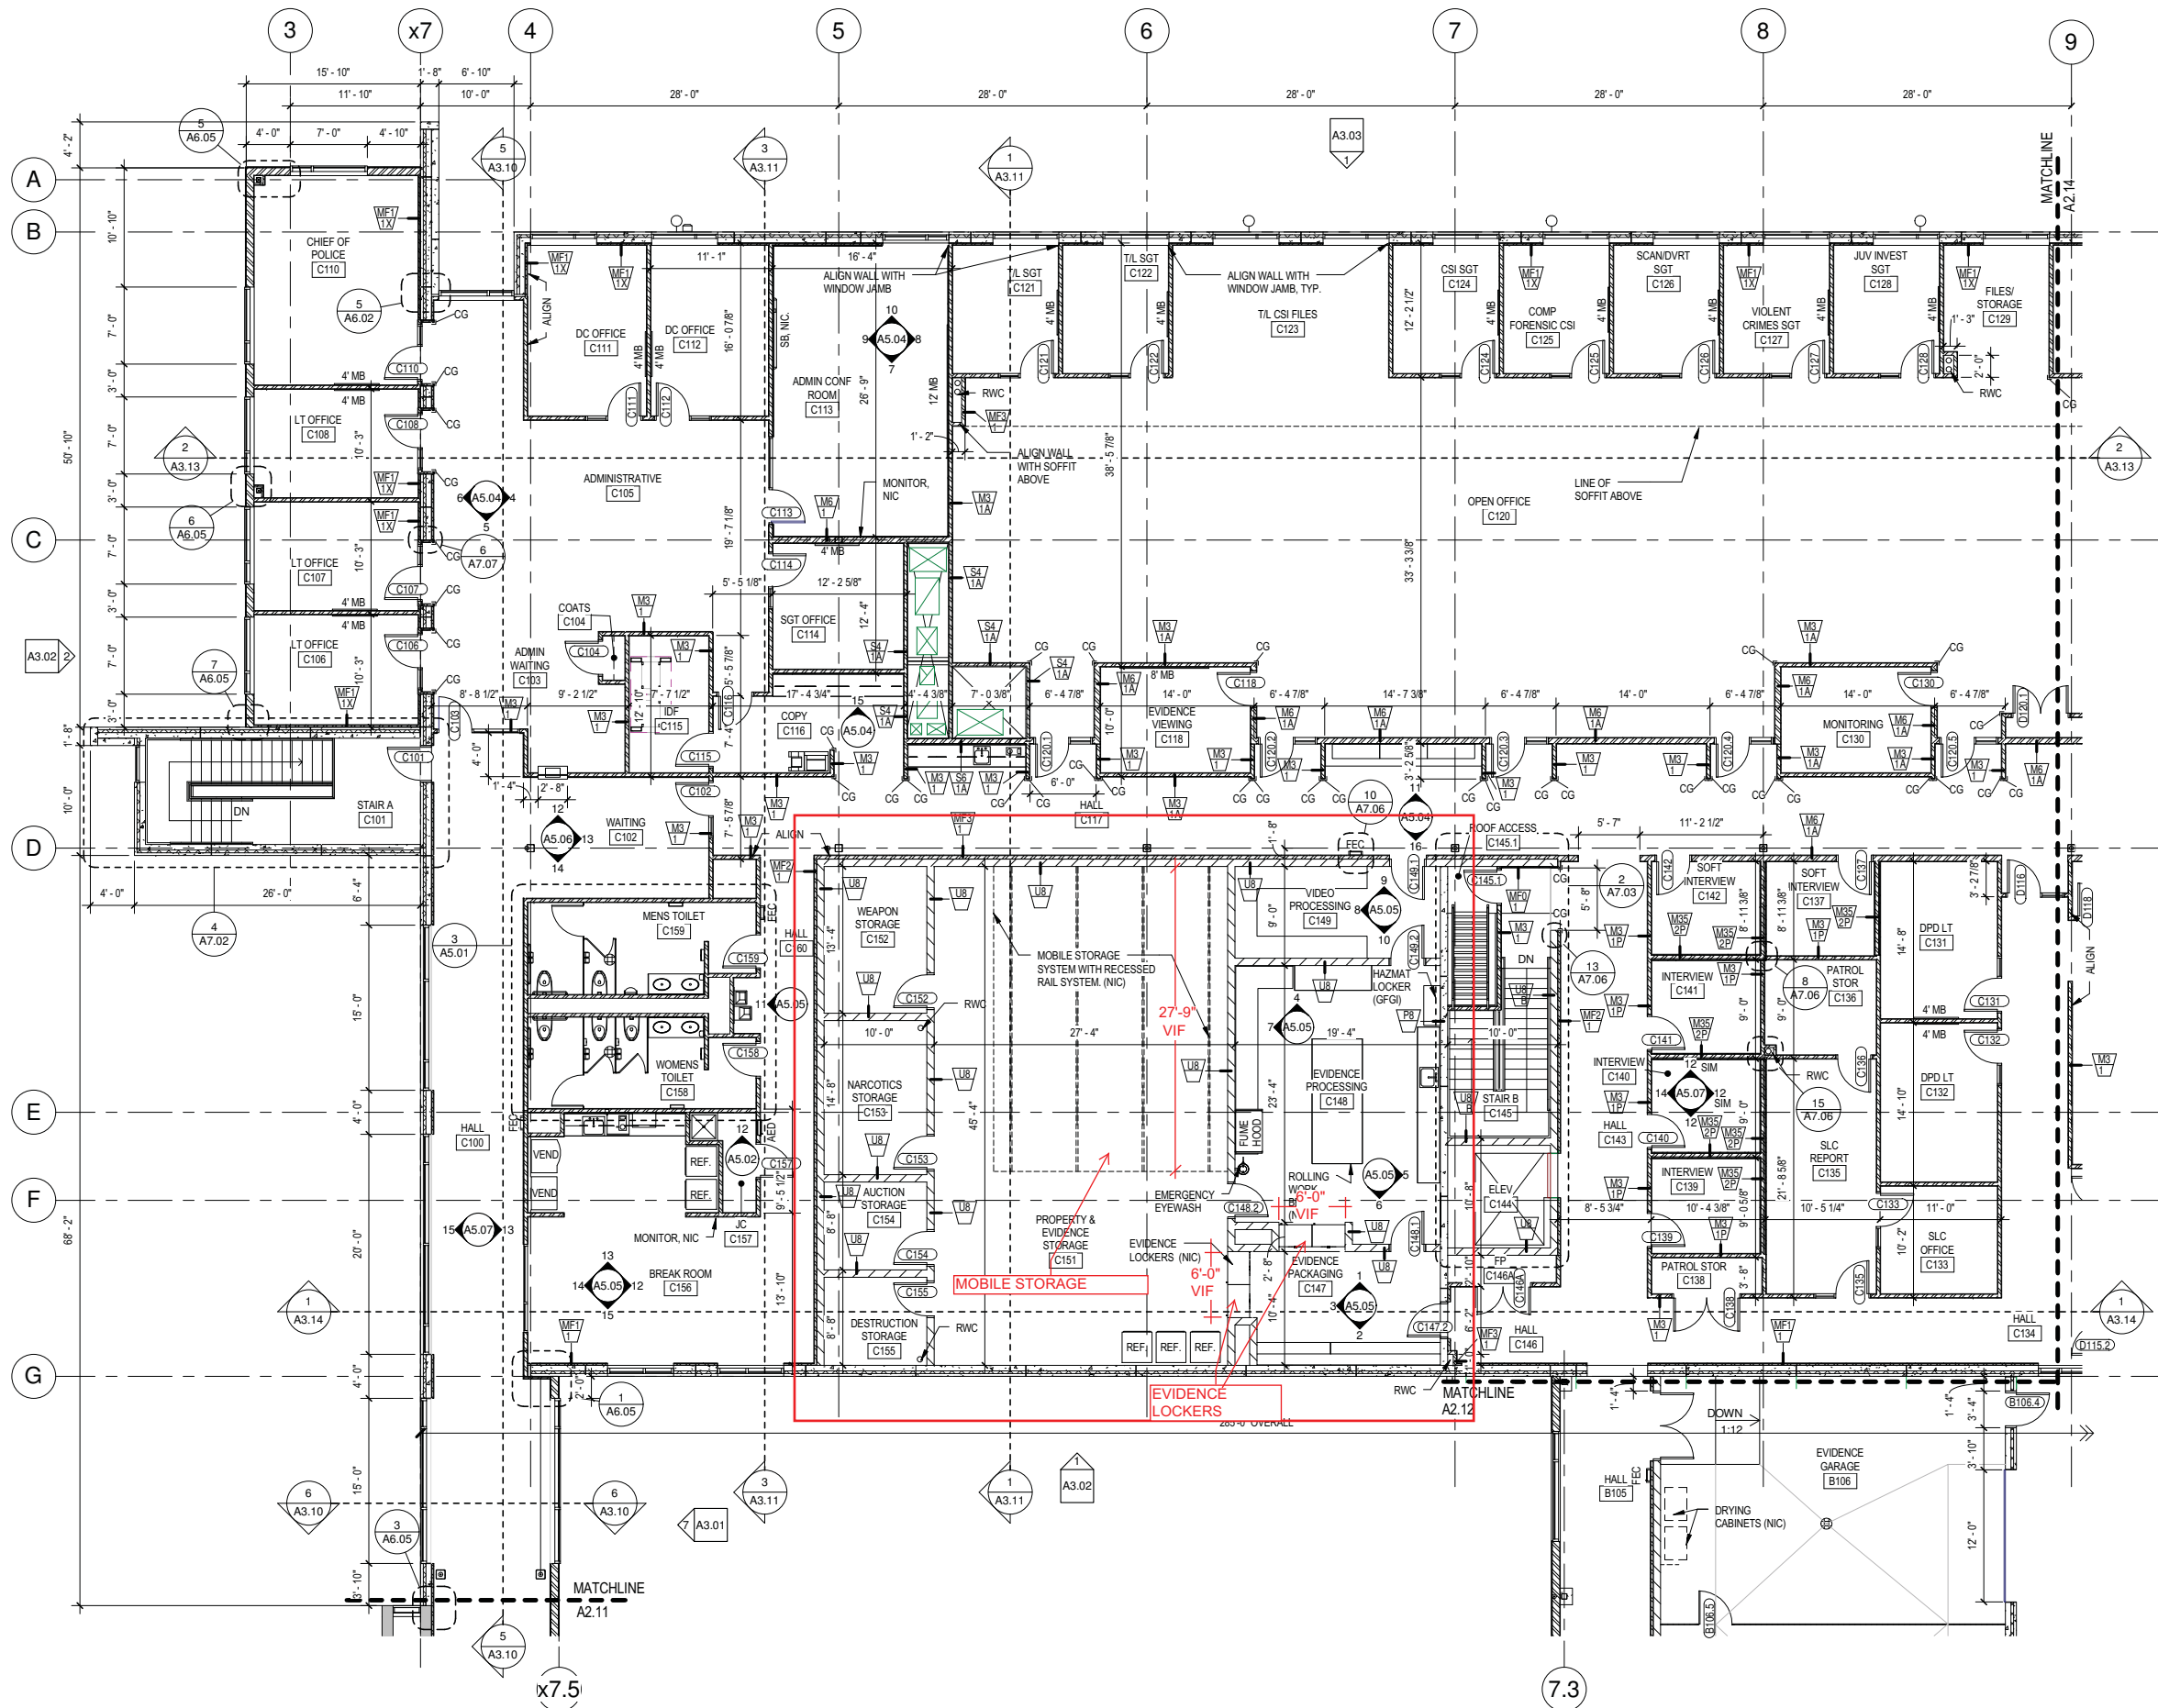

GENERAL PLAN NOTES

- SEE SHEET G0.02 FOR STANDARD MOUNTING HEIGHTS OF FIXTURES AND ACCESSORIES.
- SEE SHEET A7.01 FOR PARTITION TYPES. ALL WALLS ARE M3/1A UNLESS NOTED OTHERWISE.
- DIMENSIONS OF INTERIOR WALLS ARE TO FACE OF STUD, FACE OF CMU, OR FACE OF CONCRETE RESPECTIVE TO WALL TYPE. DIMENSIONS AT THE EXTERIOR WALLS WITH FURRING ARE TO THE INTERIOR FACE OF THE PRECAST WALL PANELS.
- FURRING WALLS AT EXTERIOR WALLS ARE TO BE HELD AWAY FROM PRECAST PANELS BY 3/4" MIN. PROVIDE RIPPED WOOD BLOCKING AT OPENINGS/TRANSITIONS.
- AT 'ALIGN' NOTE, FINISHED FACE OF WALLS TO ALIGN.
- REFER TO SHEET A8.01 FOR DOOR SCHEDULE.
- SEE SHEET A8.01 FOR ROOM SCHEDULE.
- REFER TO PLUMBING PLANS FOR FLOOR DRAINS AND CLEAN OUTS NOT SHOWN HERE.
- REFER TO EXTERIOR ELEVATIONS AND A8.02 FOR WINDOW TYPES

21 W. Superior Street
Suite 500
Duluth, MN 55802


TEL 218/727-8446
FAX 218/727-8456

http://www.LHBcorp.com

DULUTH MINNEAPOLIS

SRBL ARCHITECTS
CONSULTANT
1161-A Lake Cook Rd.
Deerfield, IL 60015
TEL 847.272.9500
FAX 847.272.9510
srblarchitects.com

KEYPLAN:

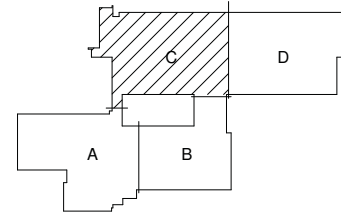

THIS SQUARE APPEARS 1/2"x1/2" ON FULL SIZE SHEETS

**NOTED FOR OWNER EQUIPMENT
PROCUREMENT 1/11/11**

NO	DATE	100% SUBMITTAL	REVISION
	08/17/2010		

I HEREBY CERTIFY that this plan, specification or report was prepared by me or under my direct supervision and that I am a duly Licensed Architect under the laws of the State of Minnesota.

Signature: *Cynthia I. Poirer*

Typed or Printed Name: CYNTHIA I. POIRER

Date: 08/17/10 Reg. No.: 22021

COPYRIGHT 2010 BY LHB, INC. ALL RIGHTS RESERVED

PROJECT TITLE:

CITY OF DULUTH POLICE HEADQUARTERS


DRAWING TITLE:

MAIN LEVEL FLOOR PLAN AREA C

FILE: 080321 Duluth PD.rvt
DRAWN BY: BNLMH
CHECKED BY: CIP
PROJ. NO: 080321
DRAWING NO:

A2.13

C:\Revit Local Files\080321 Duluth PD A10 Central_Bldg.rvt
8/17/2010 1:25:19 PM

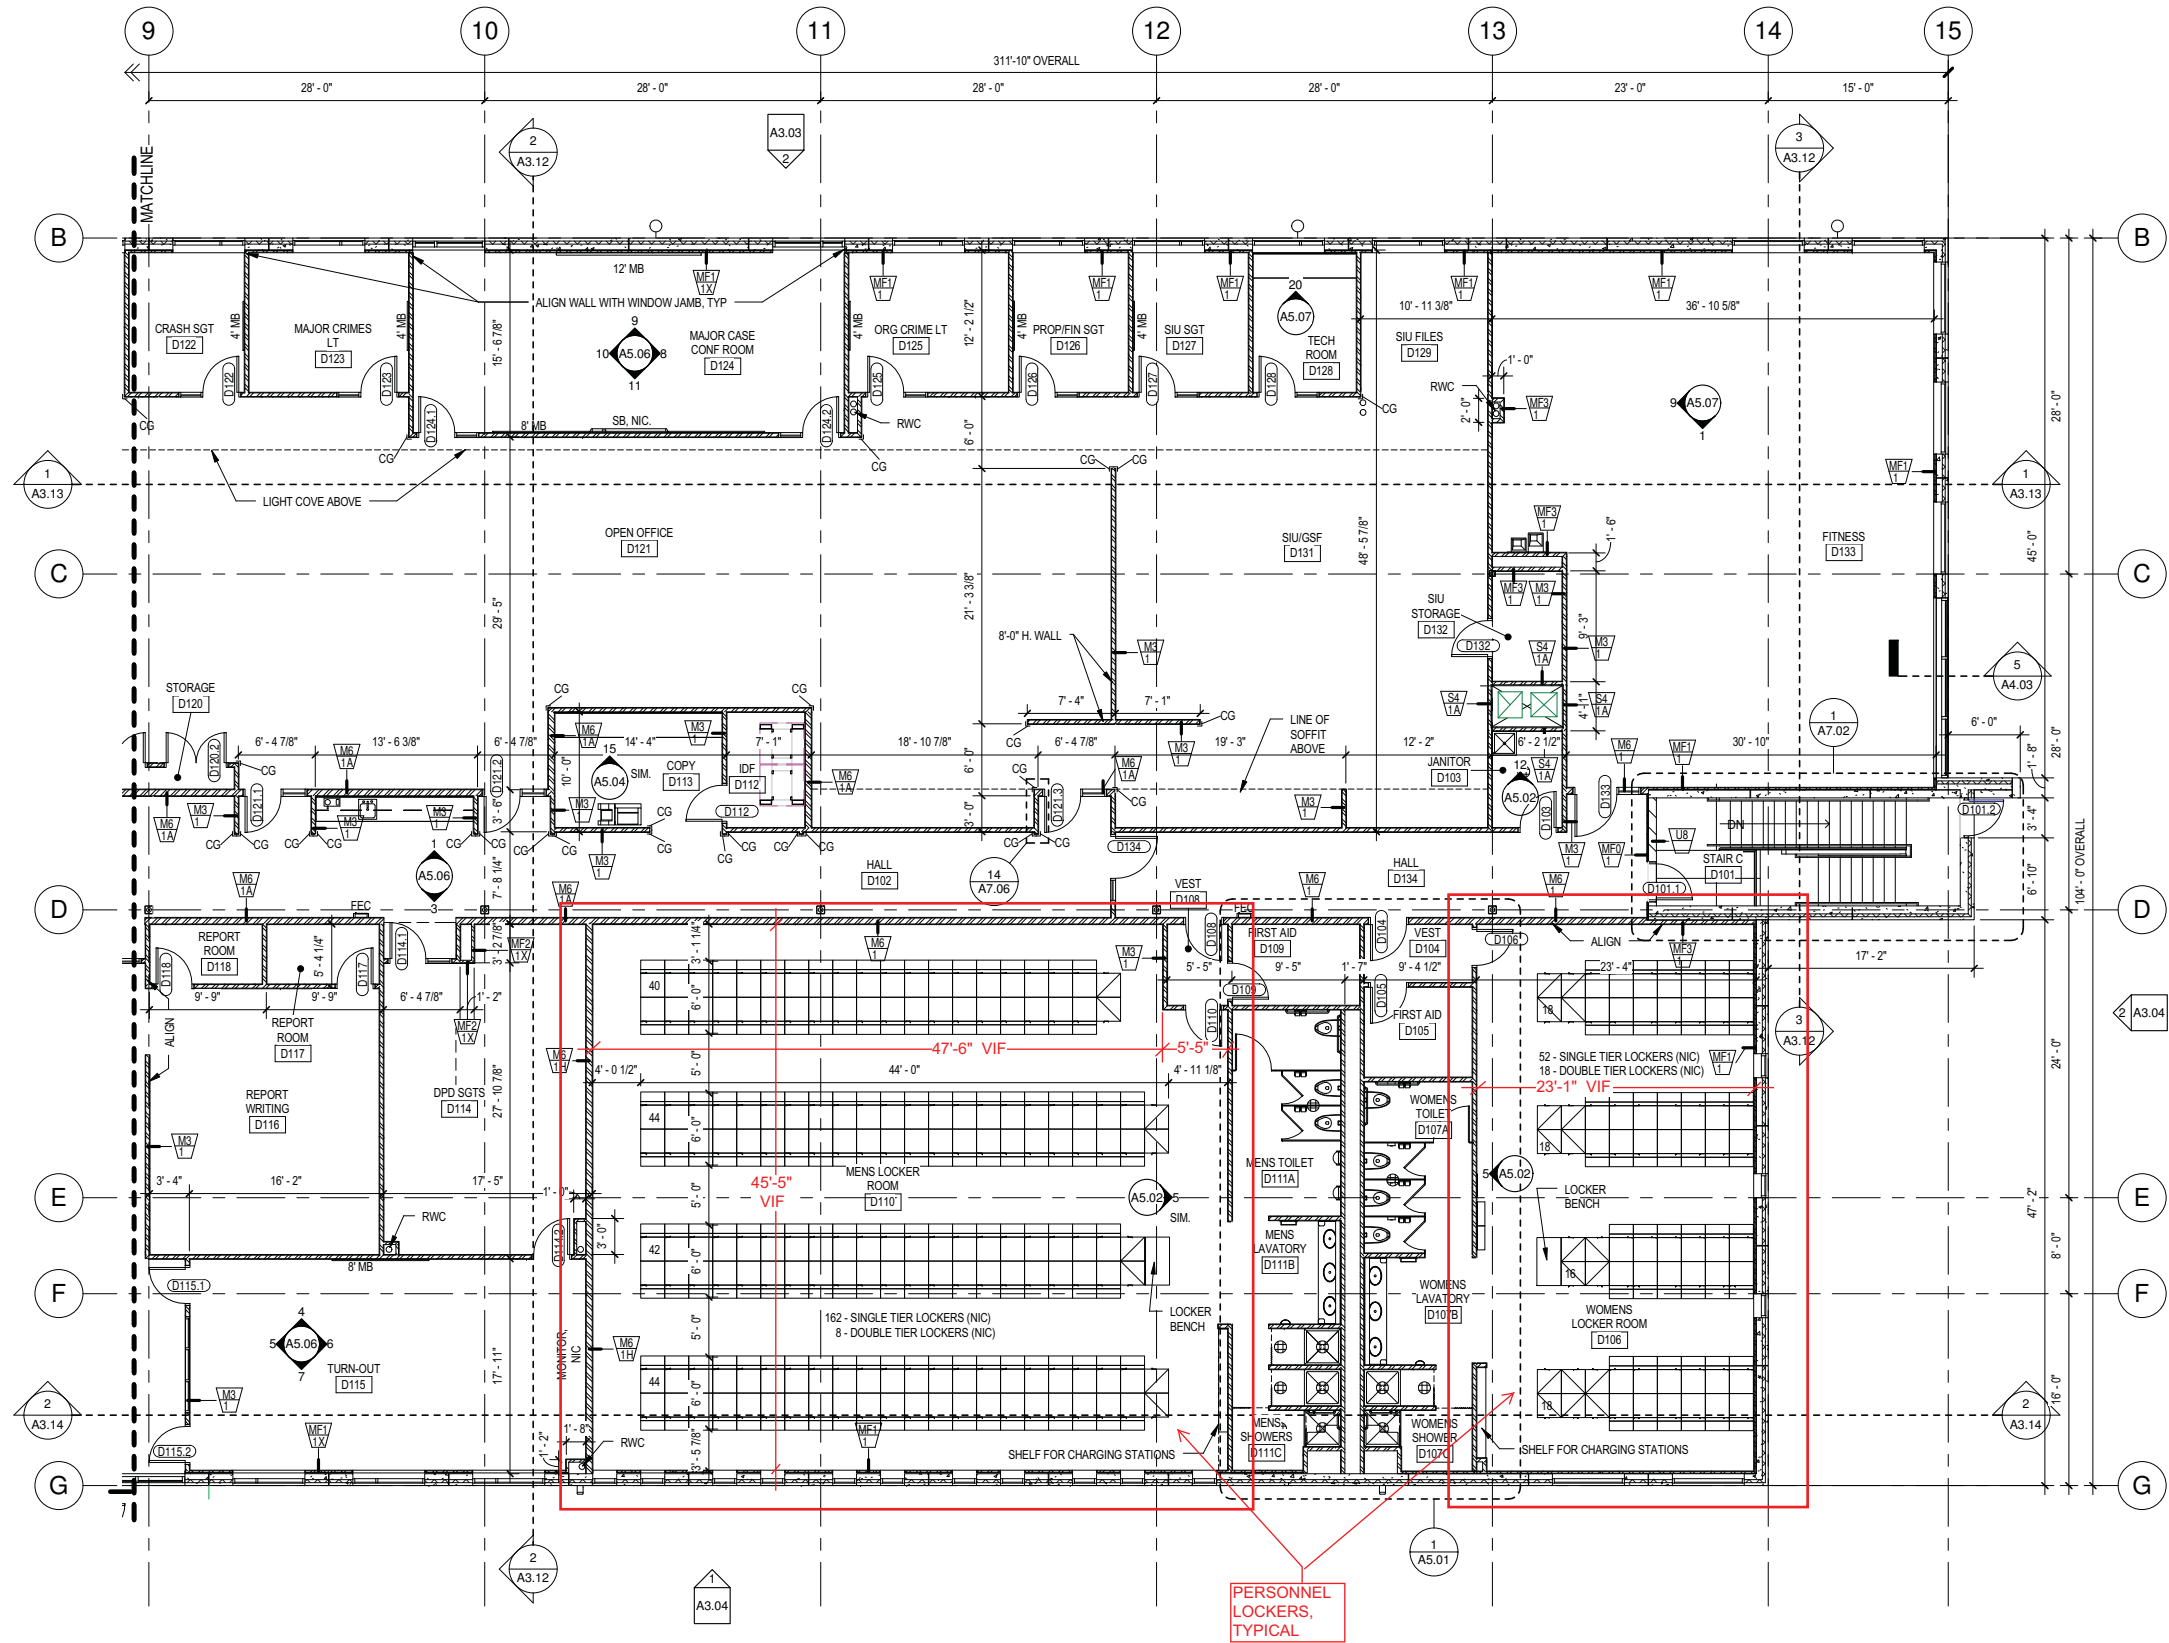

1 MAIN LEVEL AREA D
1/8" = 1'-0"



GENERAL PLAN NOTES

1. SEE SHEET G0.02 FOR STANDARD MOUNTING HEIGHTS OF FIXTURES AND ACCESSORIES.
2. SEE SHEET A7.01 FOR PARTITION TYPES. ALL WALLS ARE M3/1A UNLESS NOTED OTHERWISE.
3. DIMENSIONS OF INTERIOR WALLS ARE TO FACE OF STUD, FACE OF CMU, OR FACE OF CONCRETE RESPECTIVE TO WALL TYPE. DIMENSIONS AT THE EXTERIOR WALLS WITH FURRING ARE TO THE INTERIOR FACE OF THE PRECAST WALL PANELS.
4. FURRING WALLS AT EXTERIOR WALLS ARE TO BE HELD AWAY FROM PRECAST PANELS BY 3/4" MIN. PROVIDE RIPPED WOOD BLOCKING AT OPENINGS/TRANSITIONS.
5. AT 'ALIGN' NOTE, FINISHED FACE OF WALLS TO ALIGN.
6. SEE SHEET A8.01 FOR DOOR SCHEDULE.
7. SEE SHEET A9.01 FOR ROOM SCHEDULE.
8. REFER TO PLUMBING PLANS FOR FLOOR DRAINS AND CLEAN OUTS NOT SHOWN HERE.
9. REFER TO EXTERIOR ELEVATIONS AND A8.02 FOR WINDOW TYPES.

21 W. Superior Street
Suite 500
Duluth, MN 55802

TEL 218/727-8446
FAX 218/727-8456

<http://www.LHBcorp.com>

DULUTH □ MINNEAPOLIS




CONSULTANT

1161-A Lake Cook Rd.
Deerfield, IL 60015
TEL 847.272.9500
FAX 847.272.9510
srblarchitects.com

SRBL ARCHITECTS

KEYPLAN:

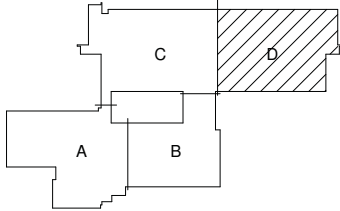

THIS SQUARE APPEARS 1/2"x1/2" ON
FULL SIZE SHEETS

NOTED FOR OWNER EQUIPMENT
PROCUREMENT 1/11/11

08/17/2010	100% SUBMITTAL
NO	DATE REVISION

I HEREBY CERTIFY that this plan,
specification or report was prepared by me
or under my direct supervision and that I am
a duly Licensed Architect under the laws of
the State of Minnesota.

Signature: *Cynthia I. Poirier*

Typed or Printed Name: CYNTHIA I. POIRIER

Date: 08/17/10 Reg. No.: 22021

COPYRIGHT 2010 BY LHB, INC. ALL RIGHTS RESERVED

PROJECT TITLE:


CITY OF DULUTH
POLICE
HEADQUARTERS

DRAWING TITLE:


MAIN LEVEL FLOOR
PLAN AREA D

FILE: 080321 Duluth PD.rvt
DRAWN BY: BNL/MMH
CHECKED BY: CIP
PROJ. NO: 080321
DRAWING NO:

A2.14

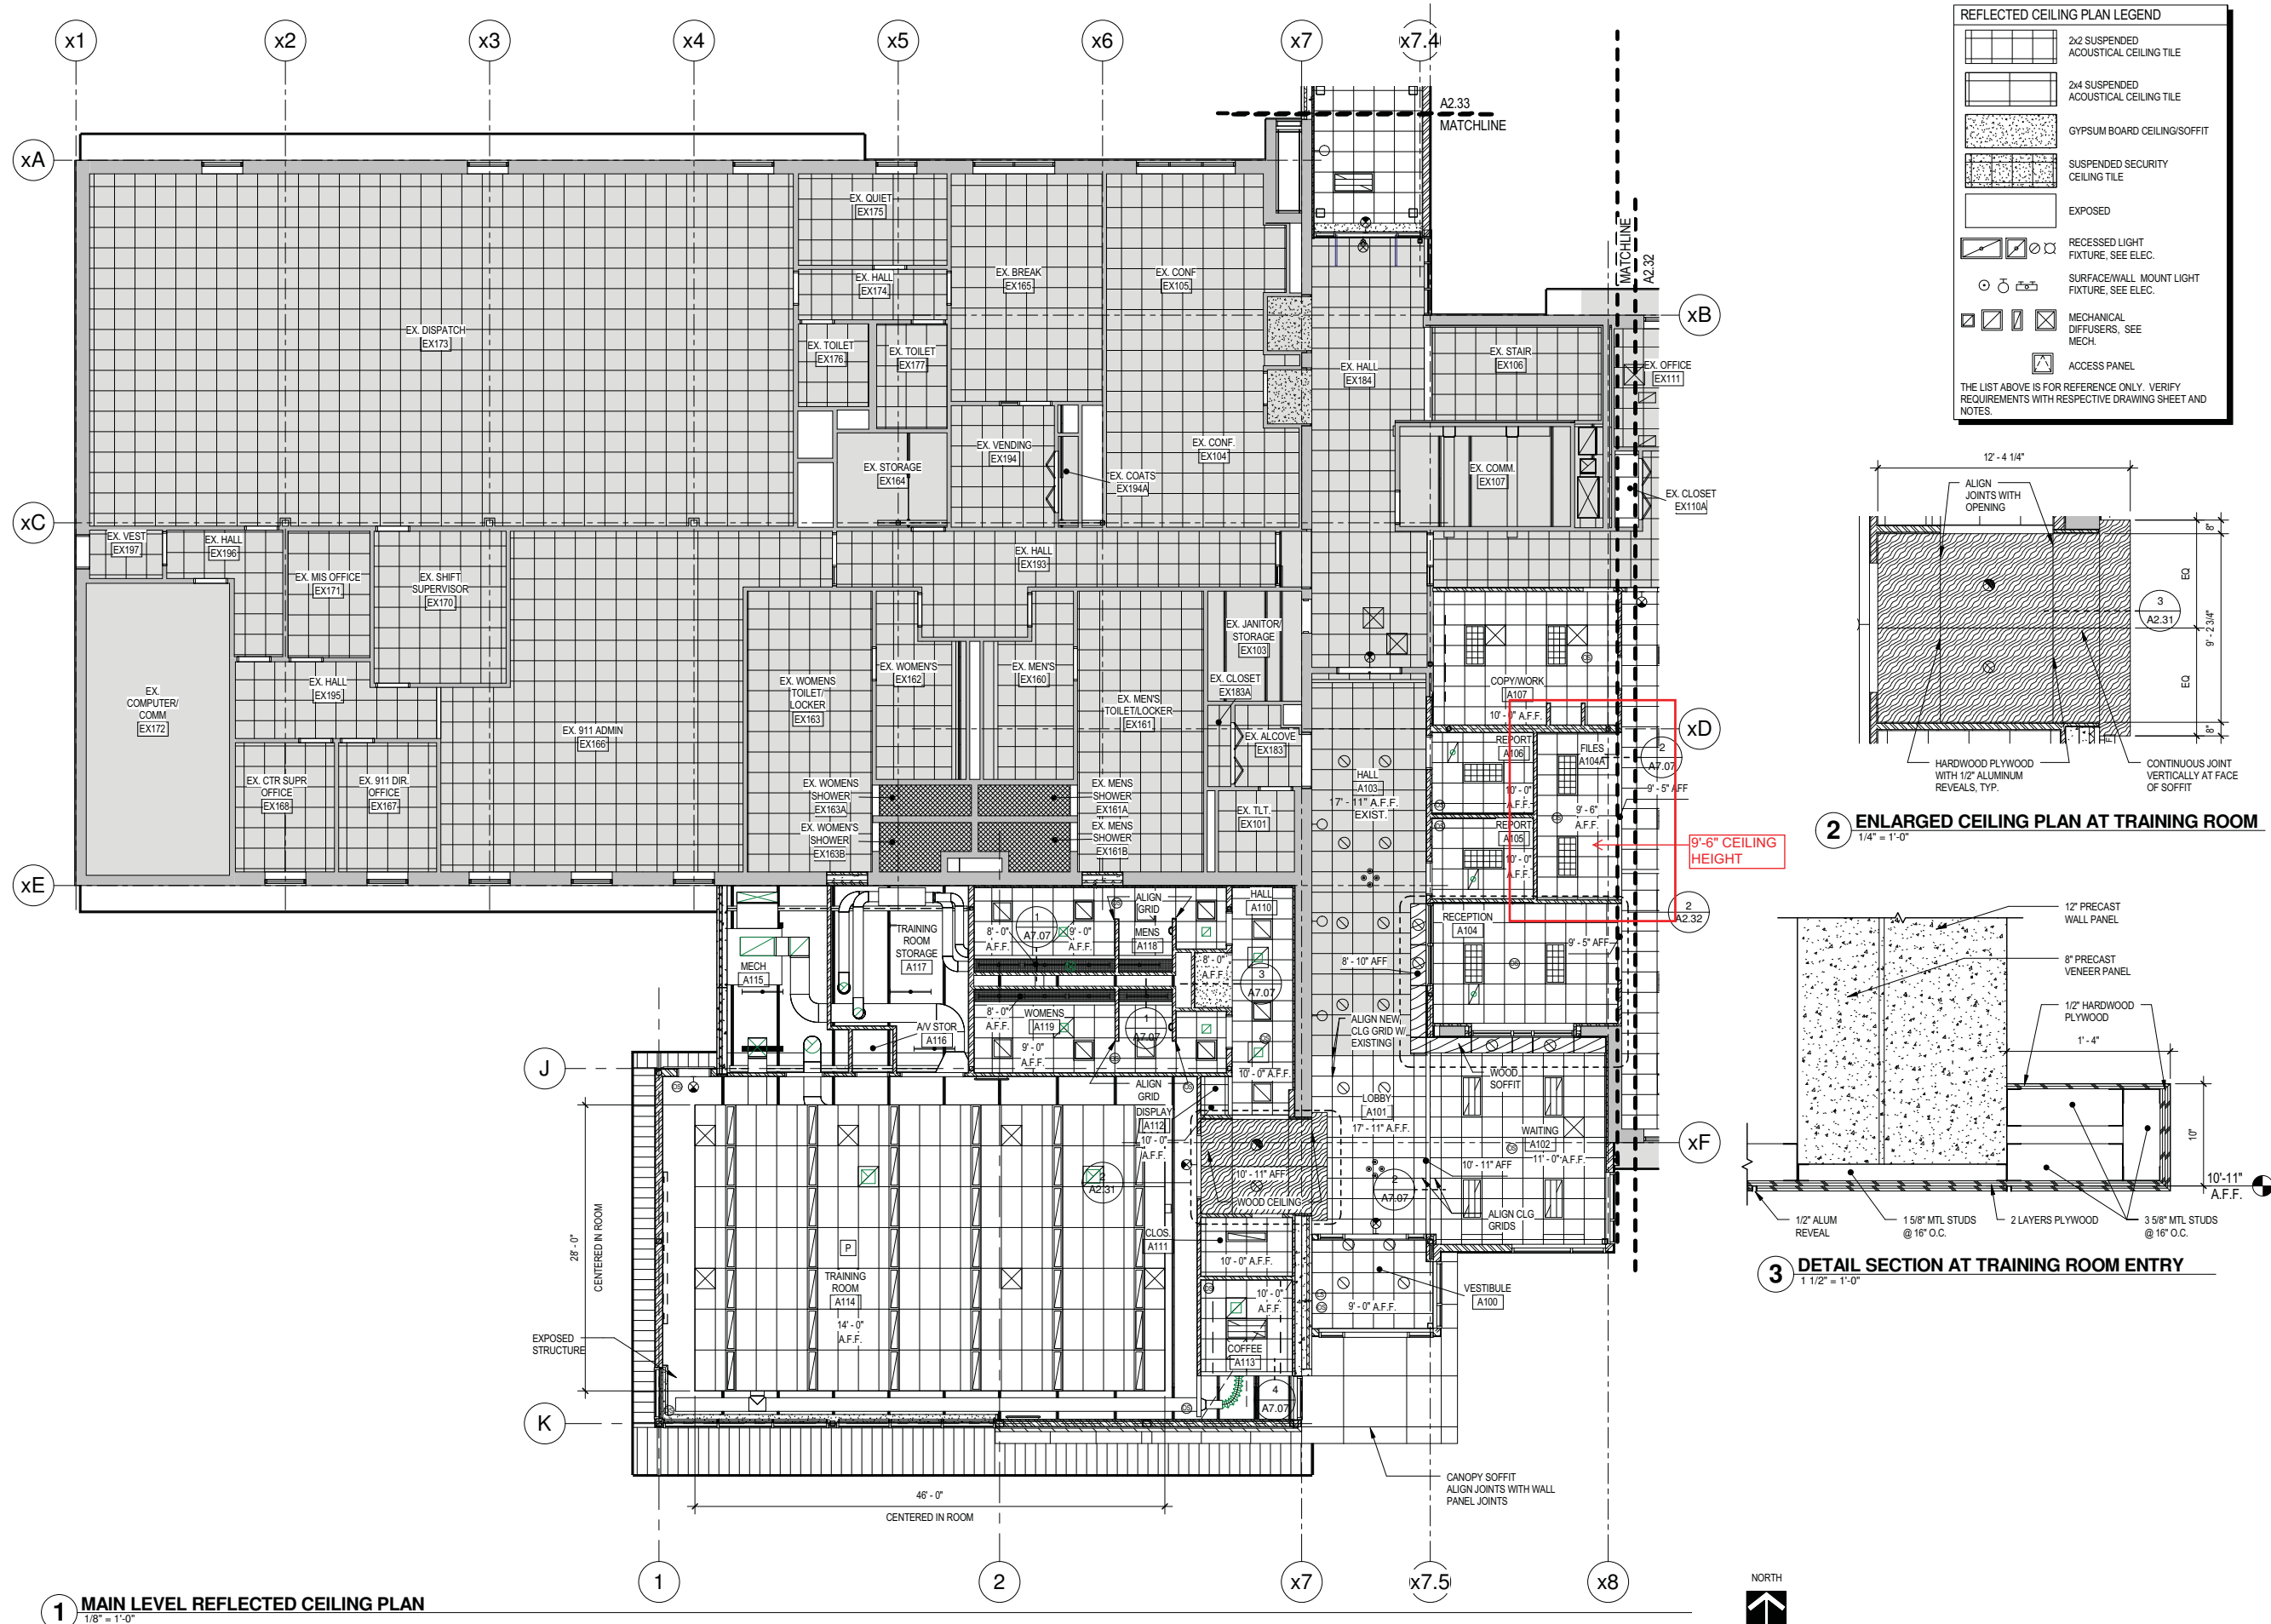


C:\Revit Local Files\080321 Duluth PD A10 Central_brlan.rvt
8/17/2010 1:25:56 PM

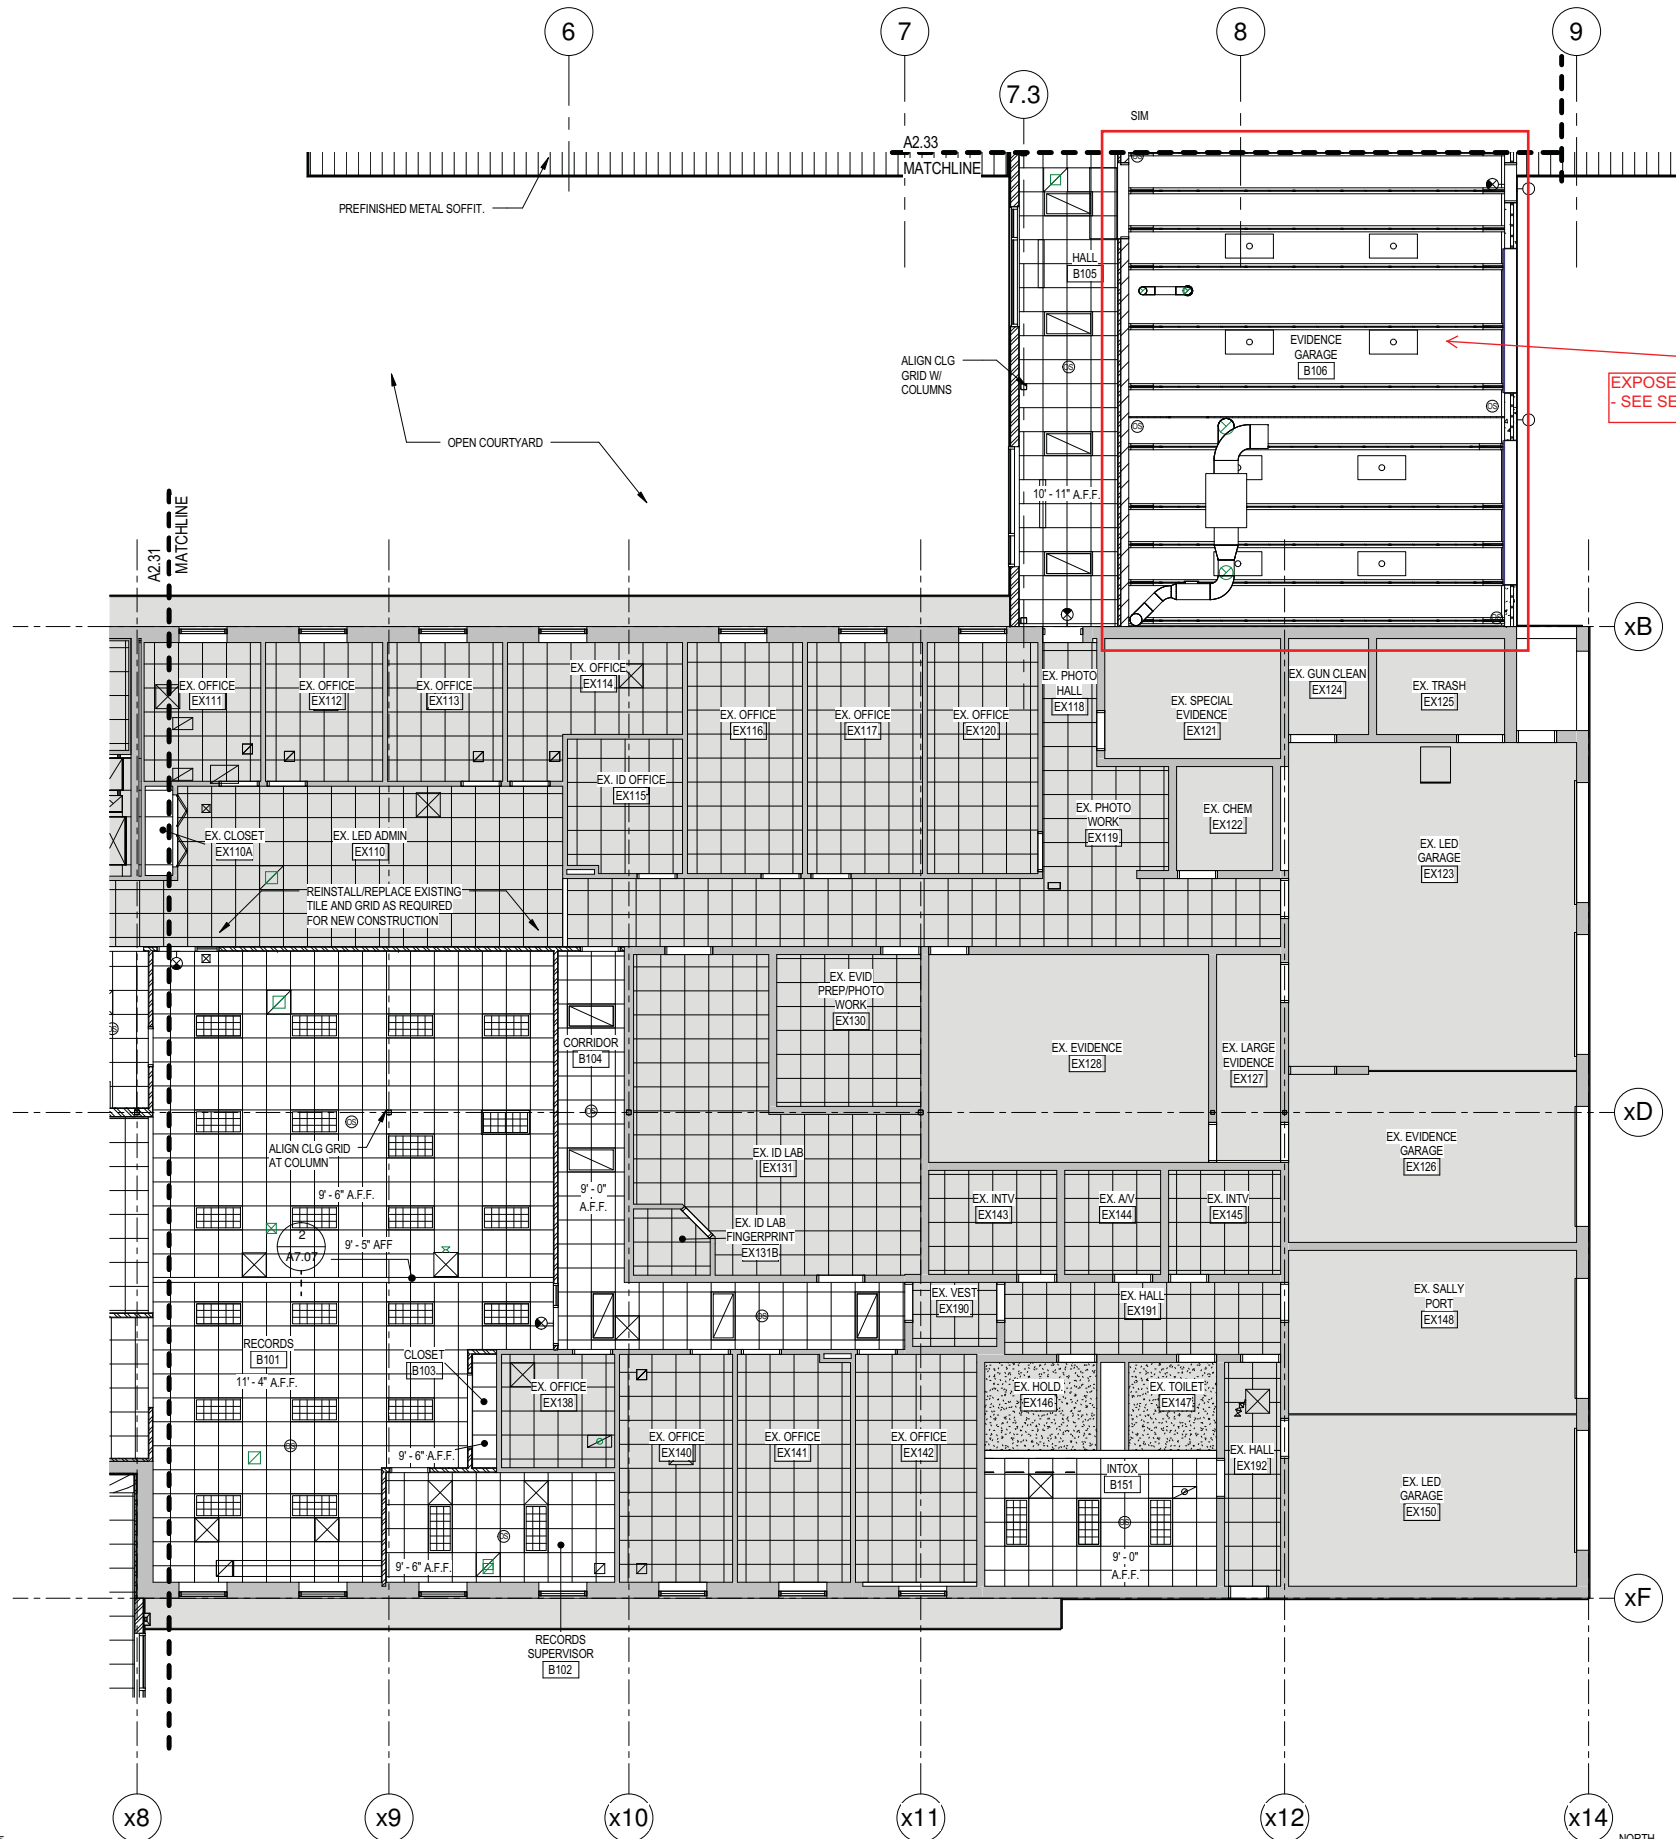


1 MAIN LEVEL REFLECTED CEILING PLAN
1/8" = 1'-0"

REFLECTED CEILING PLAN LEGEND	
	2x2 SUSPENDED ACOUSTICAL CEILING TILE
	2x4 SUSPENDED ACOUSTICAL CEILING TILE
	GYPSUM BOARD CEILING/SOFFIT
	SUSPENDED SECURITY CEILING TILE
	EXPOSED
	RECESSED LIGHT FIXTURE, SEE ELEC.
	SURFACE/WALL MOUNT LIGHT FIXTURE, SEE ELEC.
	MECHANICAL DIFFUSERS, SEE MECH.
	ACCESS PANEL
THE LIST ABOVE IS FOR REFERENCE ONLY. VERIFY REQUIREMENTS WITH RESPECTIVE DRAWING SHEET AND NOTES.	

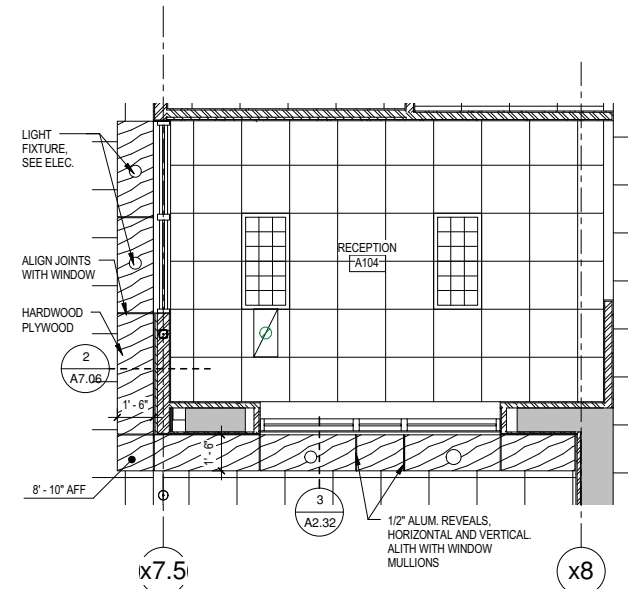

2 ENLARGED CEILING PLAN - RECEPTION
1/4" = 1'-0"

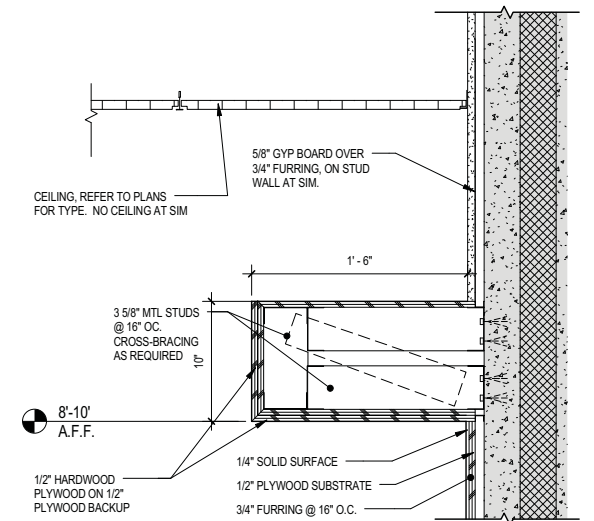

3 WOOD CEILING DETAIL 01
1 1/2" = 1'-0"

21 W. Superior Street
Suite 500
Duluth, MN 55802

TEL 218/727-8446
FAX 218/727-8456

http://www.LHBcorp.com

DULUTH □ MINNEAPOLIS



CONSULTANT


1161-A Lake Cook Rd.
Deerfield, IL 60015

TEL 847.272.9500
FAX 847.272.9510

srblarchitects.com

SRBL ARCHITECTS

KEYPLAN:

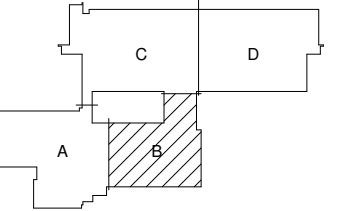

THIS SQUARE APPEARS 1/2"x1/2" ON FULL SIZE SHEETS

NOTED FOR OWNER EQUIPMENT PROCUREMENT 1/11/11

08/17/2010	100% SUBMITTAL
NO	DATE REVISION

I HEREBY CERTIFY that this plan, specification or report was prepared by me or under my direct supervision and that I am a duly Licensed Architect under the laws of the State of Minnesota.

Signature: *Cynthia I. Poirer*

Typed or Printed Name: CYNTHIA I. POIRER

Date: 08/17/10 Reg. No.: 22021

COPYRIGHT 2010 BY LHB, INC. ALL RIGHTS RESERVED

PROJECT TITLE:

**CITY OF DULUTH
POLICE
HEADQUARTERS**

DRAWING TITLE:

**MAIN LEVEL
REFLECTED CEILING
PLAN AREA B**

FILE: 080321 Duluth PD.rvt

DRAWN BY: BNLM/MH


CHECKED BY: CIP

PROJ. NO: 080321

DRAWING NO:

A2.32

C:\Revit Local Files\080321 Duluth PD A10 Central_Bldg.rvt
8/17/2010 1:28:05 PM

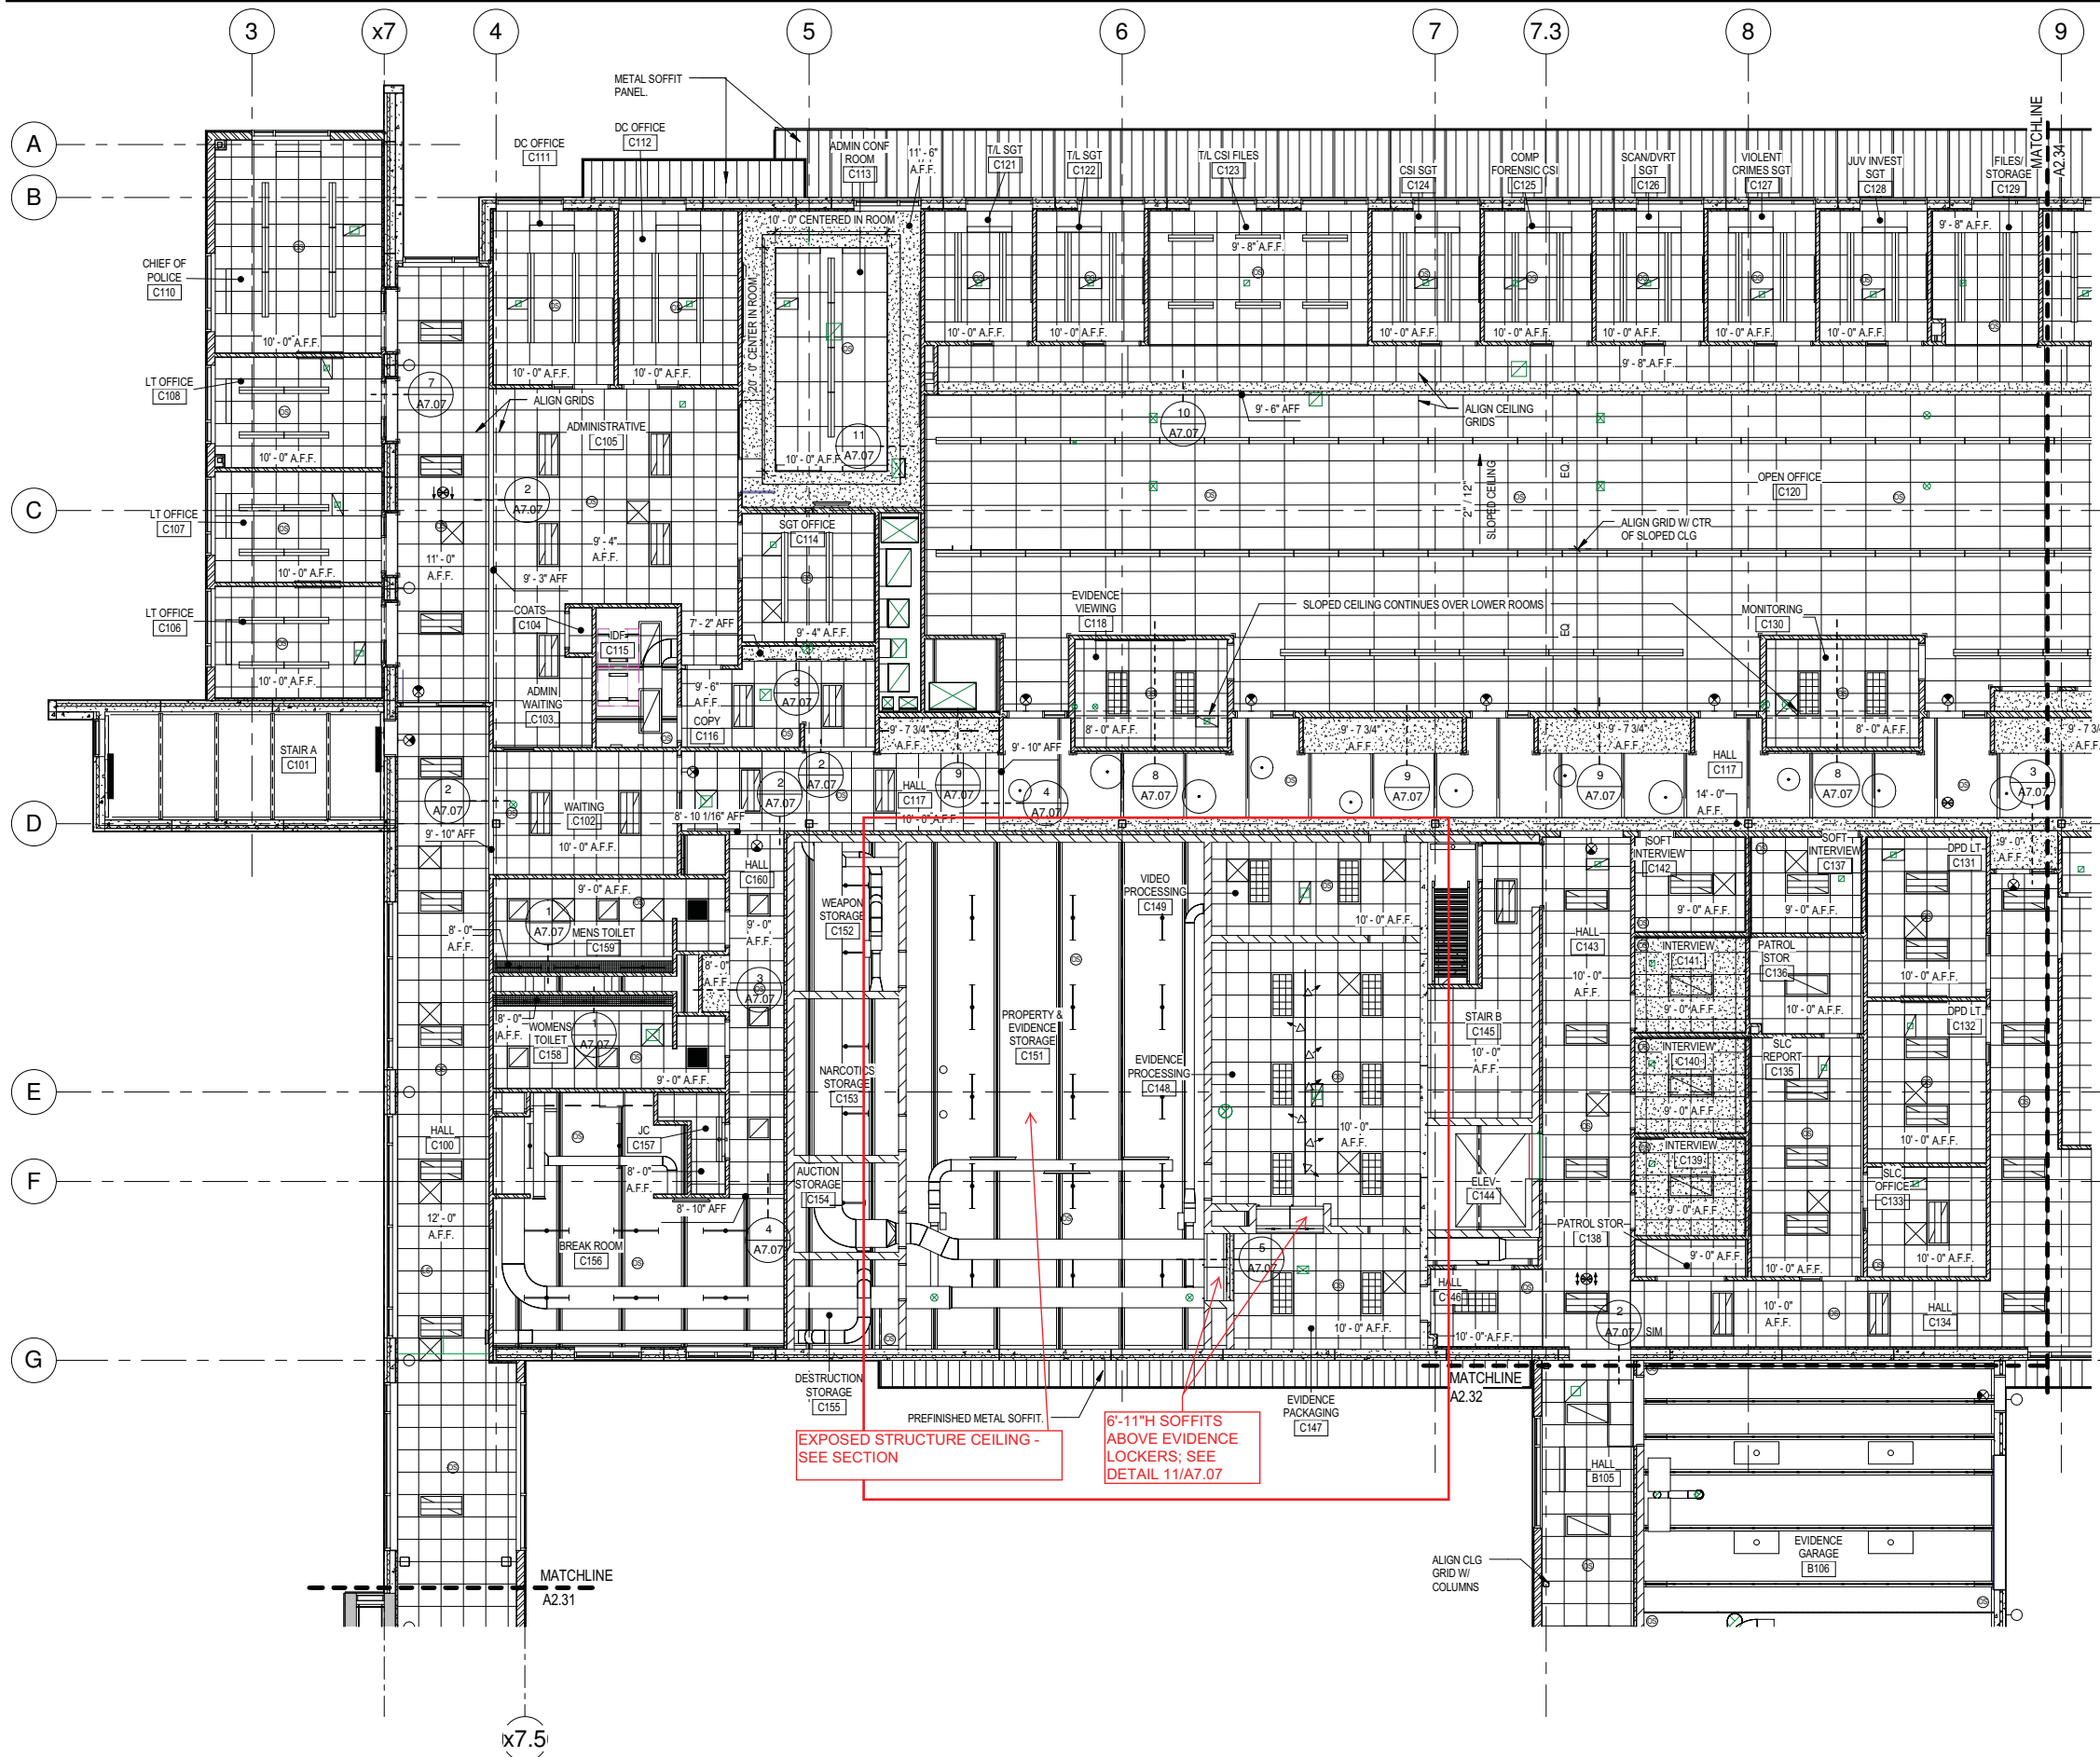

REFLECTED CEILING PLAN LEGEND

	2x2 SUSPENDED ACOUSTICAL CEILING TILE
	2x4 SUSPENDED ACOUSTICAL CEILING TILE
	GYPSUM BOARD CEILING/SOFFIT
	SUSPENDED SECURITY CEILING TILE
	EXPOSED
	RECESSED LIGHT FIXTURE, SEE ELEC.
	SURFACE/WALL MOUNT LIGHT FIXTURE, SEE ELEC.
	MECHANICAL DIFFUSERS, SEE MECH.
	ACCESS PANEL

THE LIST ABOVE IS FOR REFERENCE ONLY. VERIFY REQUIREMENTS WITH RESPECTIVE DRAWING SHEET AND NOTES.

21 W. Superior Street
Suite 500
Duluth, MN 55802

TEL 218/727-8446
FAX 218/727-8456

http://www.LHBcorp.com

DULUTH □ MINNEAPOLIS


SRBL ARCHITECTS

CONSULTANT

1161-A Lake Cook Rd.
Deerfield, IL 60015

TEL 847.272.9500
FAX 847.272.9510

srblarchitects.com

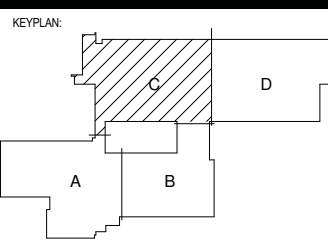

THIS SQUARE APPEARS 1/2"x1/2" ON FULL SIZE SHEETS

NOTED FOR OWNER EQUIPMENT PROCUREMENT 1/11/11

NO	DATE	REVISION
	08/17/2010	100% SUBMITTAL

I HEREBY CERTIFY that this plan, specification or report was prepared by me or under my direct supervision and that I am a duly Licensed Architect under the laws of the State of Minnesota.

Signature: *Cynthia I. Poirier*

Typed or Printed Name: CYNTHIA I. POIRIER

Date: 08/17/10 Reg. No.: 22021

COPYRIGHT 2010 BY LHB, INC. ALL RIGHTS RESERVED

PROJECT TITLE:

CITY OF DULUTH POLICE HEADQUARTERS

DRAWING TITLE:

MAIN LEVEL REFLECTED CEILING PLAN AREA C

FILE: 080321 Duluth PD.rvt
DRAWN BY: BNLM/HH
CHECKED BY: CIP
PROJ. NO.: 080321
DRAWING NO:

A2.33

1 MAIN LEVEL REFLECTED CEILING PLAN
1/8" = 1'-0"



21 W. Superior Street
Suite 500
Duluth, MN 55802

TEL 218/727-8446
FAX 218/727-8456

http://www.LHBcorp.com

DULUTH □ MINNEAPOLIS

CONSULTANT
SRBL
1161-A Lake Cook Rd.
Deerfield, IL 60015
TEL 847.272.9500
FAX 847.272.9510
srblarchitects.com
SRBL ARCHITECTS

KEYPLAN:

THIS SQUARE APPEARS 1/2"x1/2" ON
FULL SIZE SHEETS

NOTED FOR OWNER EQUIPMENT
PROCUREMENT 1/11/11

08/17/2010	100% SUBMITTAL
NO	DATE REVISION

I HEREBY CERTIFY that this plan,
specification or report was prepared by me
or under my direct supervision and that I am
a duly Licensed Architect under the laws of
the State of Minnesota.

Signature: *Cynthia I. Poirer*

Typed or Printed Name: CYNTHIA I. POIRER

Date: 08/17/10 Reg. No.: 22021

COPYRIGHT 2010 BY LHB, INC. ALL RIGHTS RESERVED

PROJECT TITLE:


**CITY OF DULUTH
POLICE
HEADQUARTERS**

DRAWING TITLE:


BUILDING SECTIONS

FILE: 080321 Duluth PD.rvt
DRAWN BY: BNL/MMH
CHECKED BY: CIP
PROJ. NO: 080321
DRAWING NO:


A3.11

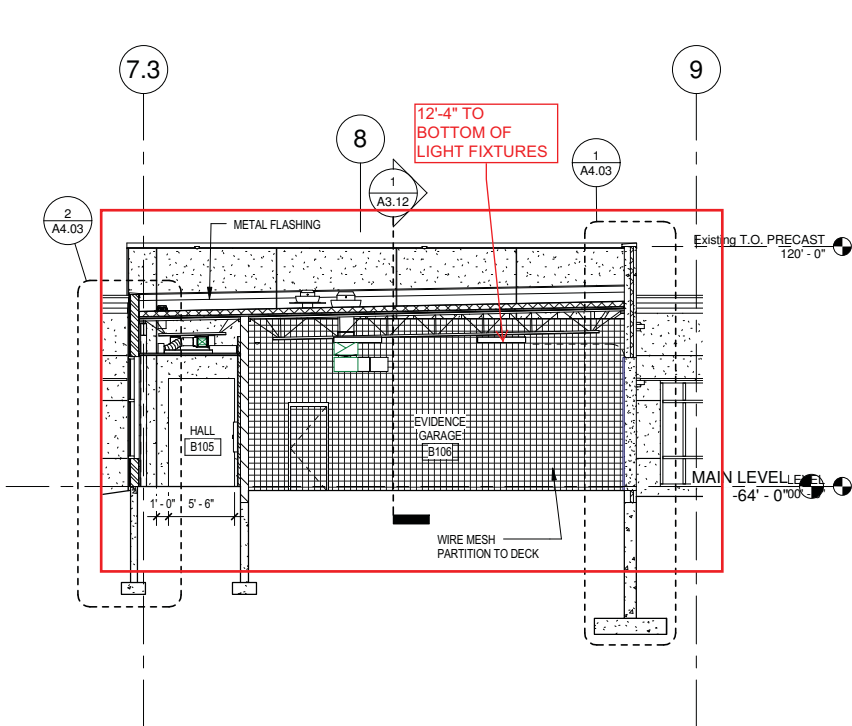


2 E-W SECTION AT EVIDENCE GARAGE
1/8" = 1'-0"

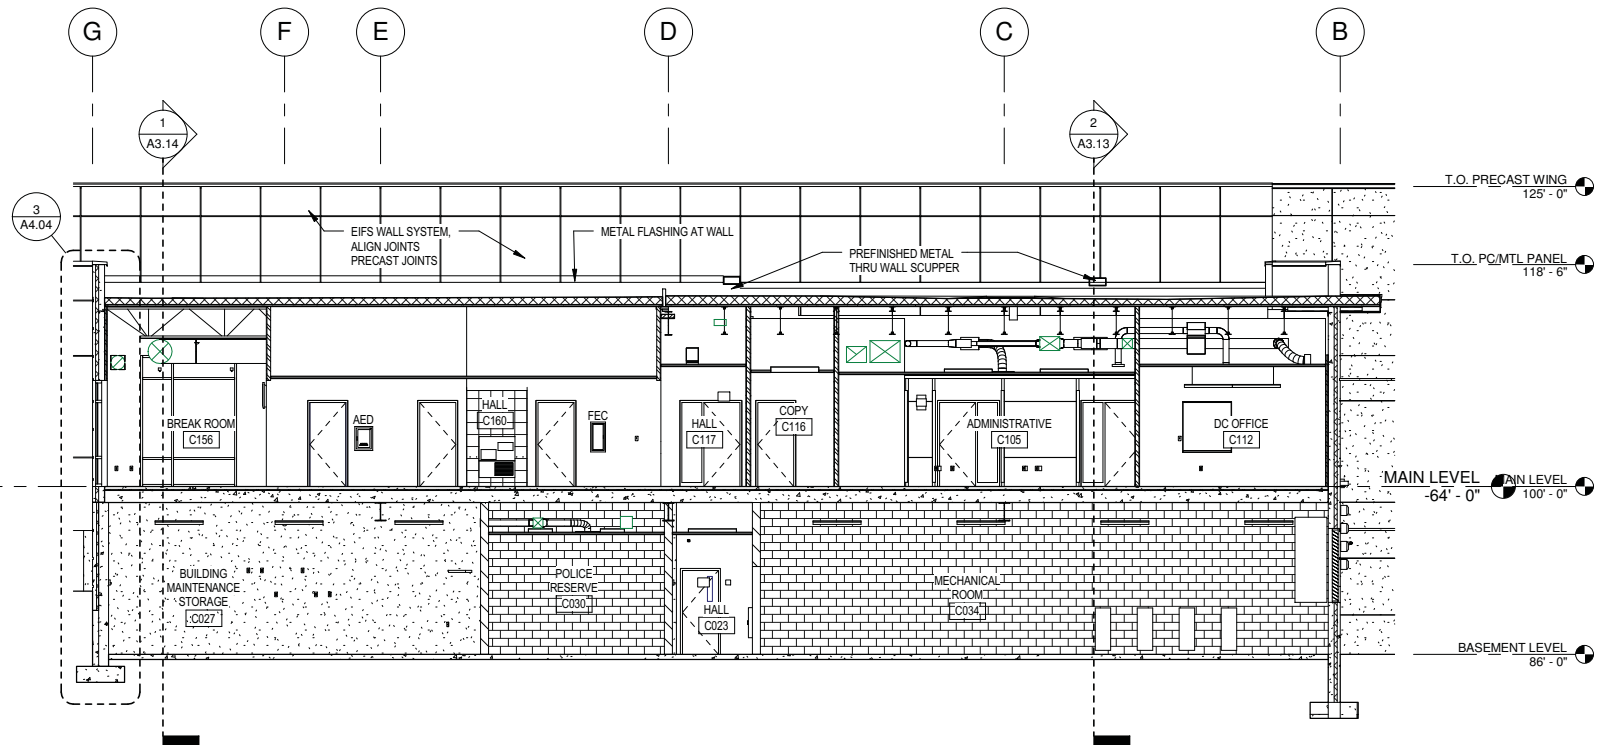


3 N-S BUILDING SECTION AT GRID 4
1/8" = 1'-0"

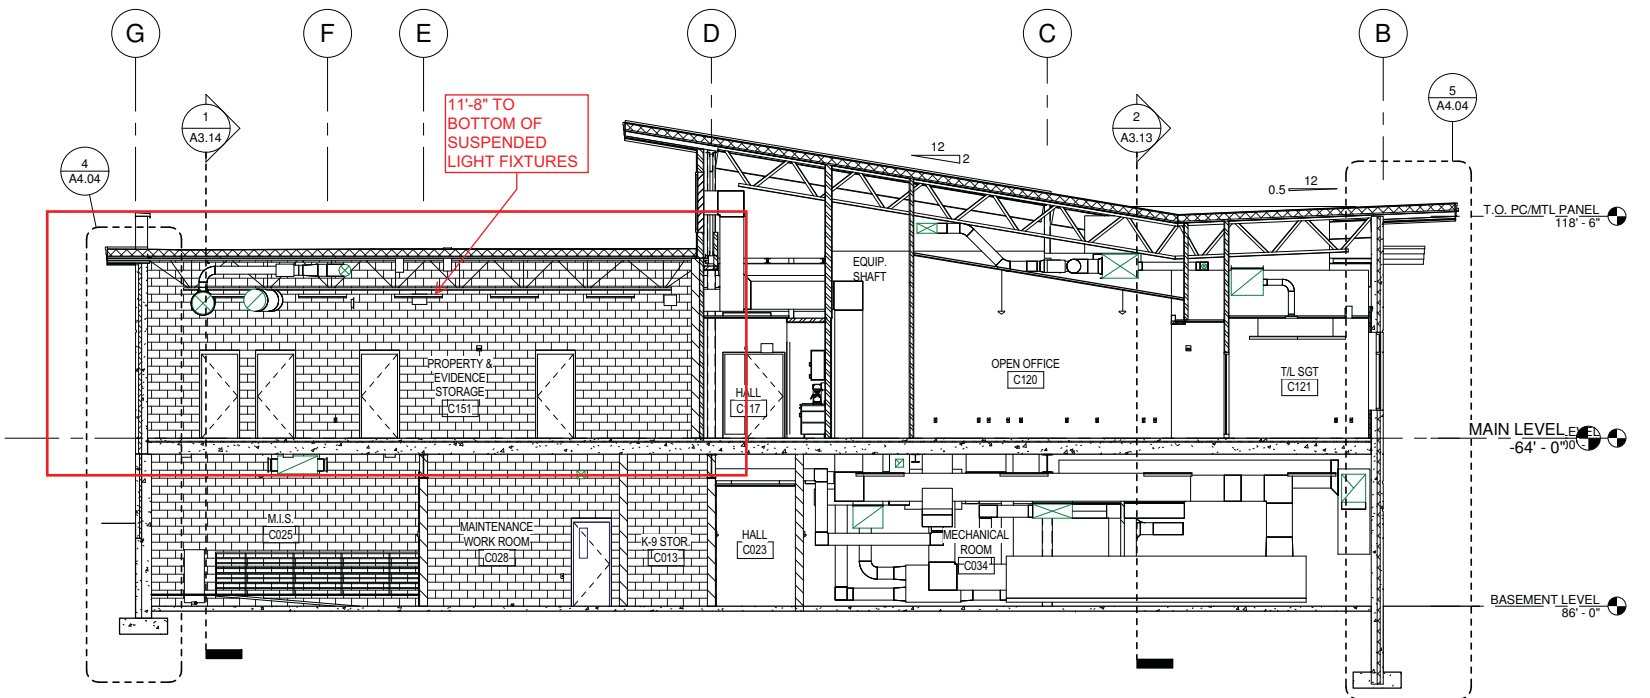


1 N-S BUILDING SECTION AG GRID 6
1/8" = 1'-0"

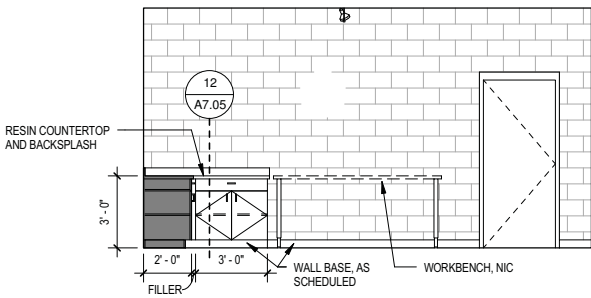


4 C148 EVIDENCE PROCESSING - N
1/4" = 1'-0"

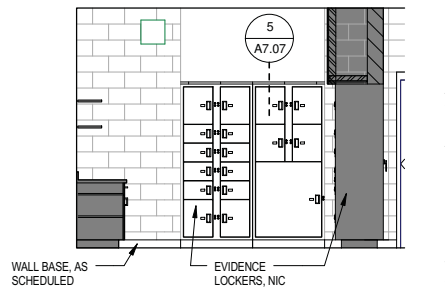


3 C147 EVIDENCE PACKAGING - W
1/4" = 1'-0"

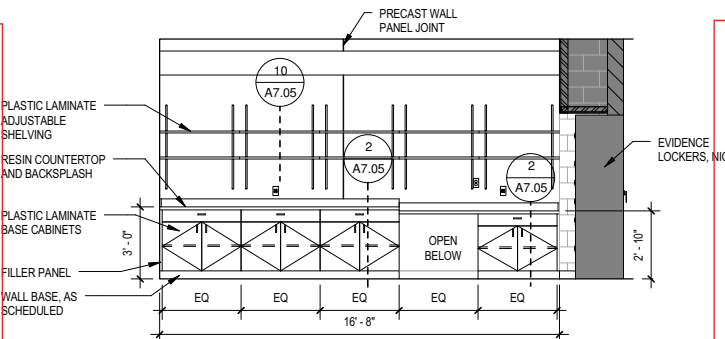


2 C147 EVIDENCE PACKAGING - S
1/4" = 1'-0"

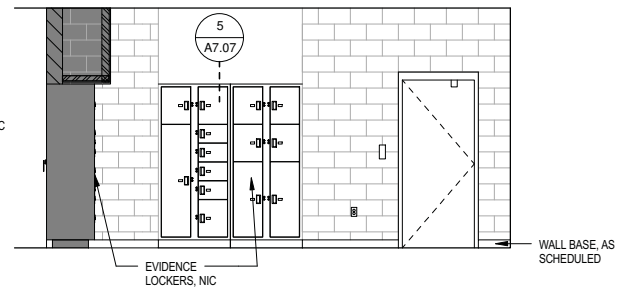


1 C147 EVIDENCE PACKAGING - N
1/4" = 1'-0"

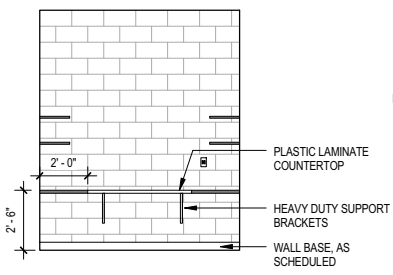


8 C149 VIDEO PROCESSING - W
1/4" = 1'-0"

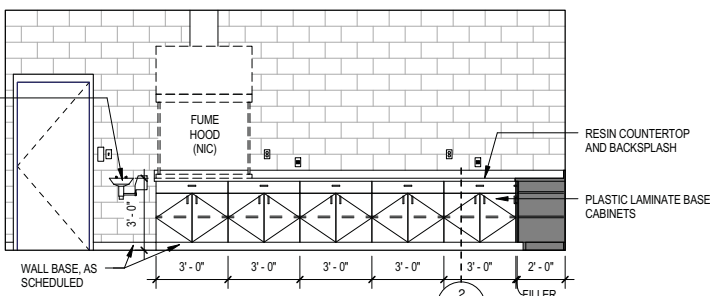


7 C148 EVIDENCE PROCESSING - W
1/4" = 1'-0"

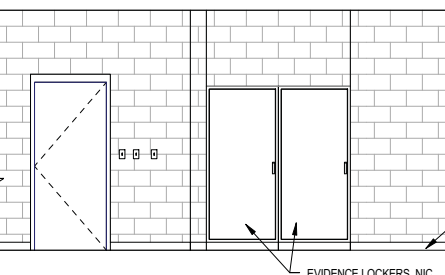


6 C148 EVIDENCE PROCESSING - S
1/4" = 1'-0"

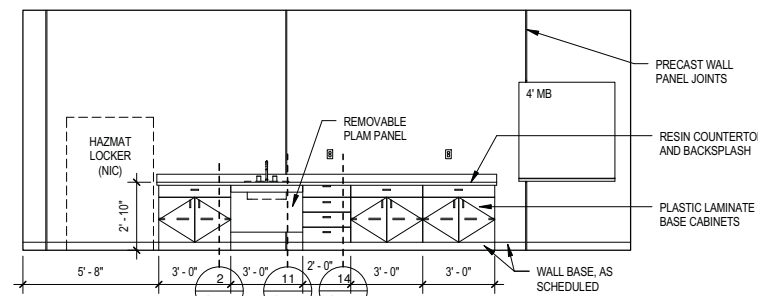


5 C148 EVIDENCE PROCESSING - E
1/4" = 1'-0"

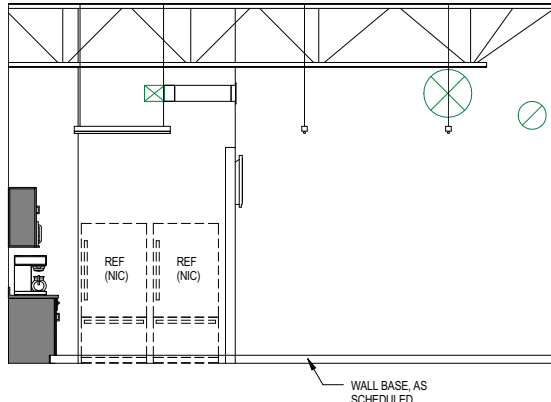


12 C156 BREAK ROOM - E
1/4" = 1'-0"

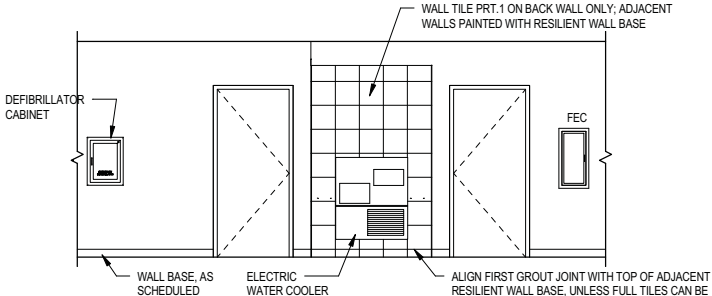


11 C160 HALL - DRINKING FOUNTAIN
1/4" = 1'-0"

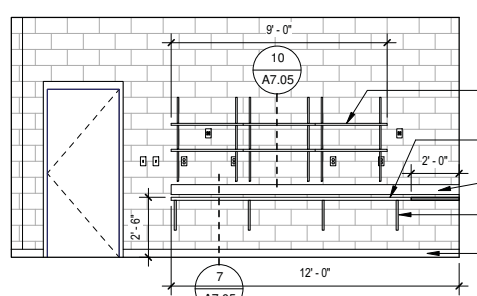


10 C149 VIDEO PROCESSING - S
1/4" = 1'-0"

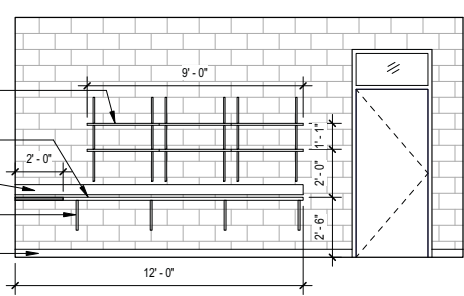


9 C149 VIDEO PROCESSING - N
1/4" = 1'-0"

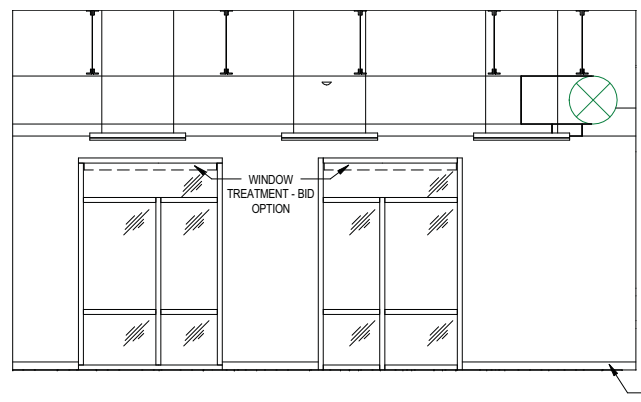

15 C156 BREAK ROOM - S
1/4" = 1'-0"

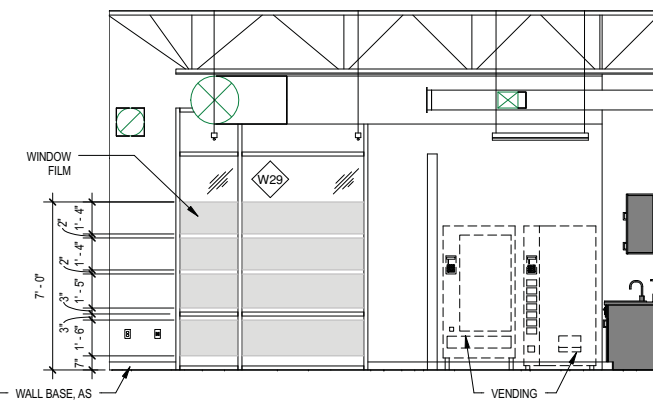

14 C156 BREAK ROOM - W
1/4" = 1'-0"

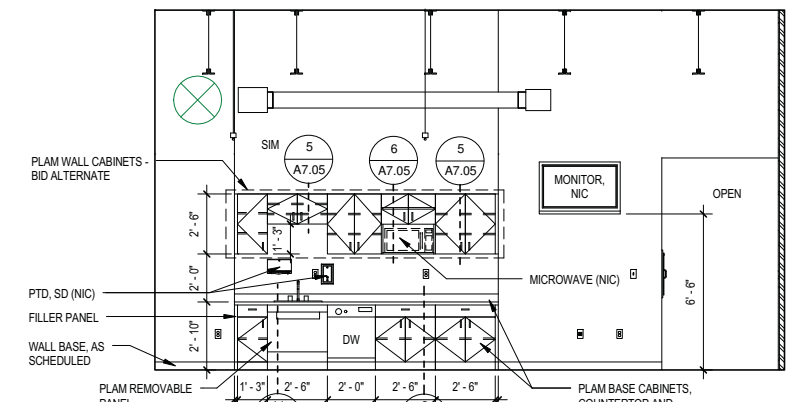

13 C156 BREAK ROOM - N
1/4" = 1'-0"

21 W. Superior Street
Suite 500
Duluth, MN 55802

TEL 218/727-8446
FAX 218/727-8456

http://www.LHBcorp.com

DULUTH □ MINNEAPOLIS

SRBL
SRBL ARCHITECTS

CONSULTANT

1161-A Lake Cook Rd.
Deerfield, IL 60015
TEL 847.272.9500
FAX 847.272.9510
srblarchitects.com

KEYPLAN:

THIS SQUARE APPEARS 1/2"x1/2" ON
FULL SIZE SHEETS

**NOTED FOR OWNER EQUIPMENT
PROCUREMENT 1/11/11**

NO	DATE	REVISION
08/17/2010	100% SUBMITTAL	

I HEREBY CERTIFY that this plan,
specification or report was prepared by me
or under my direct supervision and that I am
a duly Licensed Architect under the laws of
the State of Minnesota.

Signature: *Cynthia I. Poirier*

Typed or Printed Name: CYNTHIA I. POIRIER

Date: 08/17/10 Reg. No.: 22021

COPYRIGHT 2010 BY LHB, INC. ALL RIGHTS RESERVED


PROJECT TITLE:

**CITY OF DULUTH
POLICE
HEADQUARTERS**


DRAWING TITLE:
INTERIOR ELEVATIONS

FILE: 080321 Duluth PD.rvt
DRAWN BY: BNLMH
CHECKED BY: CIP
PROJ. NO: 080321
DRAWING NO:


A5.05

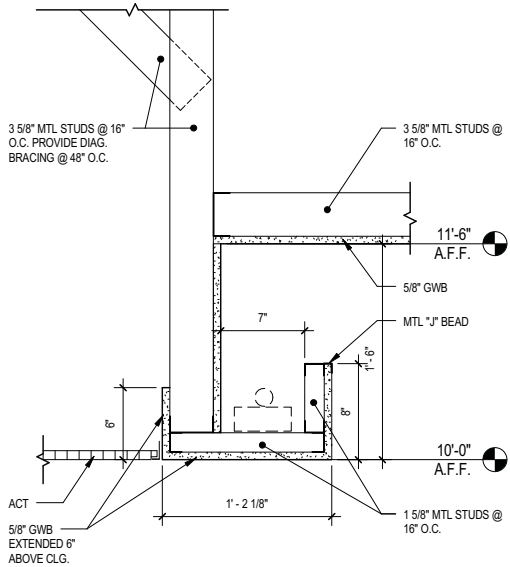


11 LIGHT COVE SECTION DETAIL ADMIN CONF ROOM
1 1/2" = 1'-0"

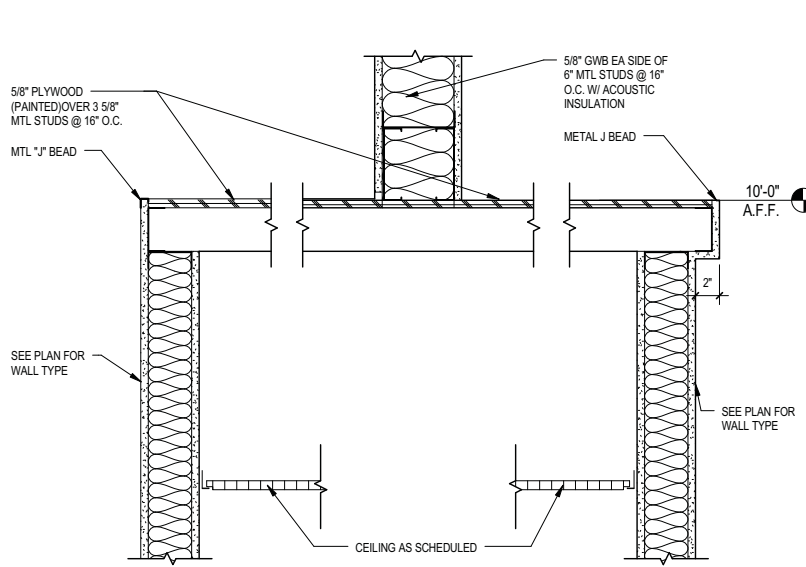


8 CEILING DETAIL AT EVIDENCE VIEWING AND MONITORING
1 1/2" = 1'-0"

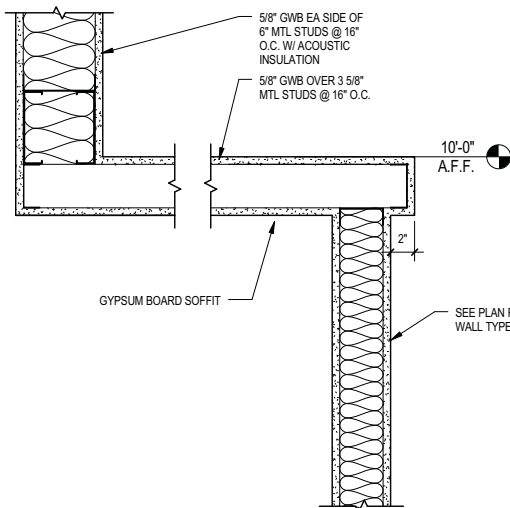


12 CEILING DETAIL AT HALLWAY ALCOVES
1 1/2" = 1'-0"

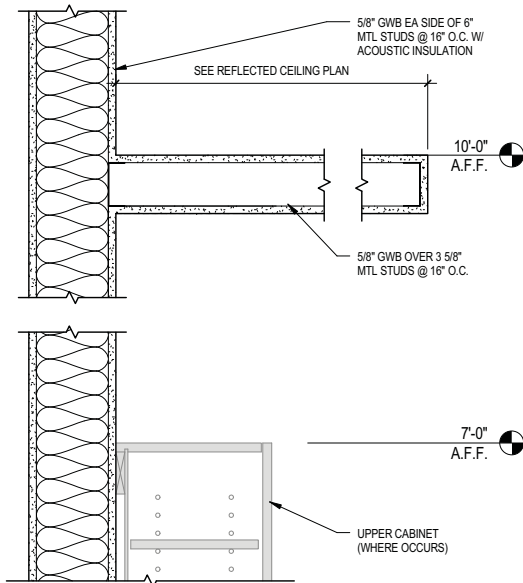


9 SOFFIT DETAIL AT HALLWAY CASEWORK ALCOVES
1 1/2" = 1'-0"

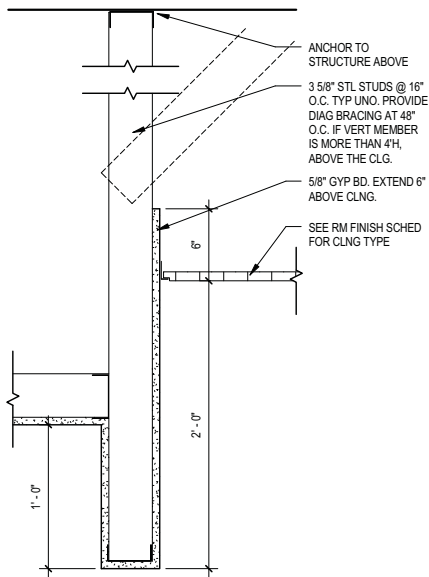


13 CEILING TRANSITION AT SHOWERS
1 1/2" = 1'-0"

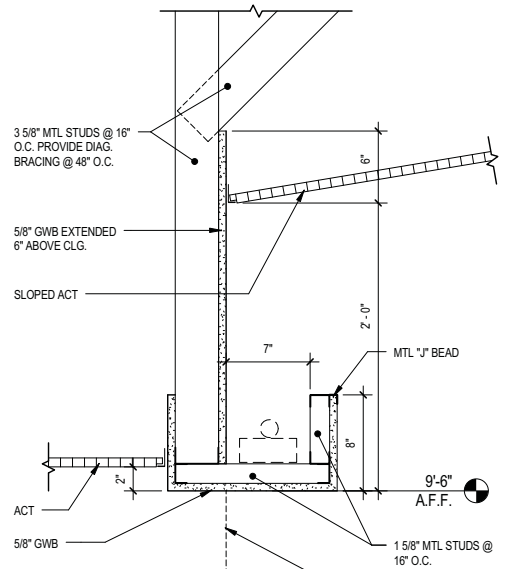


10 LIGHT COVE SECTION DETAIL
1 1/2" = 1'-0"

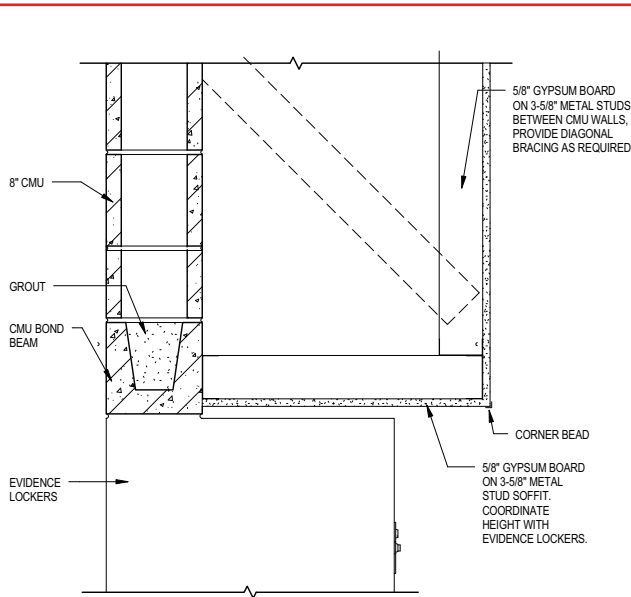


5 SOFFIT DETAIL AT EVIDENCE LOCKERS
1 1/2" = 1'-0"

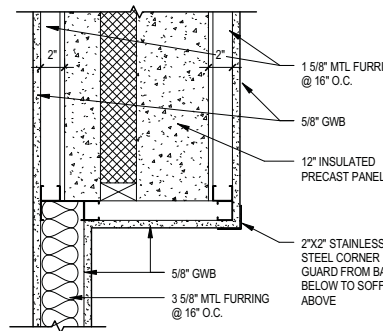


6 PLAN DETAIL AT ADMIN
1 1/2" = 1'-0"

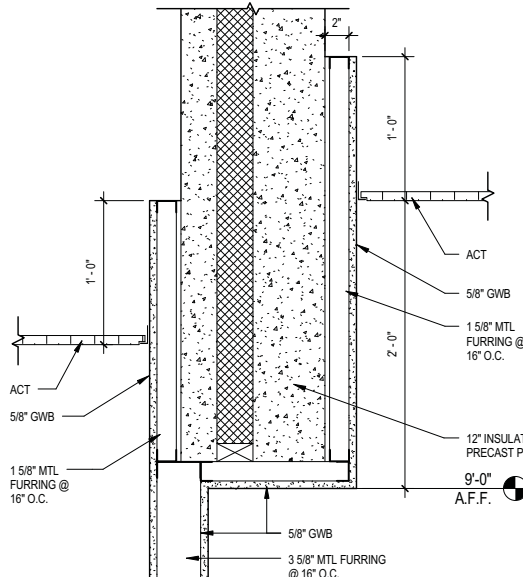


7 SOFFIT DETAIL AT ADMIN
1 1/2" = 1'-0"

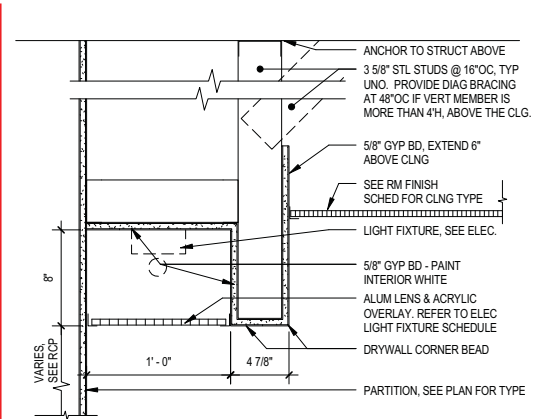


1 RECESSED LIGHT/ SOFFIT DETAIL
1 1/2" = 1'-0"

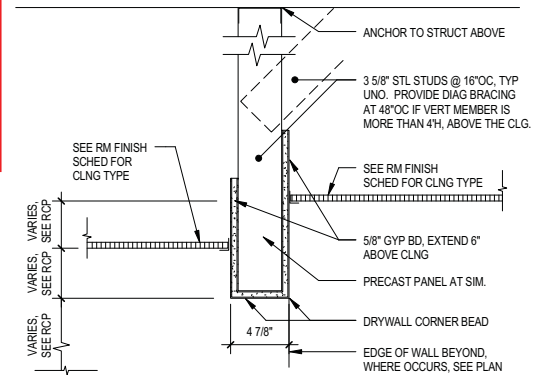

2 SOFFIT DETAIL
1 1/2" = 1'-0"

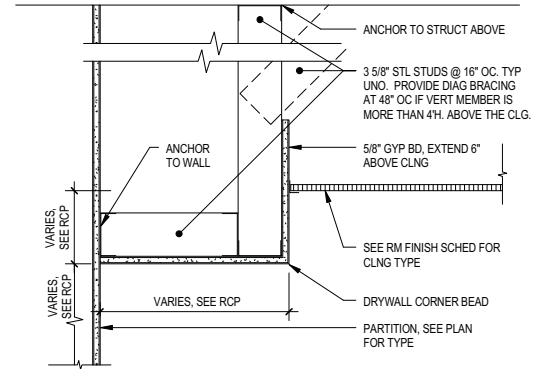

3 SOFFIT DETAIL
1 1/2" = 1'-0"

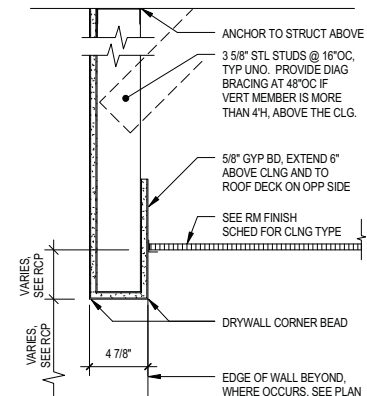

4 SOFFIT DETAIL
1 1/2" = 1'-0"

21 W. Superior Street
Suite 500
Duluth, MN 55802

TEL 218/727-8446
FAX 218/727-8456

http://www.LHBcorp.com

DULUTH □ MINNEAPOLIS



CONSULTANT
1161-A Lake Cook Rd.
Deerfield, IL 60015
TEL 847.272.9500
FAX 847.272.9510
srblarchitects.com

SRBL ARCHITECTS

KEYPLAN:

THIS SQUARE APPEARS 1/2"x1/2" ON
FULL SIZE SHEETS

NOTED FOR OWNER EQUIPMENT
PROCUREMENT 1/11/11

08/17/2010 100% SUBMITTAL
NO DATE REVISION

I HEREBY CERTIFY that this plan,
specification or report was prepared by me
or under my direct supervision and that I am
a duly Licensed Architect under the laws of
the State of Minnesota.

Signature: Cynthia I. Poirer

Typed or Printed Name: CYNTHIA I. POIRER

Date: 08/17/10 Reg. No.: 22021

COPYRIGHT 2010 BY LHB, INC. ALL RIGHTS RESERVED

PROJECT TITLE:

CITY OF DULUTH
POLICE
HEADQUARTERS

DRAWING TITLE:

INTERIOR DETAILS

FILE: 080321 Duluth PD.rvt

DRAWN BY: BNLMH

CHECKED BY: CIP

PROJ. NO: 080321

DRAWING NO:

A7.07