


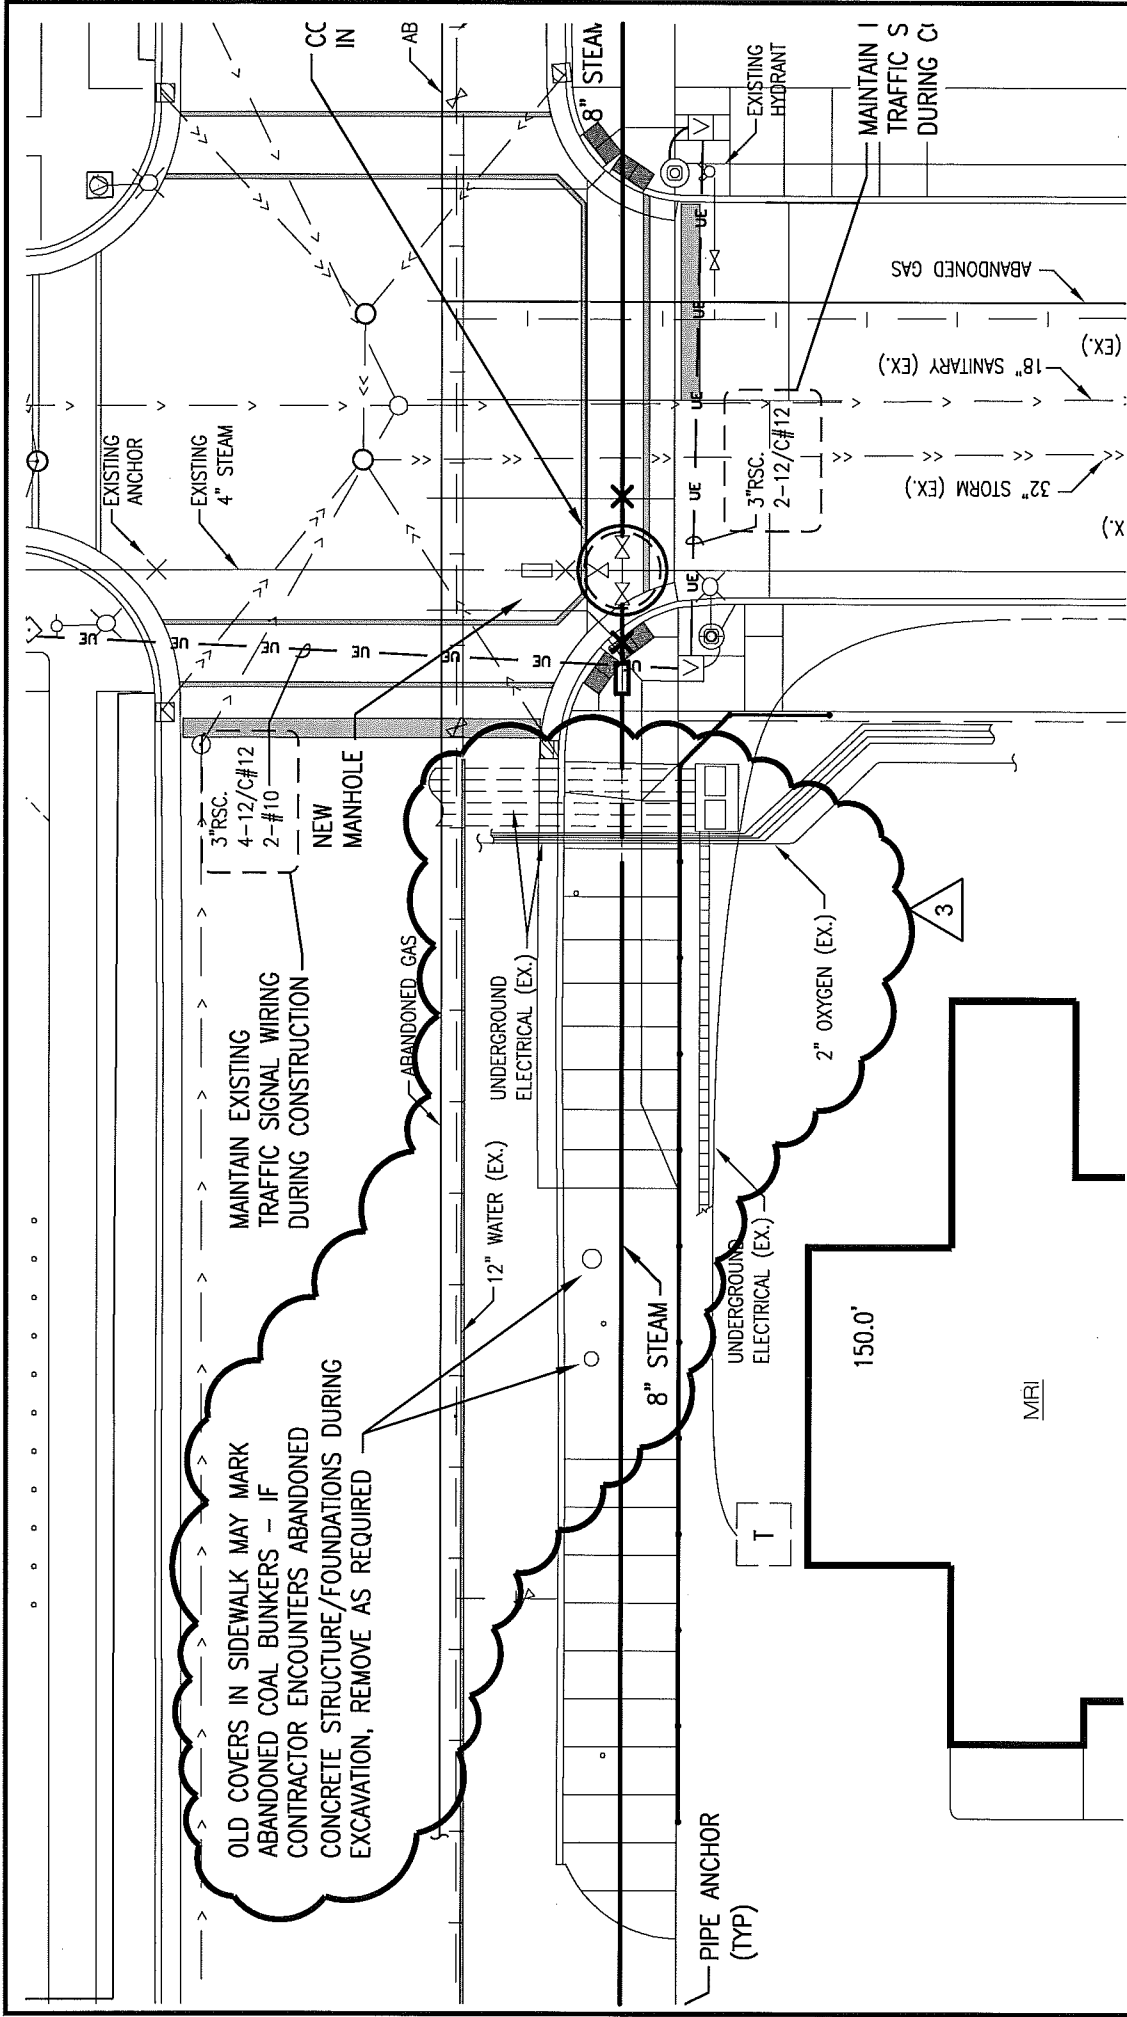


1 M1

PARTIAL SITE PLAN

1" = 20'-0"

PLAN NORTH


TRUE

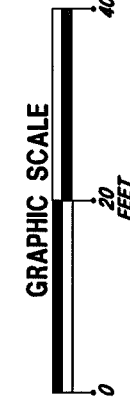

3 ADDENDUM DRAWING

FOSTER, JACOBS & JOHNSON, INC. PROFESSIONAL ENGINEERS 345 CANAL PARK DRIVE SUITE 200 DULUTH, MINNESOTA 55802	DATE: 6/16/2011 BY: MRA/JRJ PROJECT: 11027	DRAWING NO: M1A
	Duluth Steam - St. Luke's Steam Extension Duluth, Minnesota	

Sheet 1 of 1

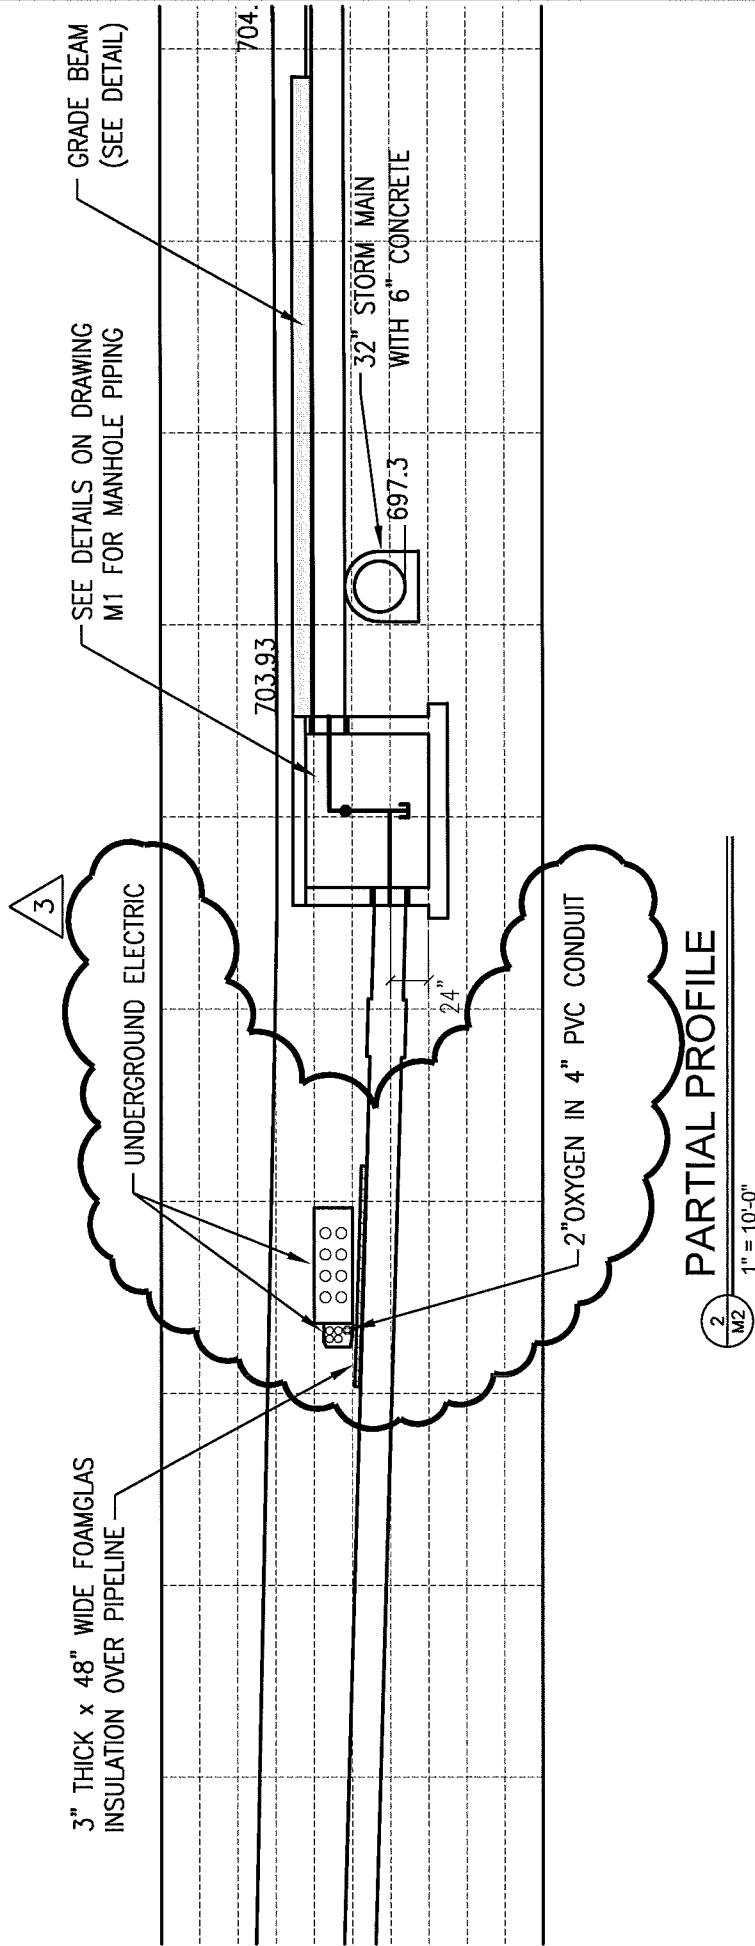

3

ADDENDUM DRAWING

DRAWING NO:

DATE: 6/16/2011

BY: MRA/JRJ

PROJECT: 11027

M2A

LINE IS 1 INCH AT FULL SIZE (IF NOT 1-SHEET ACCORDING)

Sheet 1 of 1

Duluth Steam - St. Luke's
Steam Extension
Duluth, Minnesota

FOSTER, JACOBS & JOHNSON, INC.
PROFESSIONAL ENGINEERS

345 CANAL PARK DRIVE
SUITE 200
DULUTH, MINNESOTA 55802

218.722.3060

218.722.1931 fax

Email: mal@fji.com

