

REVISIONS	
NO.	DESCRIPTION


NO.	DESCRIPTION	DATE

DATE ISSUED: 10-30-09
REVIEWED BY: XXX
DRAWN BY: JK
DESIGNED BY: JK
AEP PROJECT NUMBER 213-1882-091
©2009 REYNOLDS, SMITH AND HILLS INC.

SHEET TITLE ENLARGED FIRST FLOOR ELECTRICAL PLAN AREA A

SHEET NUMBER E110

30% NOT FOR CONSTRUCTION

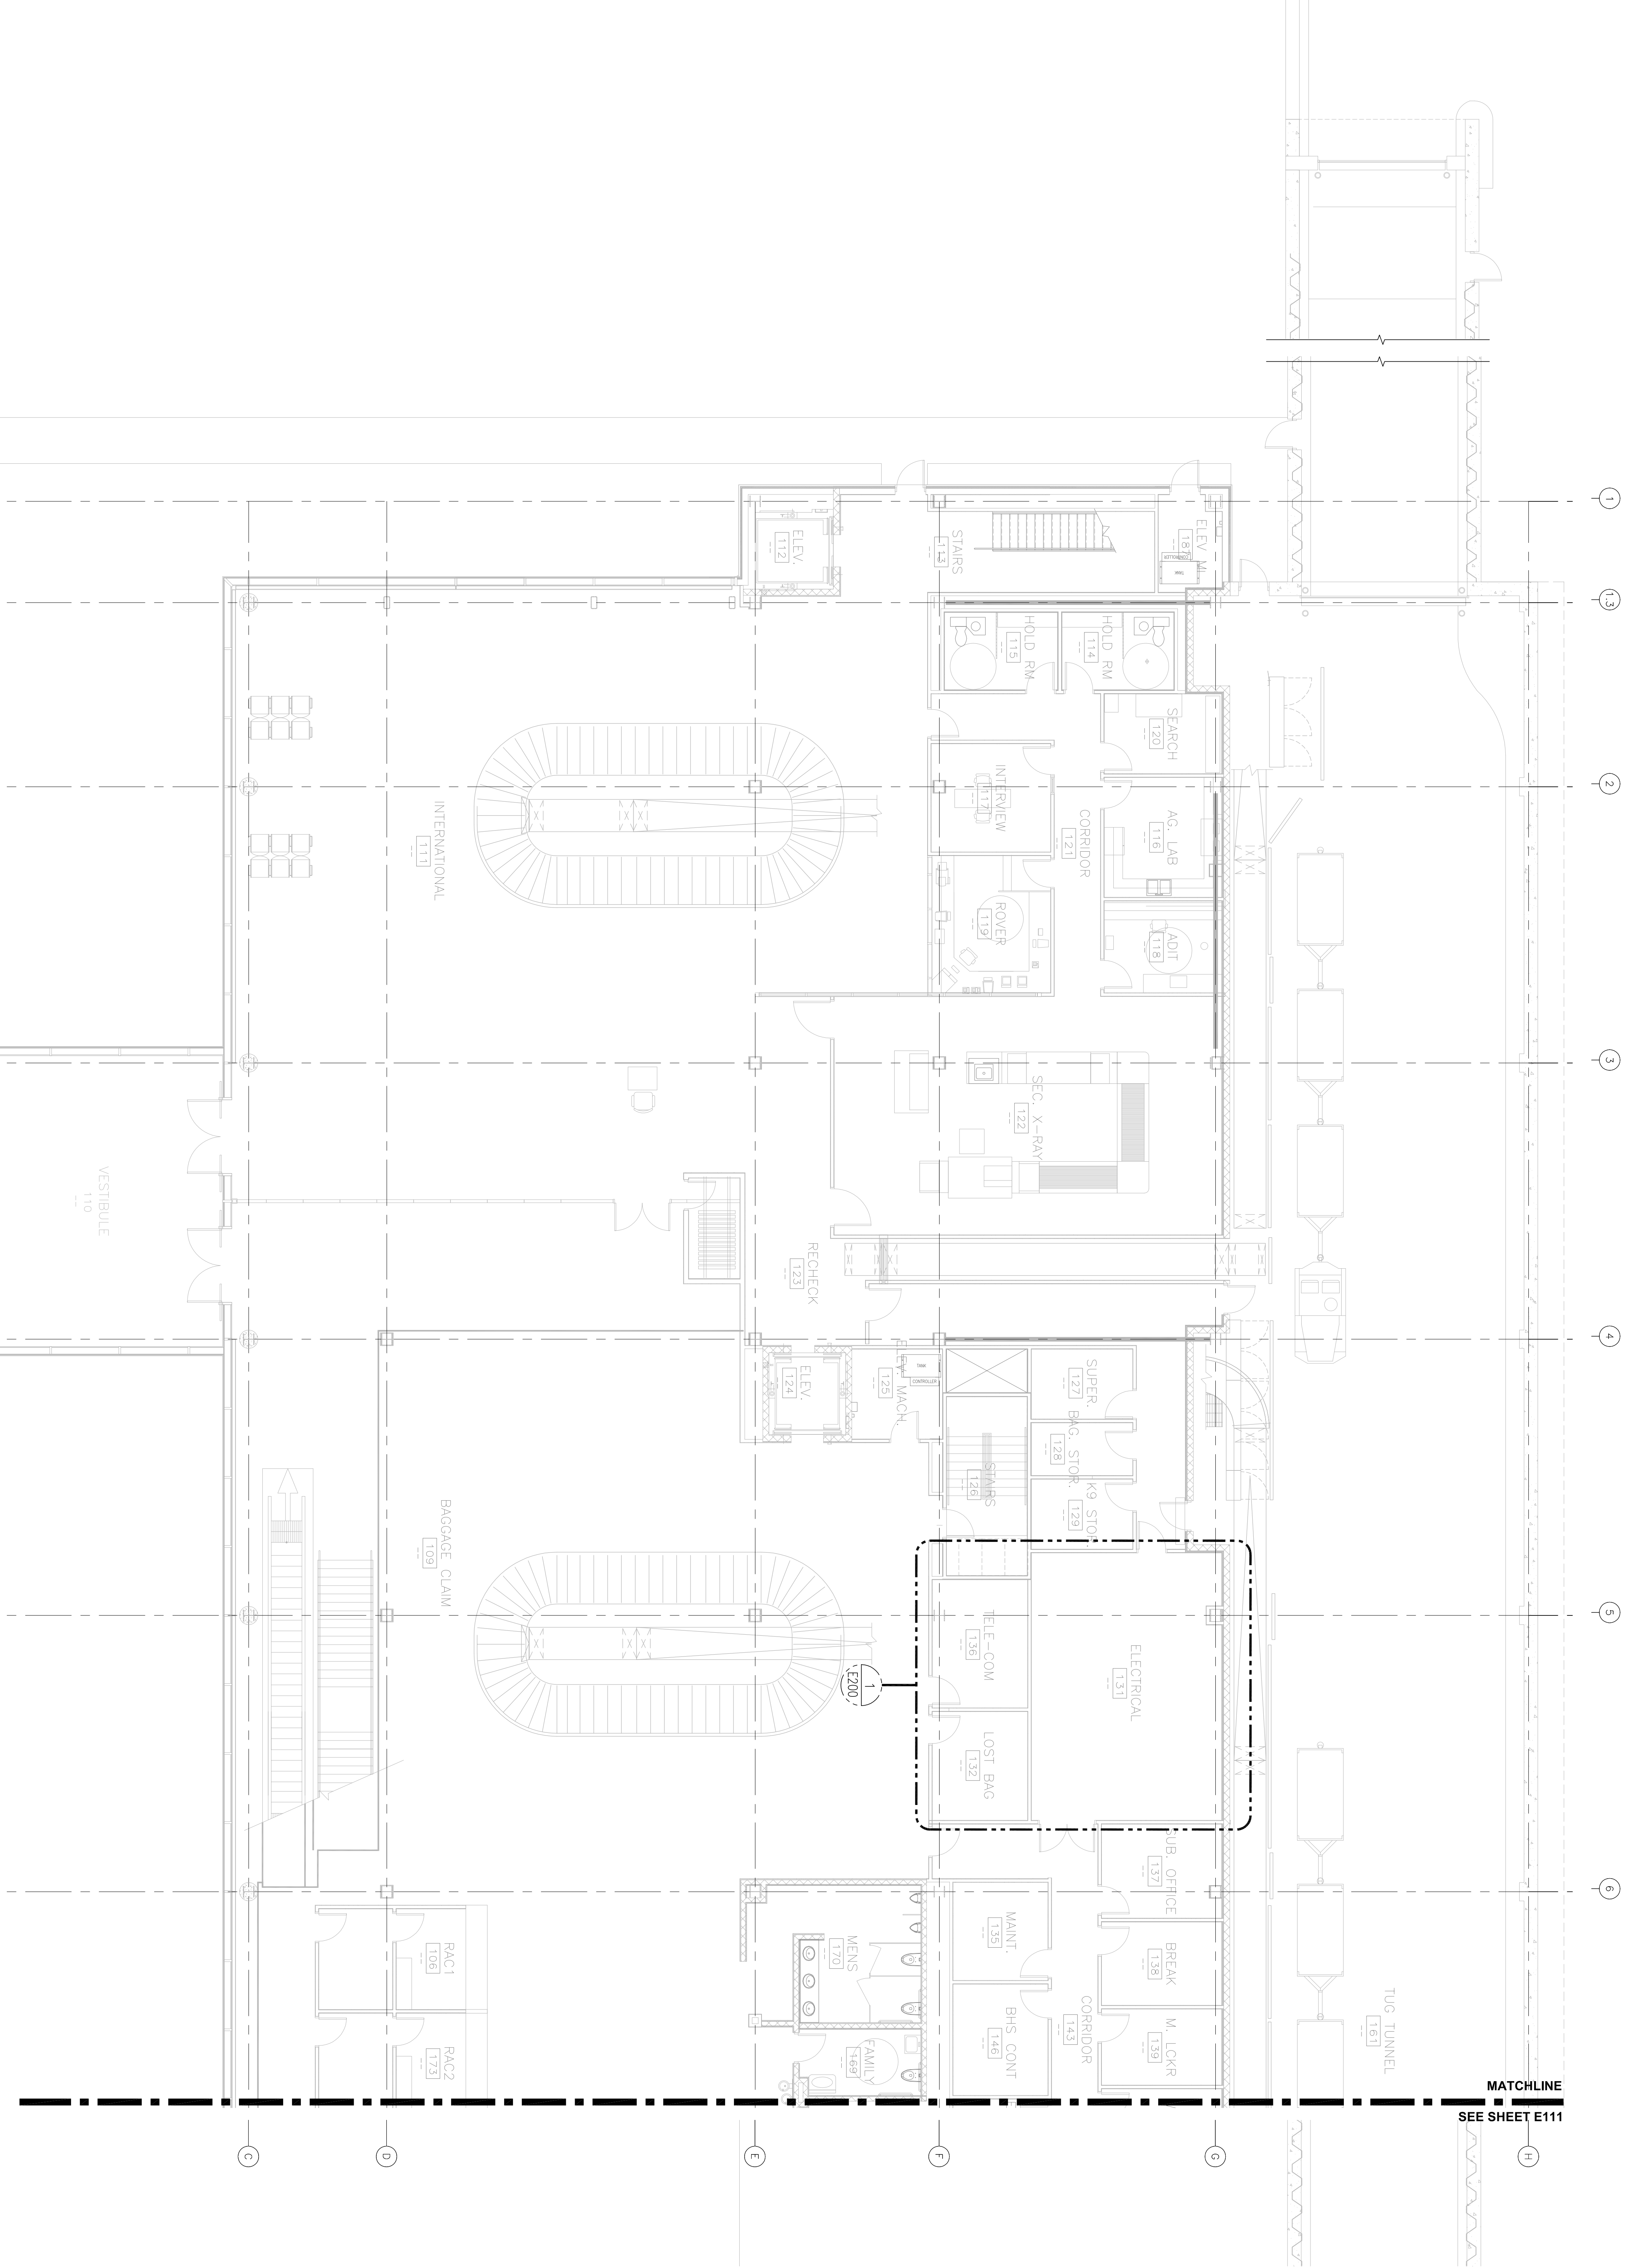

1 ENLARGED FIRST LEVEL FLOOR PLAN - AREA A
1/8" = 1'-0"