


FA GENERAL NOTES:


1. OPENINGS FOR DUCT SMOKE DETECTORS ARE PROVIDED BY OTHERS.
2. RESER OPENING SHALL BE IN 2-HOUR RATED ENCLOSURE PROVIDED BY GENERAL CONTRACTOR.
3. FOR CLAUTY, DUTS ARE GENERALLY NOT SHOWN. REFER TO SPECIFICATIONS FOR REQUIREMENTS.
4. ALL PLACES OF ASSEMBLY, PUBLIC CORRIDORS, PUBLIC STORAGE ROOMS, ETC. SHALL BE PROVIDED WITH ALARM INDICATING DEVICES PER ADA, UL AND LOCAL AUTHORITY.

- FA KEYED NOTES**
- ① CONNECT TO SINGLE POLE, 20A CIRCUIT BREAKER.
 - ② SMOKE DETECTORS IN ELEVATOR MACHINE ROOM SHALL BE CROSS-ZONED.
 - ③ QUANTITY OF DTU DEVICES TO BE VERIFIED WITH EQUIPMENT MANUFACTURER. TYPICAL FOR ALL DTU DEVICES SHOWN.

THE SUCCESSFUL MANUFACTURER
SHALL SUBMIT DETAILED SHOP
DRAWINGS AND SPECIFICATIONS
FOR APPROVAL TO THE LOCAL
FIRE PREVENTION BUREAU

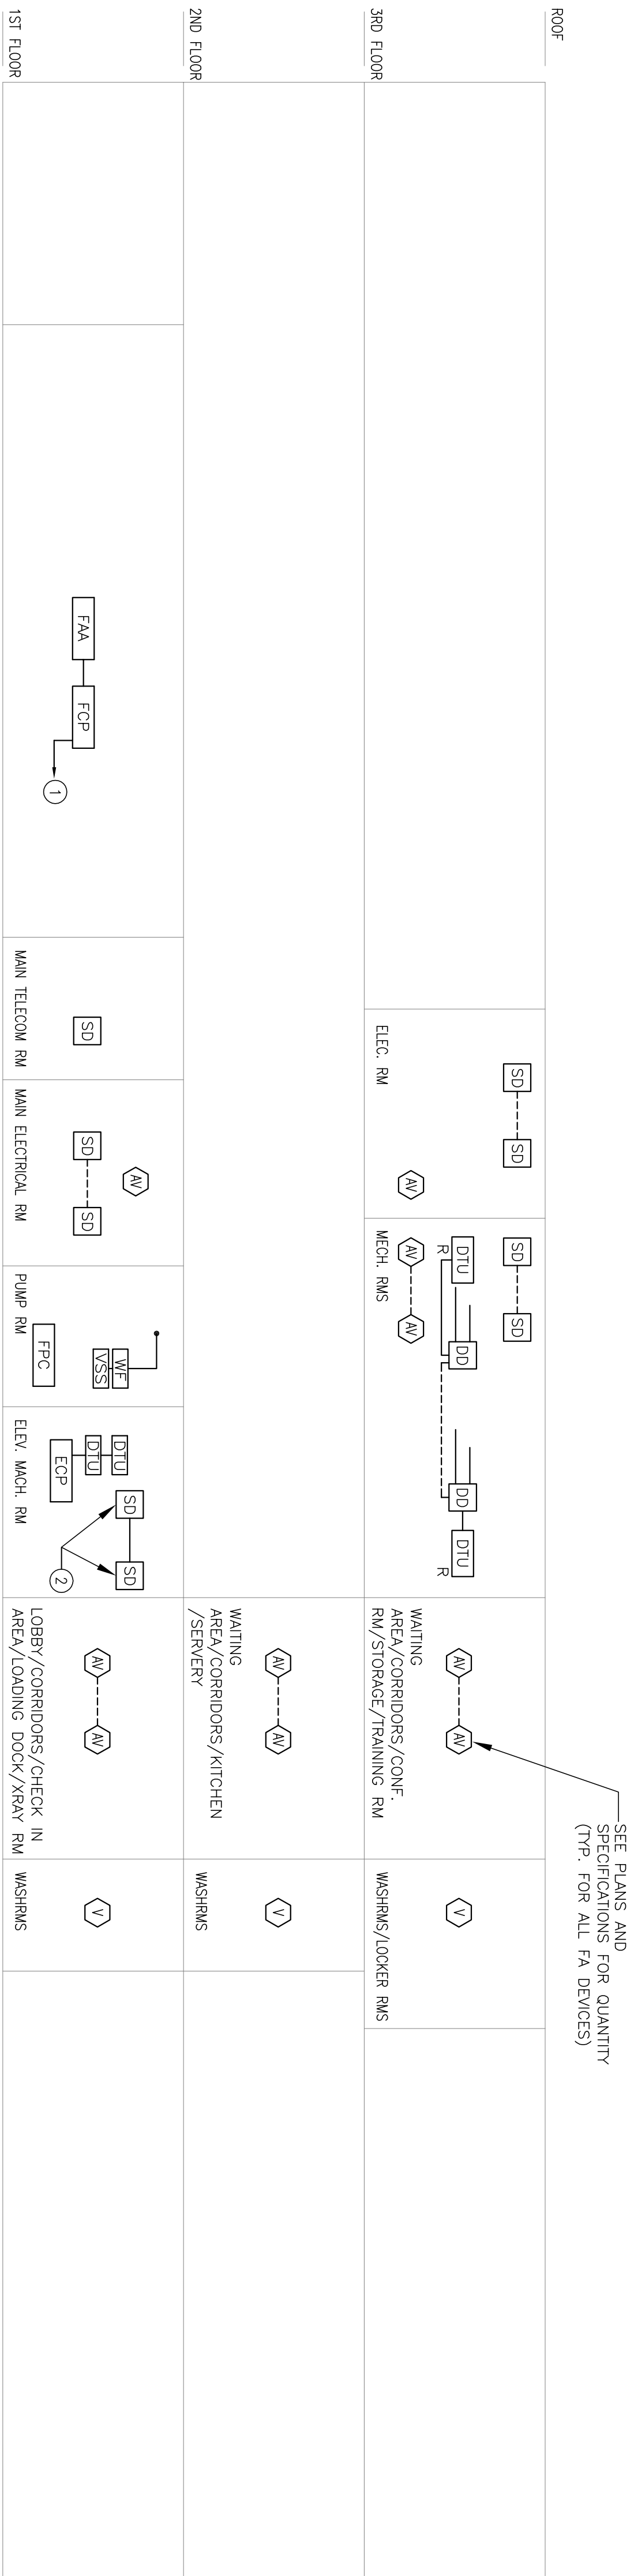

FIRE ALARM DIAGRAM

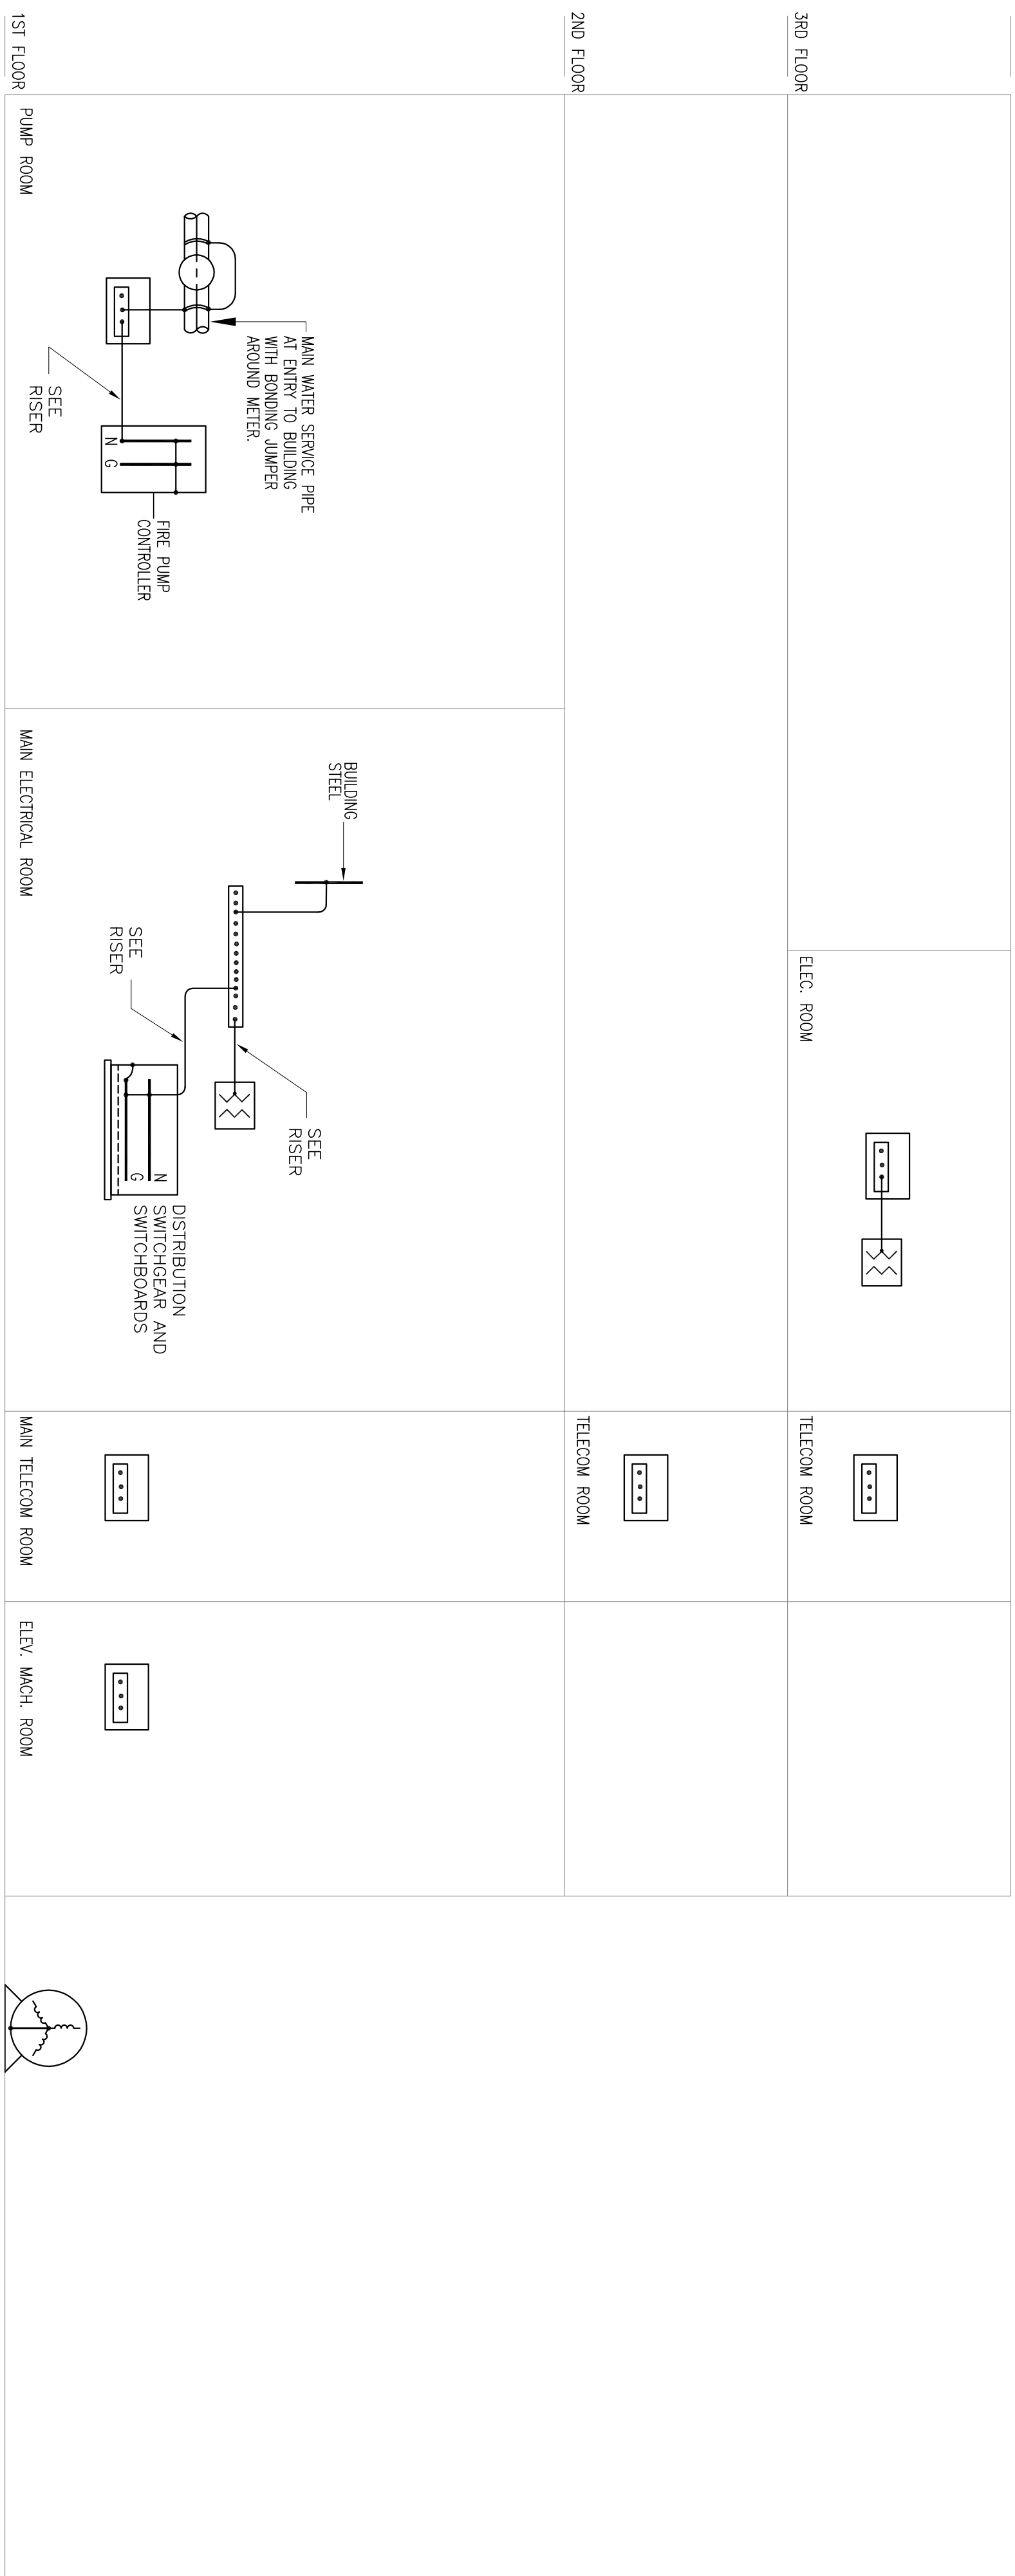

GROUNDING RISER DIAGRAM

RS&H
IMPROVING YOUR WORLD

Reynolds, Smith and Hills, Inc.
4525 Airport Approach Rd., Ste A
Duluth, Minnesota 55811
218-722-1227 Fax: 218-722-1052
www.rsandh.com



DULUTH AIRPORT
AUTHORITY

DULUTH
INTERNATIONAL
AIRPORT
DULUTH, MN

NEW TERMINAL
DESIGN

CONSULTANTS

SJA ARCHITECTS

11 E Superior Street Suite 340, Duluth MN 55802
TEL: (218) 724-8578 / FAX: (218) 724-8717
www.stanfusjohnson.com

MBJ CONSULTING ENG.
501 Lake Avenue South, Suite 300, Duluth MN 55802
TEL: (218) 722-1056 / FAX: (218) 722-9306
www.mbjeng.com

BNP ASSOCIATES INC.
101 East Ridge Office Park, Suite 103, Danbury CT 06810
TEL: (203) 792-3000 / FAX: (203) 792-4900
www.bnpassociates.com

COSENTINI
1 East Wacker Drive, Suite 103, Chicago IL 60601
TEL: (312) 670-1800 / FAX: (312) 670-1801
www.cosentini.com

APPOLD DESIGN
2432 East First Street, Duluth MN 55812
TEL: (218) 591-5079
www.appoldesign.com

KRAUS-ANDERSON
3716 Oneota Street, Duluth MN 55807
TEL: (218) 722-3775
www.krausanderson.com

LIGHTING
XXXXXXXXXX
TEL: (XXX) XXX-XXXX
WWW.XXXXXXXX.COM

[illegible]

DATE ISSUED:	10-30-09
REVIEWED BY:	XXX
DRAWN BY:	JK
DESIGNED BY:	JK

AEP PROJECT NUMBER
213-1882-091
© 2006 RENOLDS, SMITH AND HILLS INC.

SHEET TITLE

**FIRE ALARM AND
GROUNDING RISER
DIAGRAMS**

SHEET NUMBER
E301

30% NOT FOR CONSTRUCTION