



## CONSULTANTS

**SJA ARCHITECTS**

E Superior Street Suite 340, Duluth MN 55802  
TEL: (218) 724-8578 / FAX: (218) 724-8717  
[www.stanleyjohnson.com](http://www.stanleyjohnson.com)

**BJ CONSULTING ENG.**

lake Avenue South, Suite 300, Duluth MN 55802  
TEL: (216) 722-1066 / FAX: (216) 722-8306  
[www.mibjeng.com](http://www.mibjeng.com)

**INP ASSOCIATES INC.**

4 Ridge Office Park, Suite 103, Danbury CT 06810  
TEL: (203) 782-3000 / FAX: (203) 782-4800  
[www.bmgassocdata.com](http://www.bmgassocdata.com)

**COSENTINI**

East Wacker Drive, Suite 103, Chicago IL 60601  
TEL: (312) 670-1800 / FAX: (312) 670-1801  
[www.ccsentrl.com](http://www.ccsentrl.com)

**APPOLD DESIGN**

**2432 East First Street, Duluth MN 55812**  
**TEL: (218) 591-6079**  
**[www.applodeeign.com](http://www.applodeeign.com)**

**KRAUS-ANDERSON**

3716 Onocota Street, Duluth MN 55807  
TEL: (218) 722-3776  
[www.ktrausanderson.com](http://www.ktrausanderson.com)

## LIGHTING

**XXXXXXXXXX**  
**TEL: (000) XXX-XXXX**  
**WWW.XXXXXXXXXX.COM**

| REVISIONS |             |      |
|-----------|-------------|------|
| NO.       | DESCRIPTION | DATE |

DATE ISSUED: 10-30-09

REVIEWED BY: XXX

DRAWN BY: HV

DESIGNED BY: SA

AEP PROJECT NUMBER  
213-1882-091

© 2006 REYNOLDS, SMITH AND HILLS INC.

SHEET TITLE

# ENLARGED

ENLARGED  
ELECT EL 00B

## FIRST FLOOR

## FIRE PROTECTION

PLAN AREA B

---

---

SHEET NUMBER

四

---

\_\_\_\_\_

---


NOT FOR

30% NOI FOR

CONSTRUCTION

Printed on 12/2/2008 4:03 PM Printed by Henry Williams

**1** ENLARGED FIRST LEVEL FLOOR PLAN - AREA B  
1/8" = 1'-0"

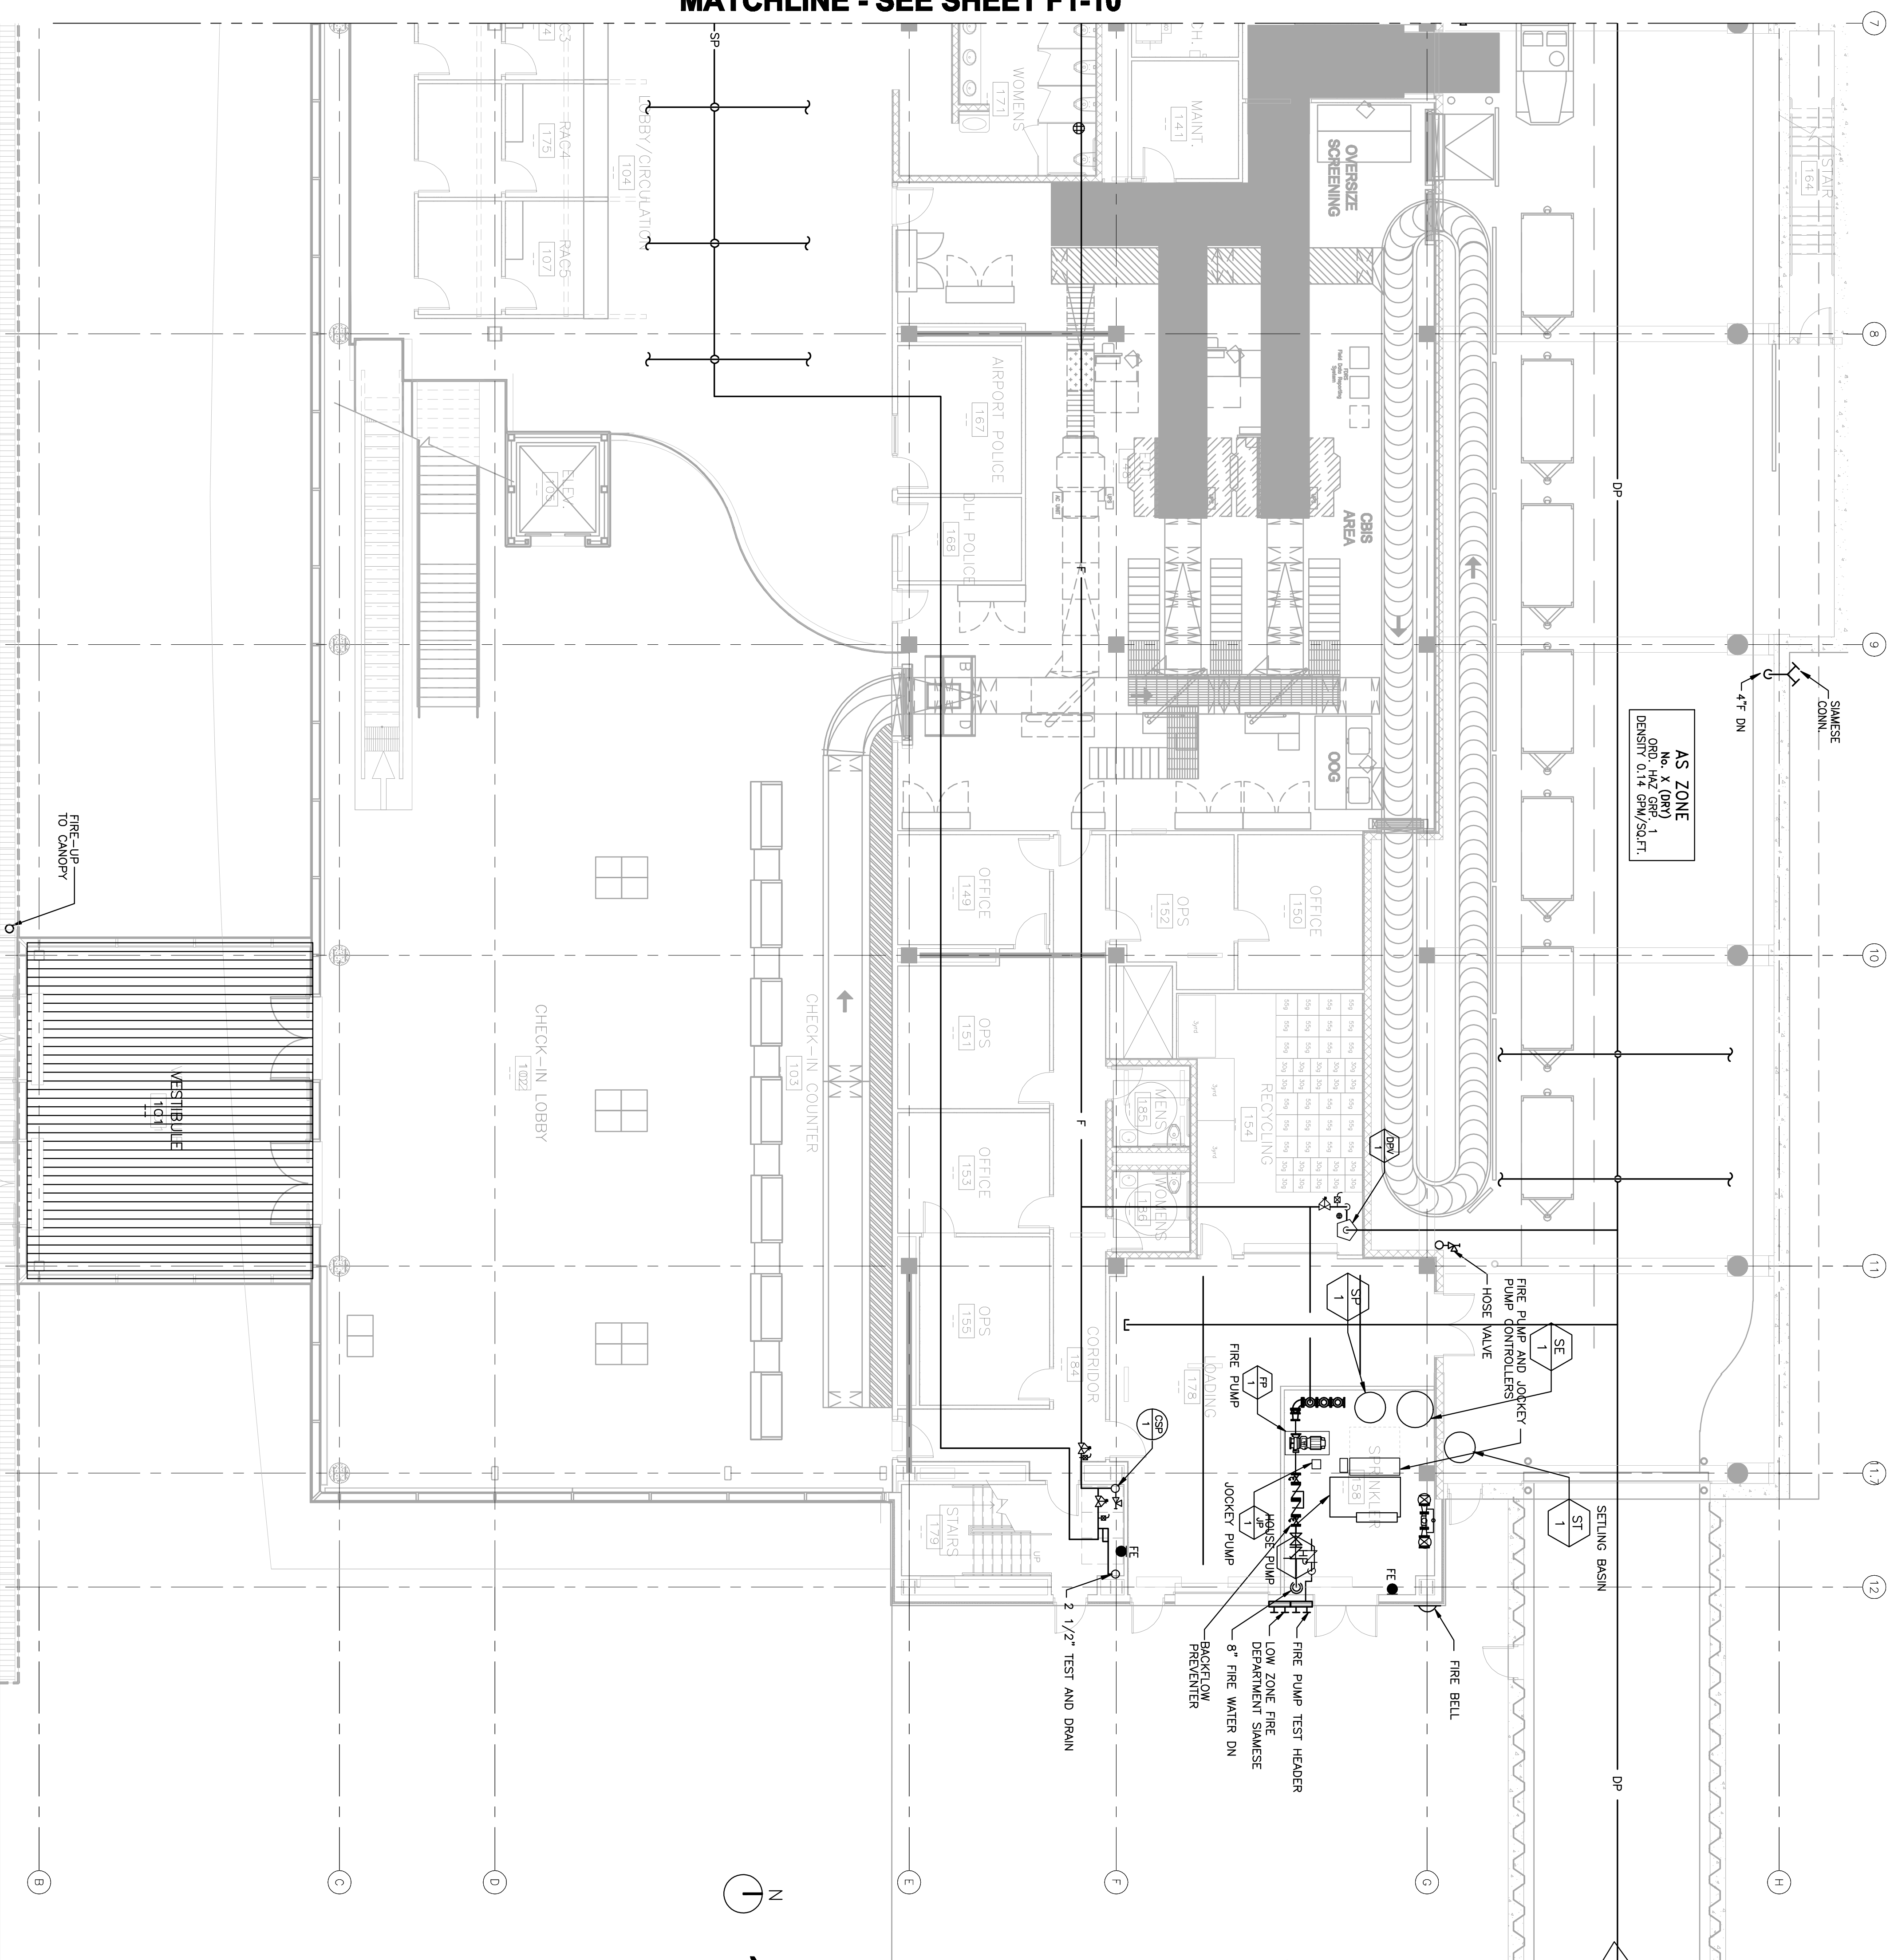

SCALE: 1/5 - 100

Downloaded by: 192.168.1.100 (192.168.1.100) Pro Protection/Debug/2020\_11/14mg Printed on 12/2/2020 4:45 PM Printed by: Henry Wilson