

| NO. | DESCRIPTION | DATE |
|-----|-------------|------|
|     |             |      |
|     |             |      |
|     |             |      |
|     |             |      |
|     |             |      |
|     |             |      |
|     |             |      |


|                       |
|-----------------------|
| DATE ISSUED: 10-30-09 |
| REVIEWED BY: XXX      |
| DRAWN BY: HV          |
| DESIGNED BY: SA       |

|                                       |
|---------------------------------------|
| AEP PROJECT NUMBER<br>213-1882-091    |
| © 2008 REYNOLDS, SMITH AND HILLS INC. |

|                                                            |
|------------------------------------------------------------|
| ENLARGED<br>SECOND FLOOR<br>FIRE PROTECTION<br>PLAN AREA A |
|------------------------------------------------------------|

|                       |
|-----------------------|
| SHEET NUMBER<br>F1-12 |
|-----------------------|

|                             |
|-----------------------------|
| 30% NOT FOR<br>CONSTRUCTION |
|-----------------------------|

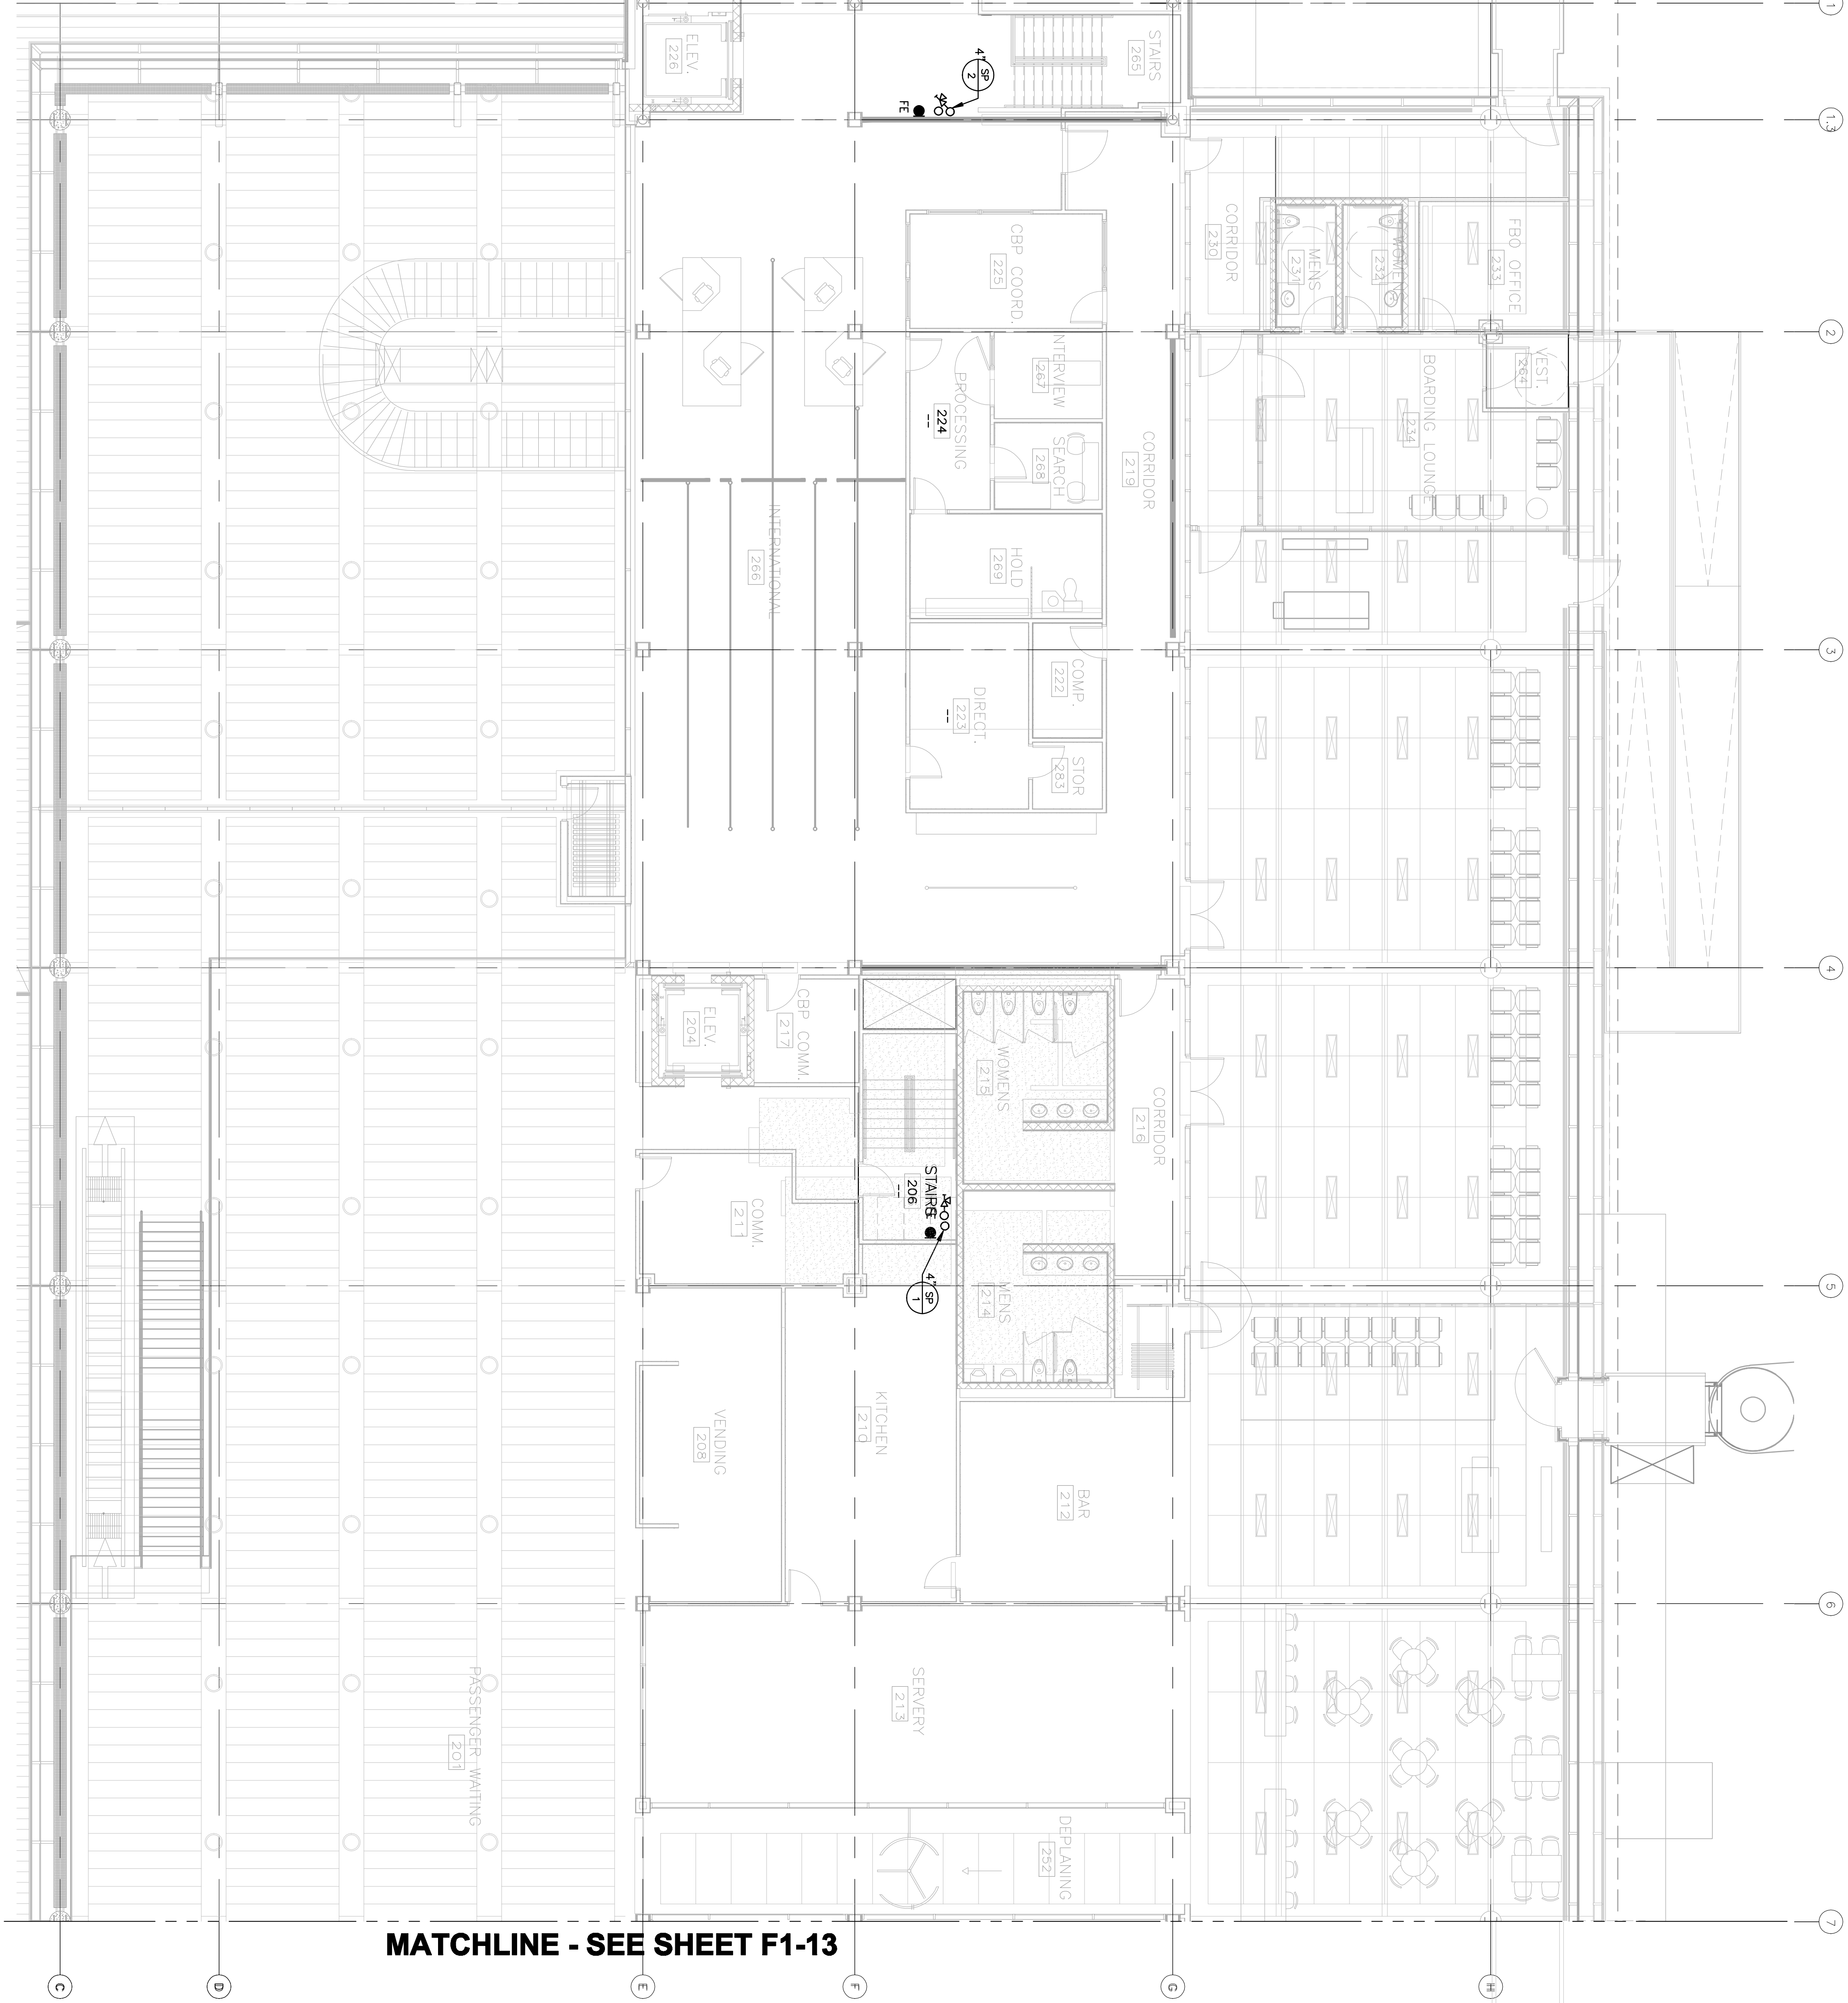

MATCHLINE - SEE SHEET F1-13

1  
1/8" = 1'-0"  
ENLARGED SECOND LEVEL FLOOR PLAN - AREA A