

Reynolds, Smith and Hills, Inc

218-722-1227 Fax: 218-722-1052

www.rsandh.com

**DULUTH AIRPORT
AUTHORITY**

DULUTH, MN

DESIGN

CONSULTANTS

SJA ARCHITECTS

www.startingjohnson.com

www.stanleyjohnson.com

CONSULTING

www.rmbjeng.com

www.rmbj.org.com

IP ASSOCIATES

www.bnpsocietas.com

www.bnpasocietas.com

COSENTINI

www.cosentini.com

www.cosentini.com

APPOLO DESIGN

www.applieddesign.com

www.applieddesign.com

RAUS-ANDERSON

www.krausanderson.com

www.krausanderson.com

LIGHTING

www.xxxxxxx.com

www.xxxxxxx.com

[illegible]

DATE ISSUED: 10-30-09

REVIEWED BY: XXXX

DRAWN BY: HV

DESIGNED BY: SA

AEP PROJECT NUMBER

213-1882-091

© 2006 REYNOLDS, SMITH AND HILLS INC

SHEET TITLE


SHEET TITLE

RISE R DIAGRAM

SHEET NUMBER

FS-01

CONSTRUCTION

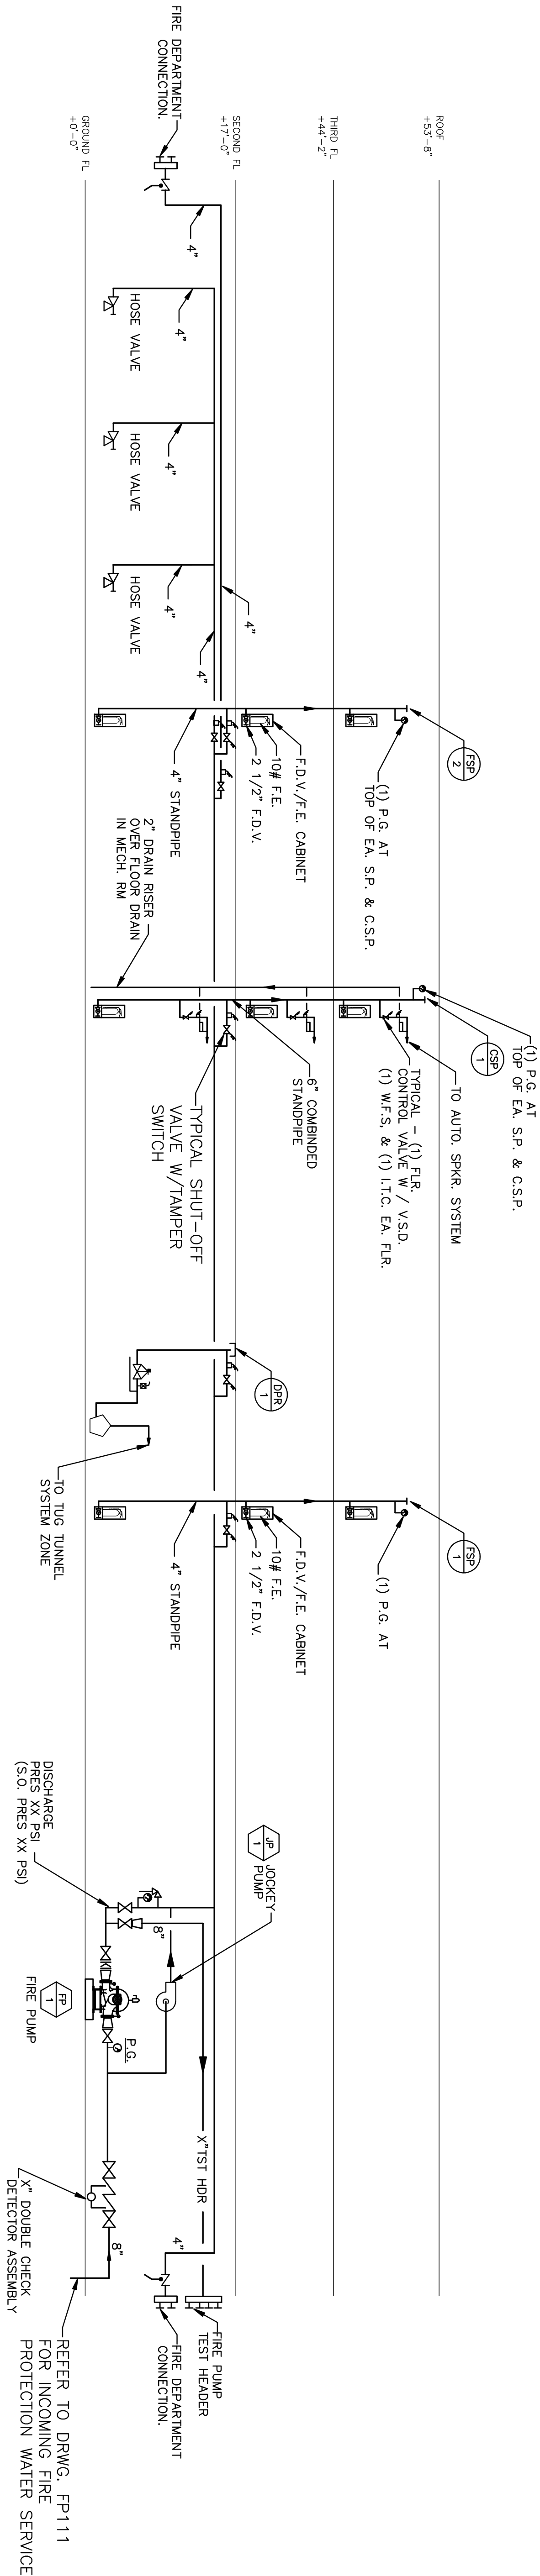

PUMP SCHEDULE										
PUMP TAG	SERVICE	LOCATION	GPM EACH PUMP	TOTAL DYNAMIC HEAD	SHUT OFF HEAD	MOTOR DATA			MANUFACTURER	REMARKS
						HP	VOLTS	PH RPM		
FP-1	FIRE PUMP	GROUND FLOOR				480				
JP-1	JOCKY PUMP	GROUND FLOOR				480				