



DULUTH
INTERNATIONAL
AIRPORT
DULUTH, MN

NEW TERMINAL
DESIGN

CONSULTANTS

SJA ARCHITECTS
11 E Superior Street Suite 340, Duluth MN 55802
TEL: (218) 724-8578 / FAX: (218) 724-8717
www.sjaarchitects.com

MBJ CONSULTING ENG.
501 Lake Avenue South, Suite 300, Duluth MN 55802
TEL: (218) 722-1055 / FAX: (218) 722-8508
www.mbjeng.com

BNP ASSOCIATES INC.
101 East Ridge Office Park, Suite 103, Duluth, CT 06010
TEL: (203) 792-3000 / FAX: (203) 792-4900
www.bnpsocieties.com

COSENTINI
1 East Wacker Drive, Suite 103, Chicago IL 60601
TEL: (312) 670-1801 / FAX: (312) 670-1801
www.cosentini.com

APPOLD DESIGN
2482 East First Street, Duluth MN 55812
TEL: (218) 581-5019
www.appolddesign.com

KRAUS-ANDERSON
3718 Oriskany Street, Duluth MN 55807
TEL: (218) 722-3775
www.krausanderson.com

LIGHTING
XXXXXXXXXX
TEL: (XXX) XXX-XXXX
www.XXXXXXX.com


REVISIONS	
NO.	DESCRIPTION

DATE ISSUED: 10-30-09
REVIEWED BY: MXB
DRAWN BY: MB/H
DESIGNED BY: MXB
AEP PROJECT NUMBER
213-1882-091
SHEET TITLE
ENLARGED THIRD FLOOR MECHANICAL PLAN AREA A

© 2006 REYNOLDS, SMITH AND HILLS INC.

SHEET NUMBER
M114

30% NOT FOR
CONSTRUCTION

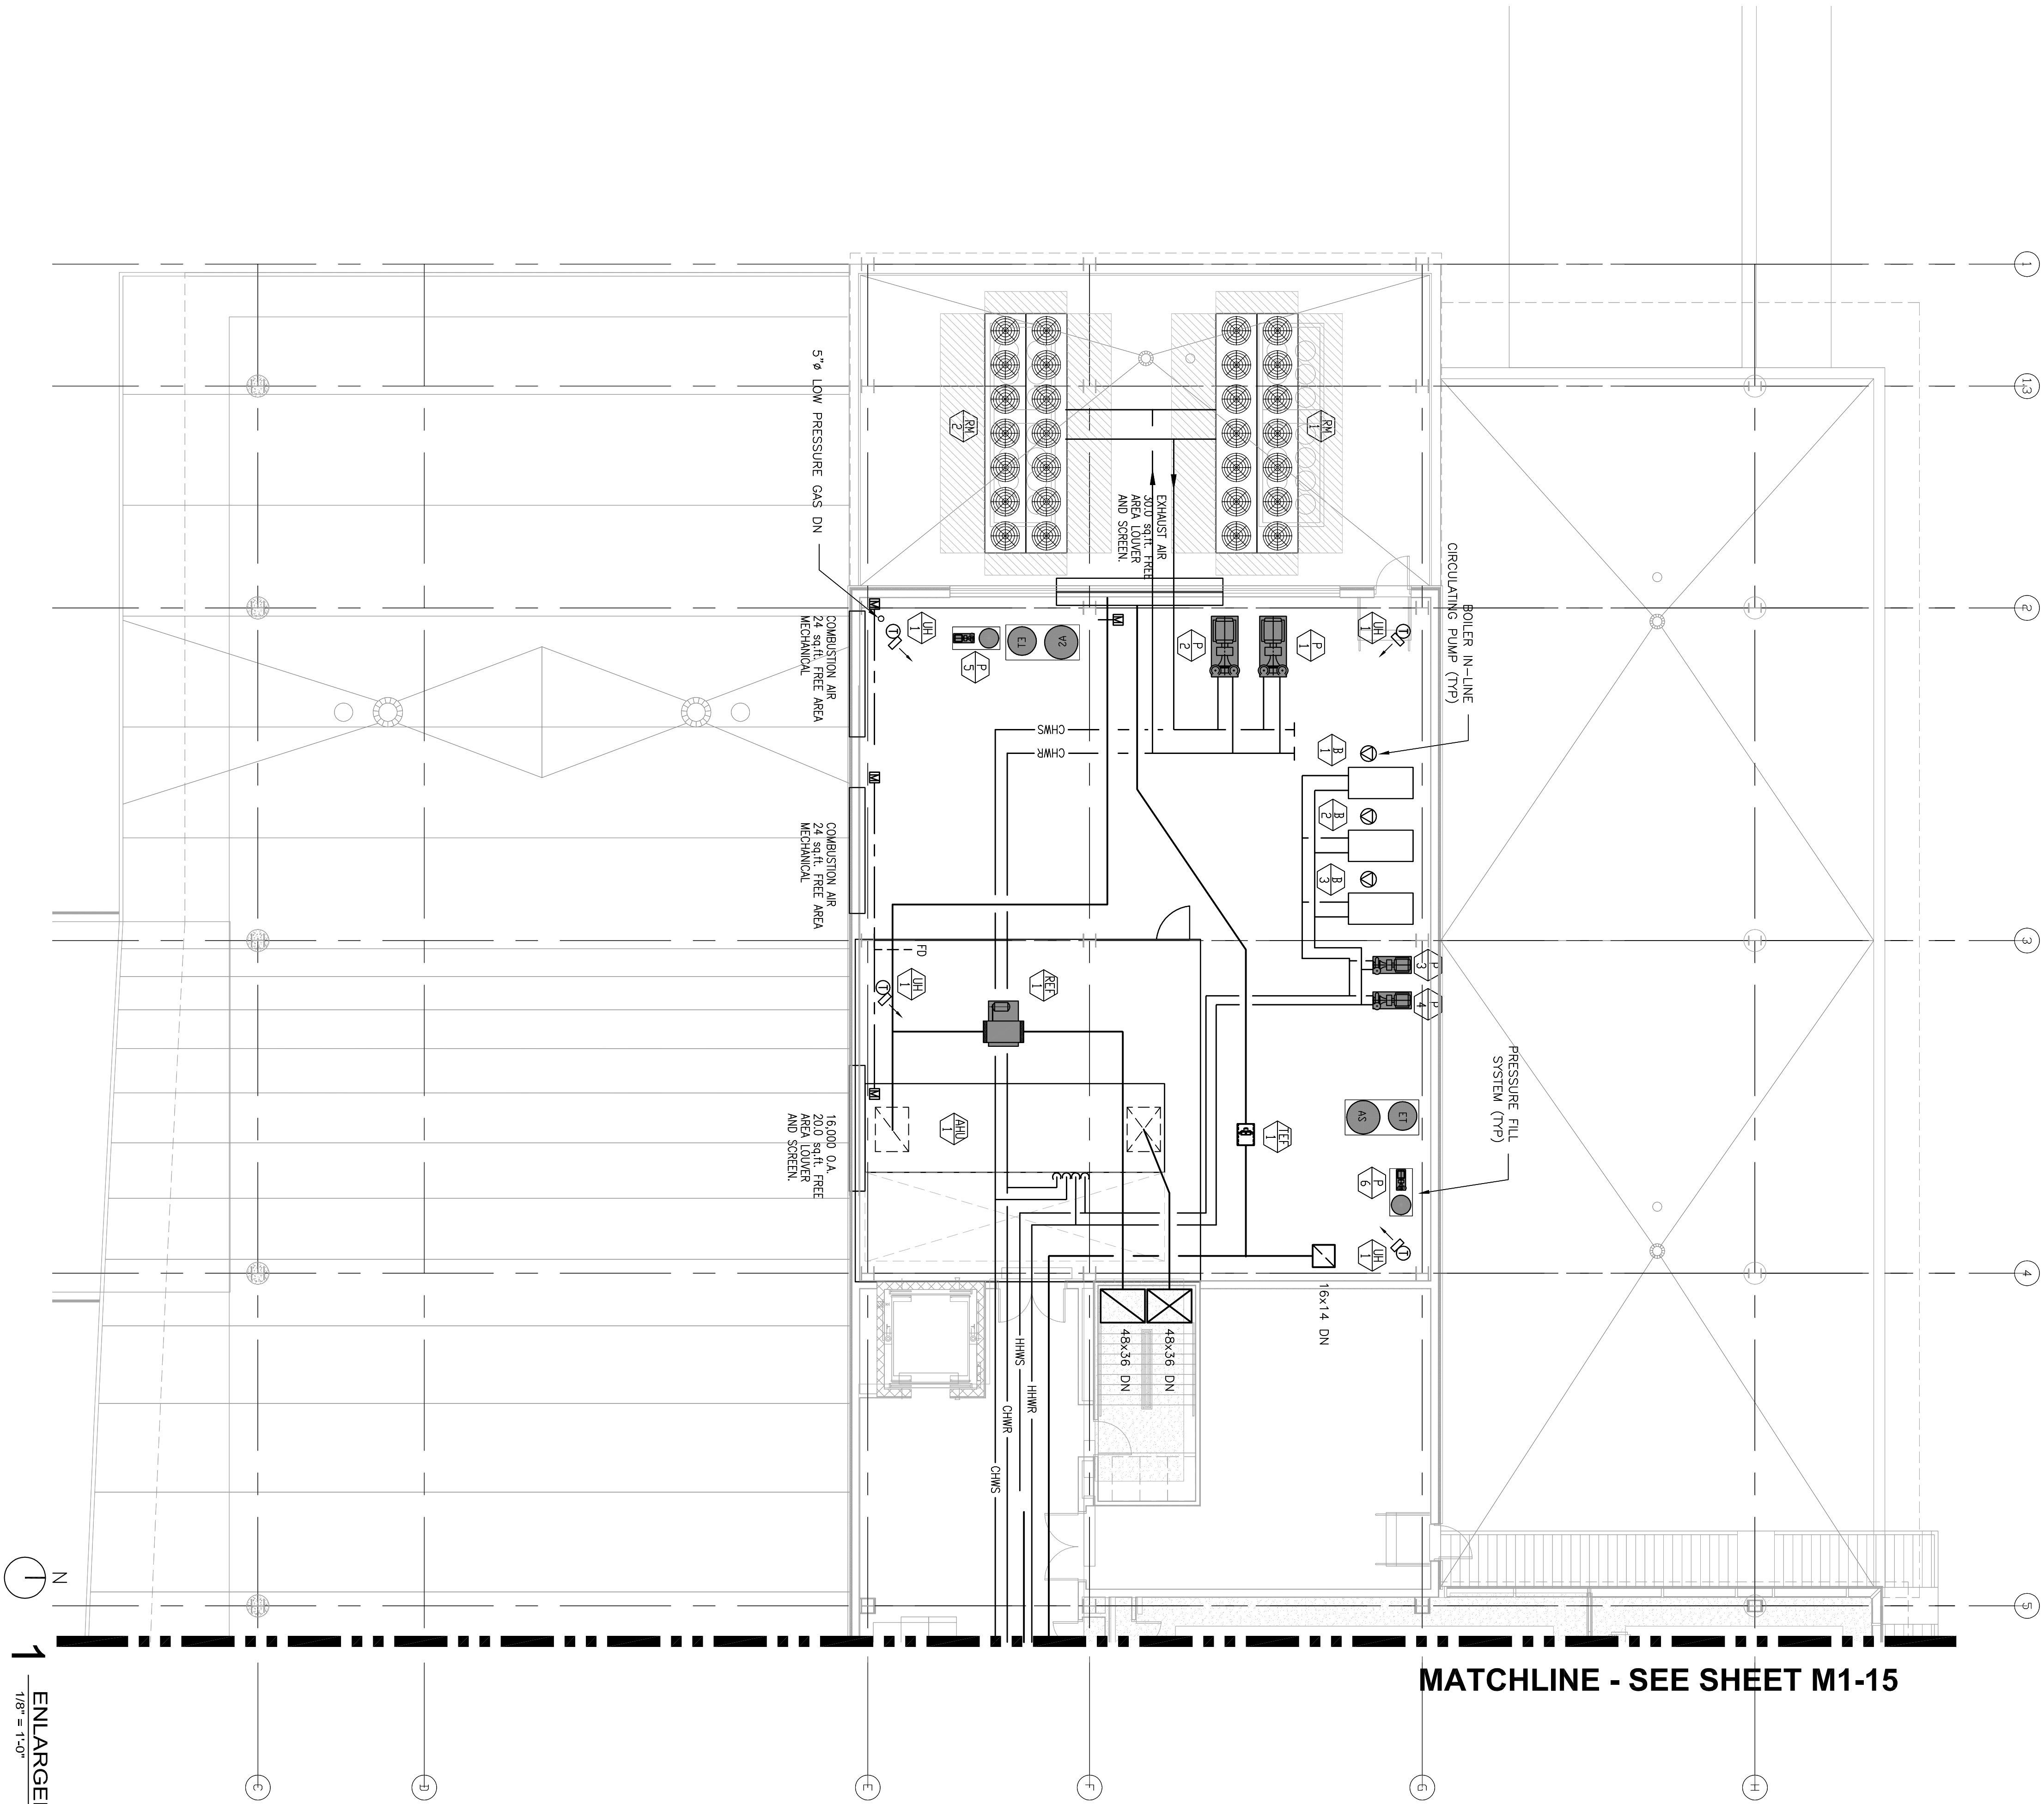

ENLARGED THIRD LEVEL FLOOR PLAN - ADMIN.
1/8" = 1'-0"