


MATCHLINE - SEE SHEET M1-14

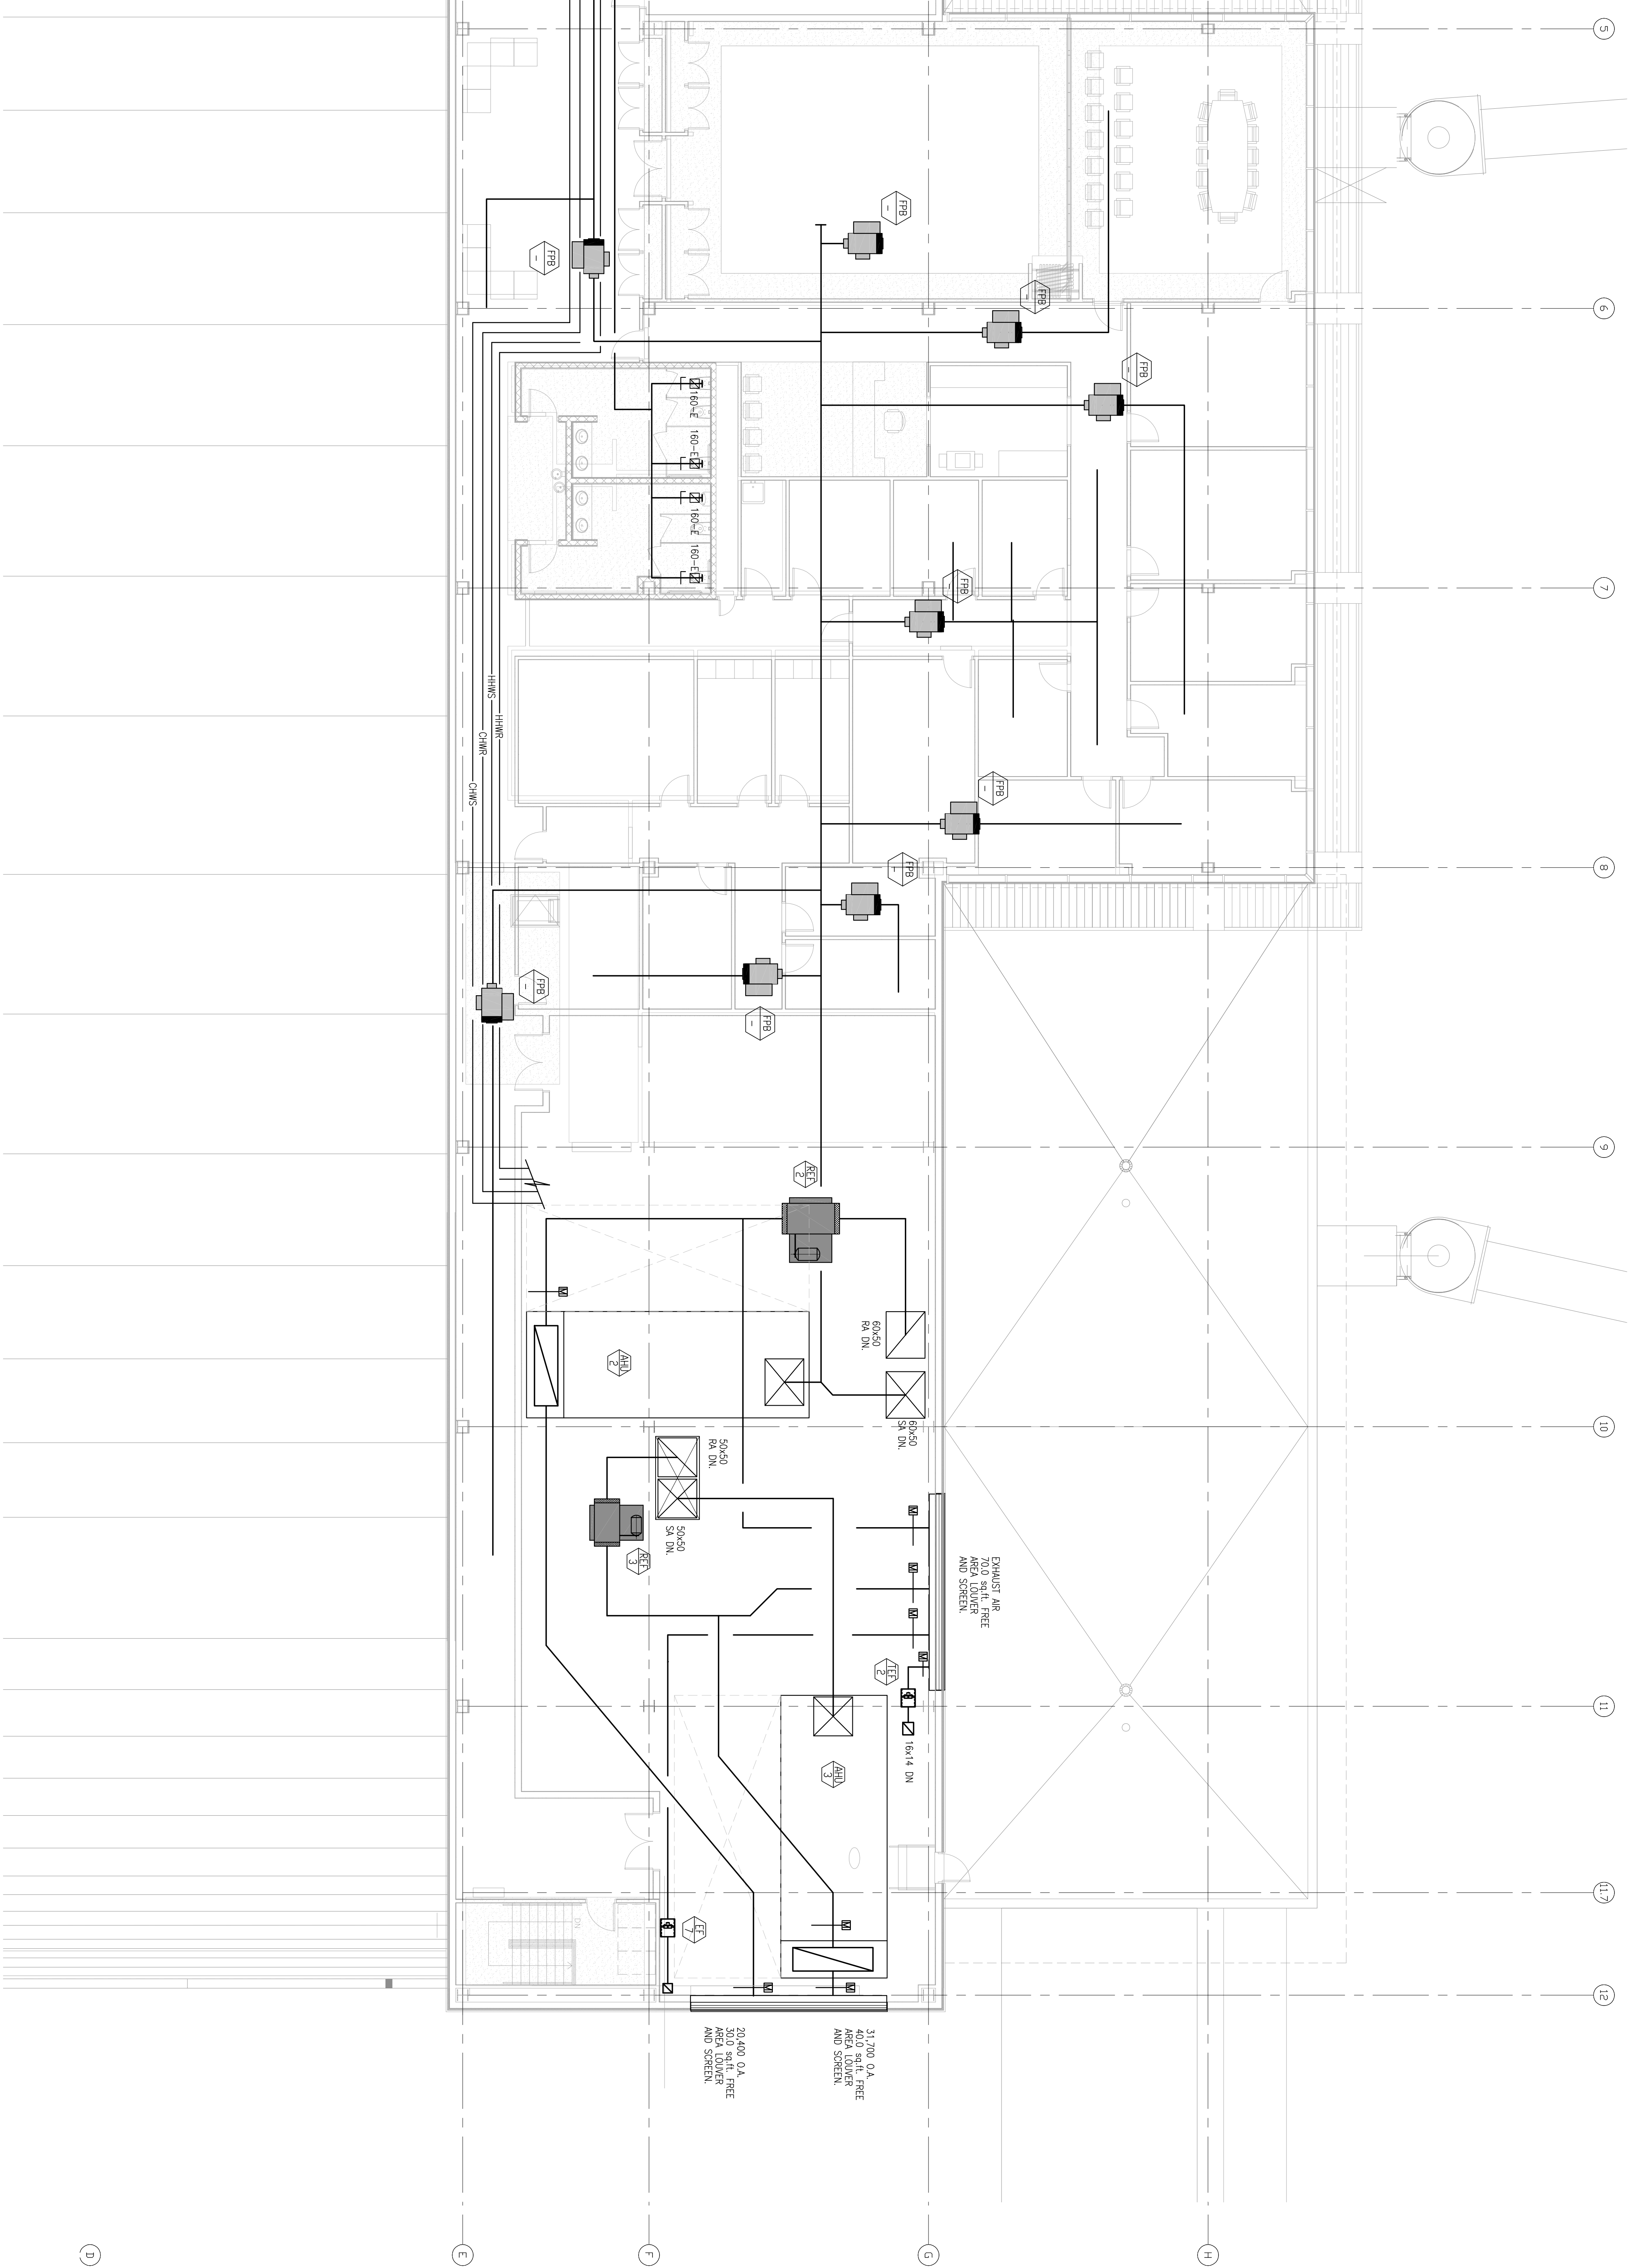

1 ENLARGED THIRD LEVEL MECHANICAL PLAN - AREA B
1/8" = 1'-0"

RS&H
IMPROVING YOUR WORLD

Reynolds, Smith and Hills, Inc.
4525 Airport Approach Rd, Ste A
Duluth, Minnesota 55811
218-722-1227 Fax: 218-722-1052
www.rsandh.com



DULUTH
INTERNATIONAL
AIRPORT
DULUTH, MN

NEW TERMINAL
DESIGN

CONSULTANTS

SJA ARCHITECTS
11 E Superior Street Suite 340, Duluth MN 55802
TEL: (218) 724-8578 / FAX: (218) 724-8717
www.sjaarchitects.com

MBJ CONSULTING ENG.
501 Lake Avenue South, Suite 300, Duluth MN 55802
TEL: (218) 722-1025 / FAX: (218) 722-8508
www.mbjeng.com

BNP ASSOCIATES INC.
101 East Ridge Office Park, Suite 103, Duluth, CT 06010
TEL: (203) 792-3000 / FAX: (203) 792-4000
www.bnpsocieties.com

COSENTINI
1 East Wacker Drive, Suite 103, Chicago IL 60601
TEL: (312) 670-1800 / FAX: (312) 670-1801
www.coesentini.com

APPOLD DESIGN
2402 East First Street, Duluth MN 55812
TEL: (218) 581-5019
www.appolddesign.com

KRAUS-ANDERSON
3710 Orinwood Street, Duluth MN 55807
TEL: (218) 722-3778
www.krausanderson.com

LIGHTING
XXXXXXXXXX
TEL: (XXX) XXX-XXXX
www.XXXXXXX.com

REVISIONS		
NO.	DESCRIPTION	DATE

DATE ISSUED: 10-30-09
REVIEWED BY: MXB
DRAWN BY: MBUEH
DESIGNED BY: MXB
AEP PROJECT NUMBER
213-1862-091
© 2009 REYNOLDS, SMITH AND HILLS INC.

SHEET TITLE
ENLARGED
THIRD FLOOR
MECHANICAL PLAN
AREA B

SHEET NUMBER
M115

30% NOT FOR
CONSTRUCTION