



DULUTH
INTERNATIONAL
AIRPORT
DULUTH, MN

NEW TERMINAL
DESIGN

CONSULTANTS

SJA ARCHITECTS
11 E Superior Street Suite 340, Duluth MN 55802
TEL: (218) 724-8578 / FAX: (218) 724-8717
www.sjanhughson.com

MBJ CONSULTING ENG.
501 Lake Avenue South, Suite 300, Duluth MN 55802
TEL: (218) 722-1025 / FAX: (218) 722-8508
www.mbjeng.com

BNP ASSOCIATES INC.
101 East Ridge Office Park, Suite 103, Duluth, CT 06010
TEL: (203) 793-3000 / FAX: (203) 792-4800
www.bnassociates.com

COSENTINI
1 East Wacker Drive, Suite 103, Chicago IL 60601
TEL: (312) 670-1800 / FAX: (312) 670-1801
www.cosenitnli.com

APPOLD DESIGN
2482 East First Street, Duluth MN 55812
TEL: (218) 581-5079
www.appolddesign.com

KRAUS-ANDERSON
3718 Orange Street, Duluth MN 55807
TEL: (218) 722-3775
www.krausanderson.com

LIGHTING
XXXXXXXXXX
TEL: (XXX) XXX-XXXX
www.XXXXXXX.com

REVISIONS		
NO.	DESCRIPTION	DATE


DATE ISSUED: 10-30-09
REVIEWED BY: MXB
DRAWN BY: XX
DESIGNED BY: XX
AEP PROJECT NUMBER
218-1882-1001
5523 4115 1200p
©2009 REYNOLDS, SMITH AND HILLS INC.

SHEET TITLE

ENLARGED
MECHANICAL ROOF
PLAN AREA-A

SHEET NUMBER
M116

30% NOT FOR
CONSTRUCTION

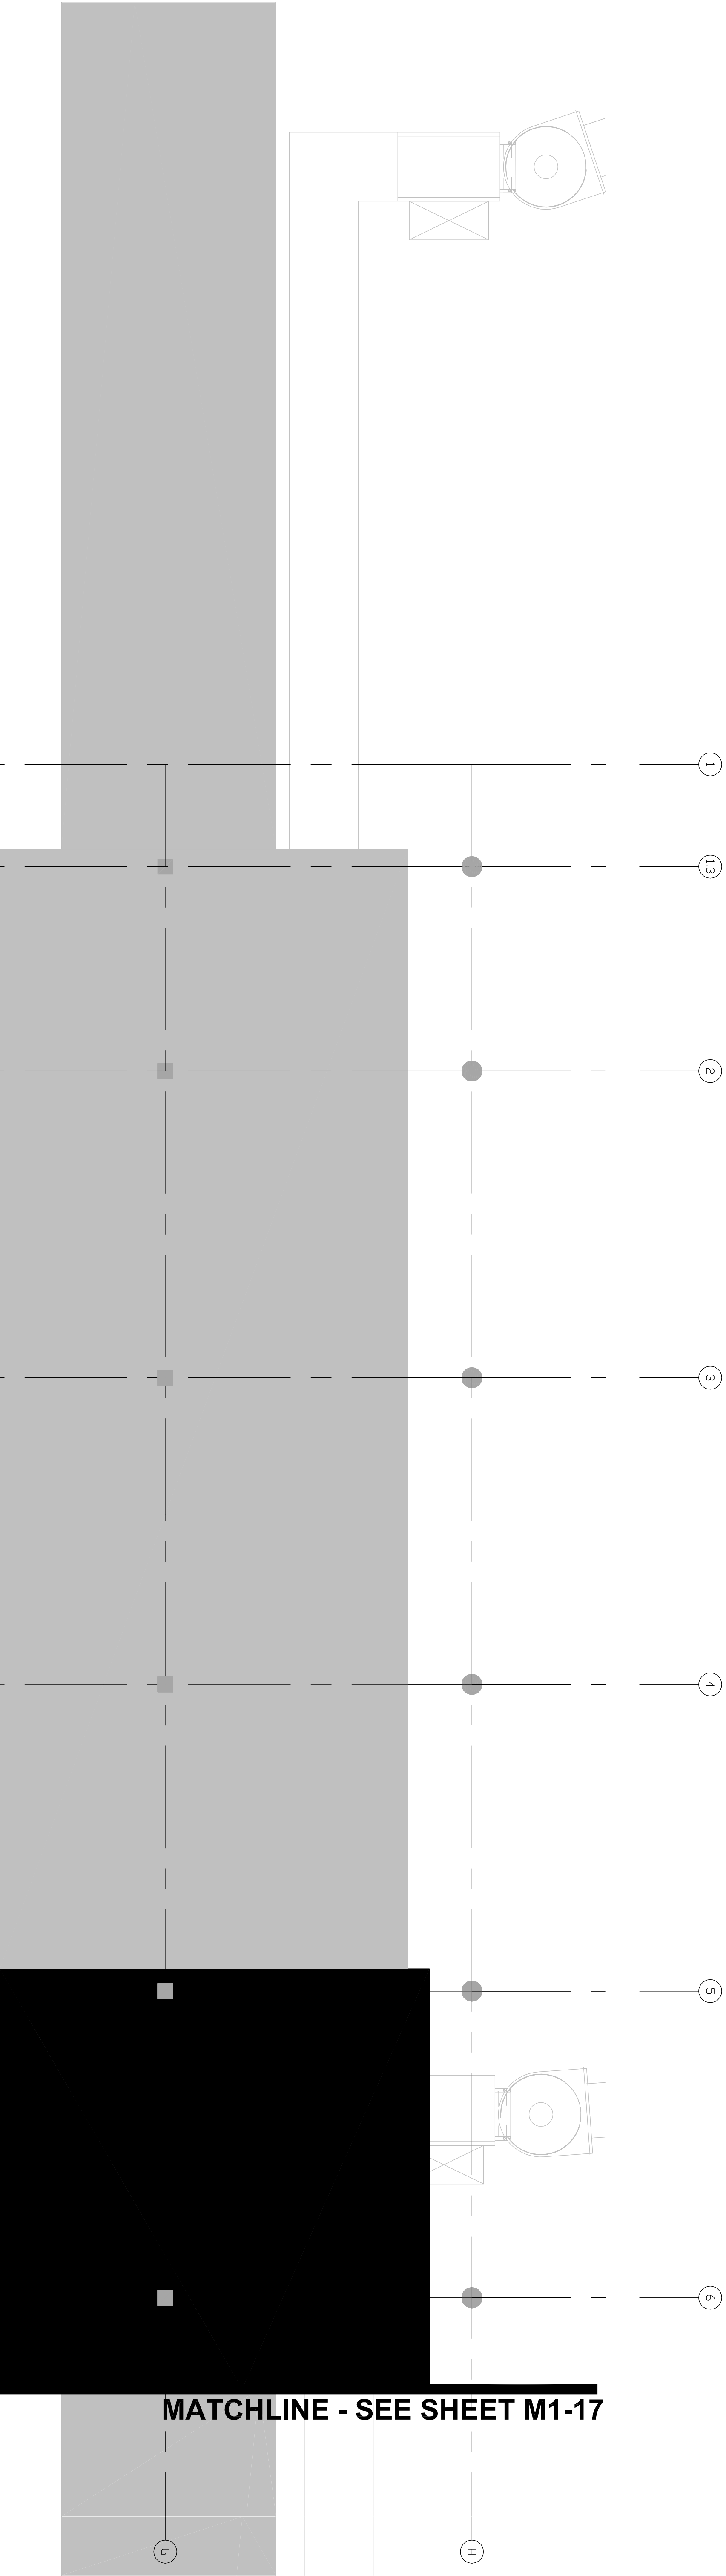

MATCHLINE - SEE SHEET M1-17

1
1/8" = 1'-0"

ENLARGED MECHANICAL ROOF PLAN - AREA A