

REVISIONS		
NO.	DESCRIPTION	DATE


DATE ISSUED: 10-30-09
REVIEWED BY: XXX
DRAWN BY: SA
DESIGNED BY: SA

AEP PROJECT NUMBER
213-1882-091
© 2008 REYNOLDS, SMITH AND HILLS INC.

SHEET TITLE
ENLARGED UNDERGROUND PLUMBING PLAN AREA A

SHEET NUMBER
P1-102

30% NOT FOR CONSTRUCTION

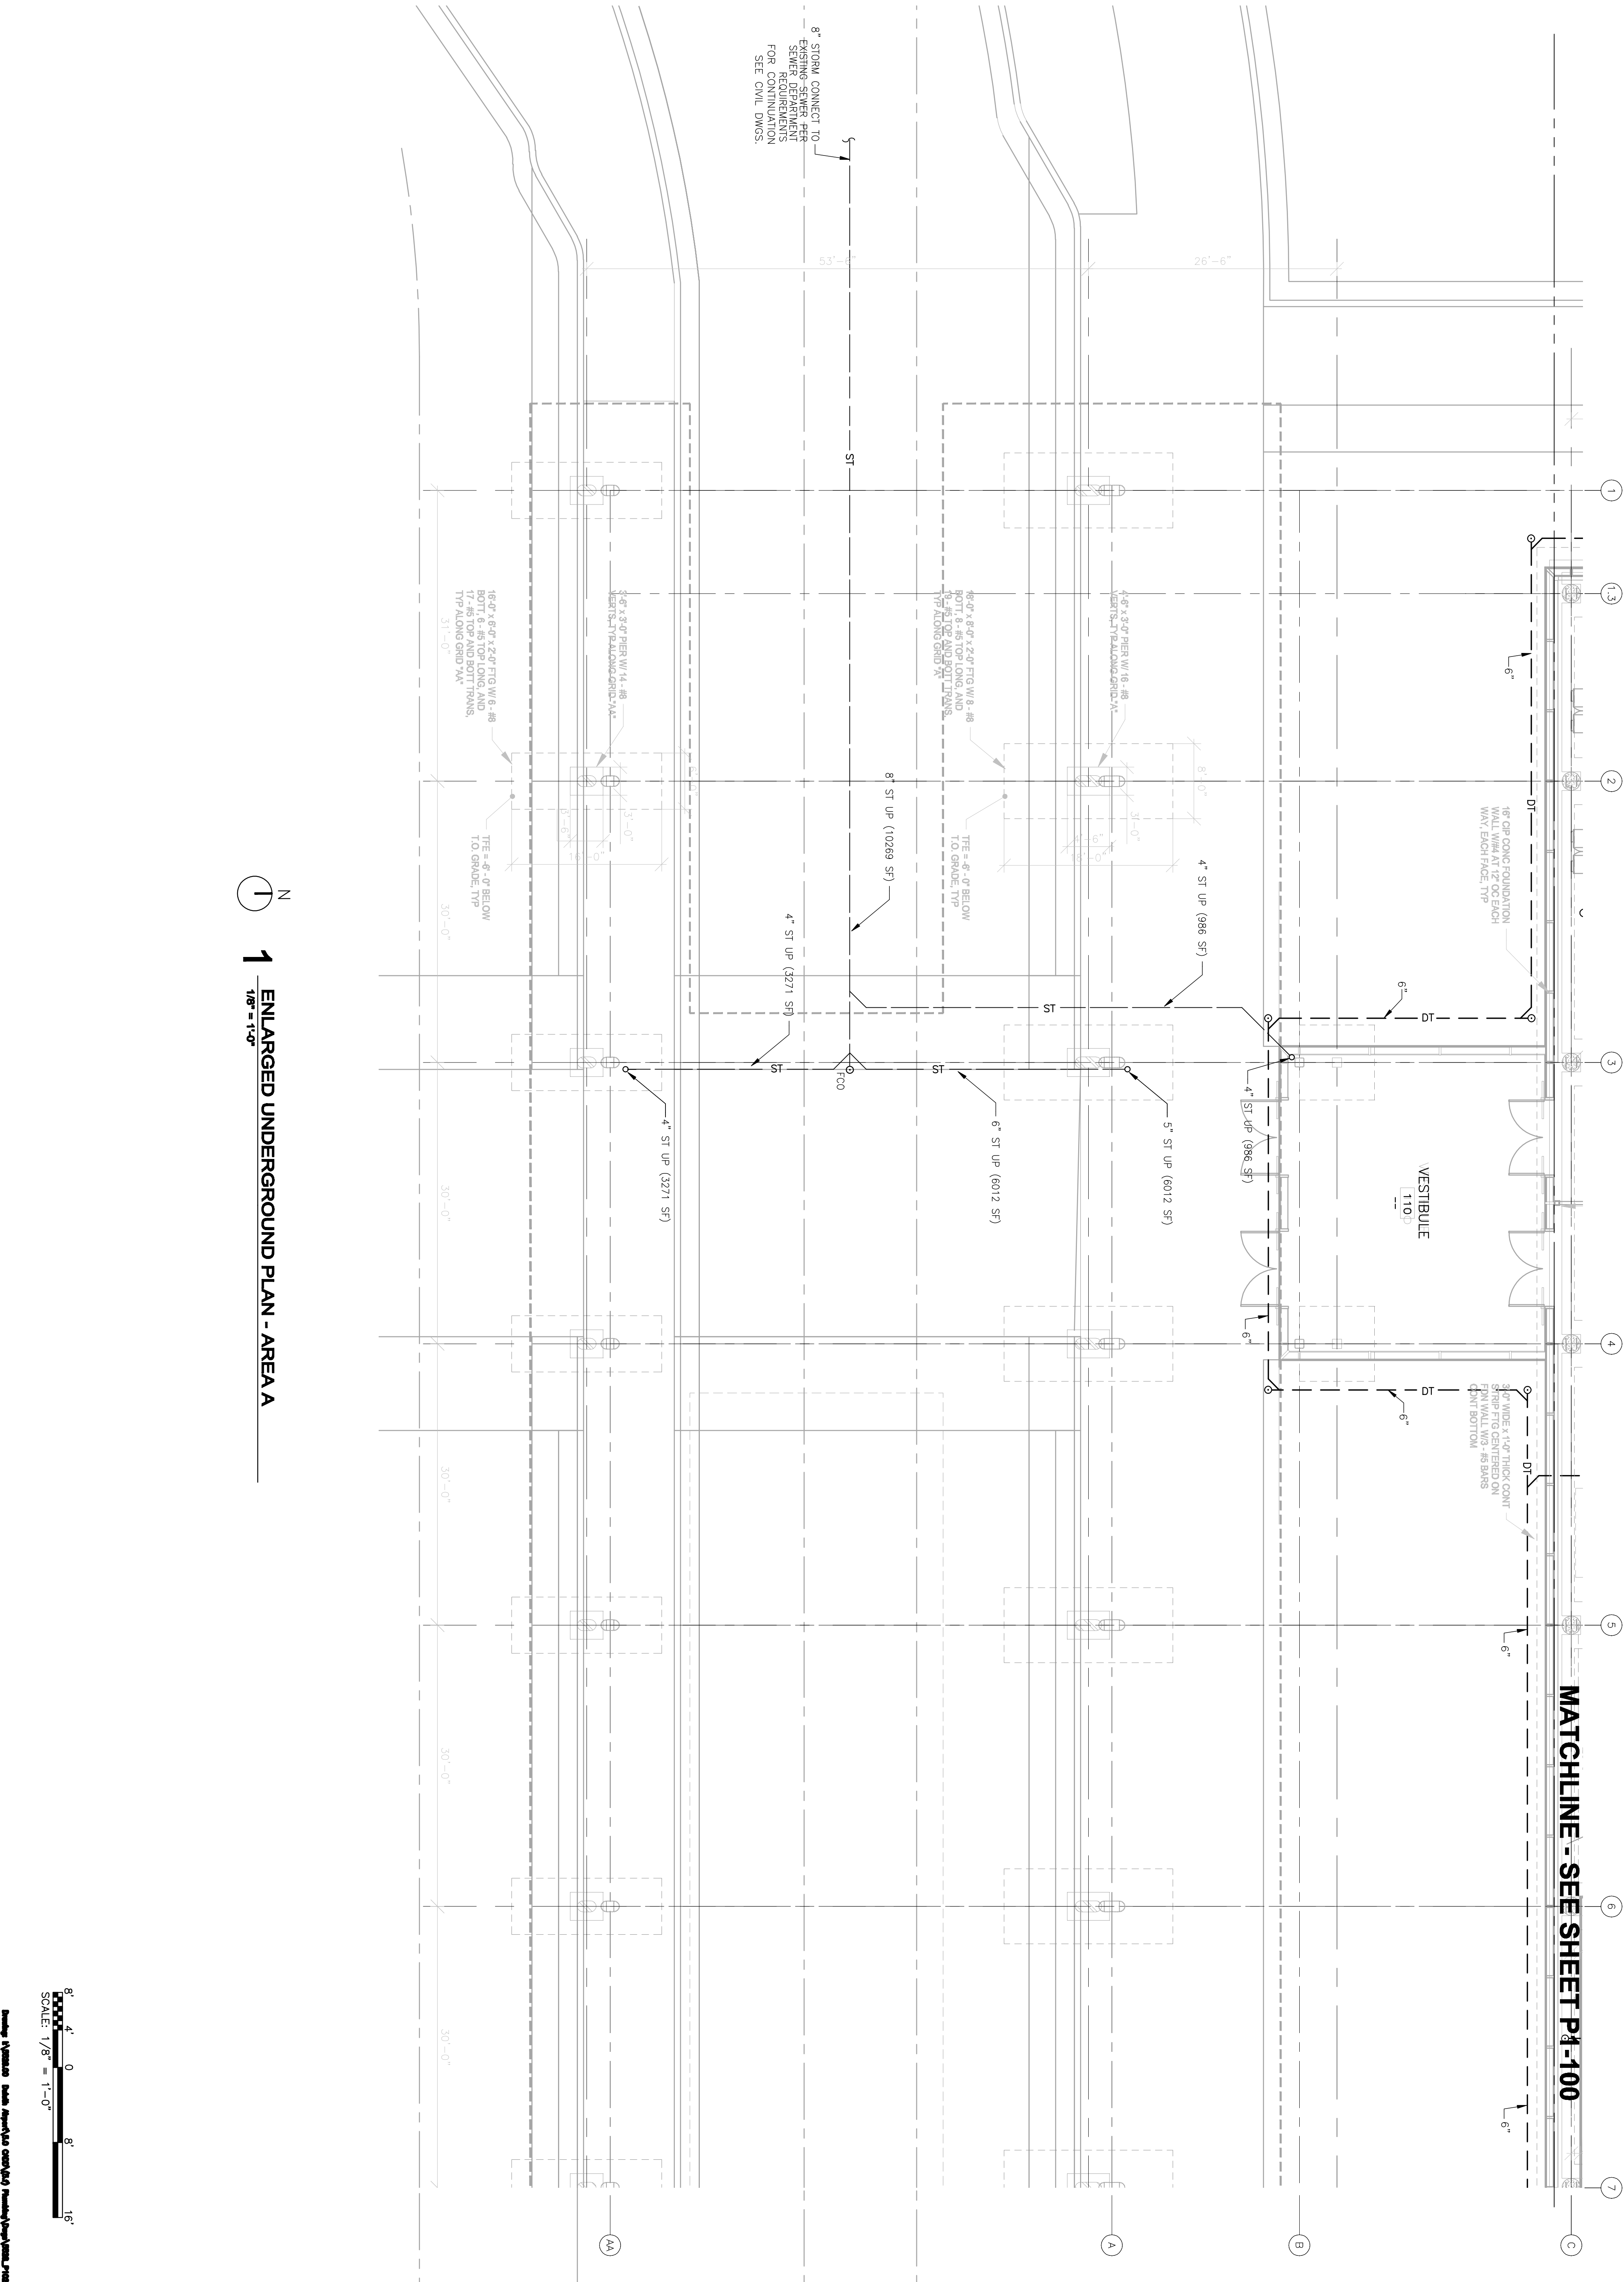

ENLARGED UNDERGROUND PLAN - AREA A

