



DULUTH
INTERNATIONAL
AIRPORT
DULUTH, MN

NEW TERMINAL
DESIGN

CONSULTANTS

SJA ARCHITECTS
11 E Superior Street Suite 340, Duluth MN 55802
TEL: (218) 725-8578 / FAX: (218) 724-8717
www.sjaarchitecture.com

MBJ CONSULTING ENG.
601 Lakeside Avenue, Suite 100, Duluth MN 55802
TEL: (218) 725-1059 / FAX: (218) 725-8838
www.mbjeng.com

BNP ASSOCIATES INC.
101 East Ridge Office Park, Suite 103, Dunbar CT 06810
TEL: (203) 725-3000 / FAX: (203) 725-4000
www.bnpproducts.com

COSENTINI
1 East Wacker Drive, Suite 103, Chicago IL 60601
TEL: (812) 670-1800 / FAX: (812) 670-1801
www.cosentini.com

APPOLD DESIGN
2482 East Park Street, Duluth MN 55812
TEL: (218) 725-5775
www.appolddesign.com

KRAUS-ANDERSON
3716 Omega Street, Duluth MN 55807
TEL: (218) 725-5775
www.krausanderson.com

LIGHTING
XXXXXXXXXX
TEL: (203) 300-XXXX
www.xxxxxxxx.com

REVISIONS

NO.	DESCRIPTION	DATE


DATE ISSUED: 10-30-09
REVIEWED BY: XXX
DRAWN BY: SA
DESIGNED BY: SA

AEP PROJECT NUMBER
213-1882-091
© 2006 REYNOLDS, SMITH AND HILLS INC.

ENLARGED
UNDERGROUND
PLUMBING
PLAN AREA B

SHEET NUMBER
P1-103

30% NOT FOR
CONSTRUCTION

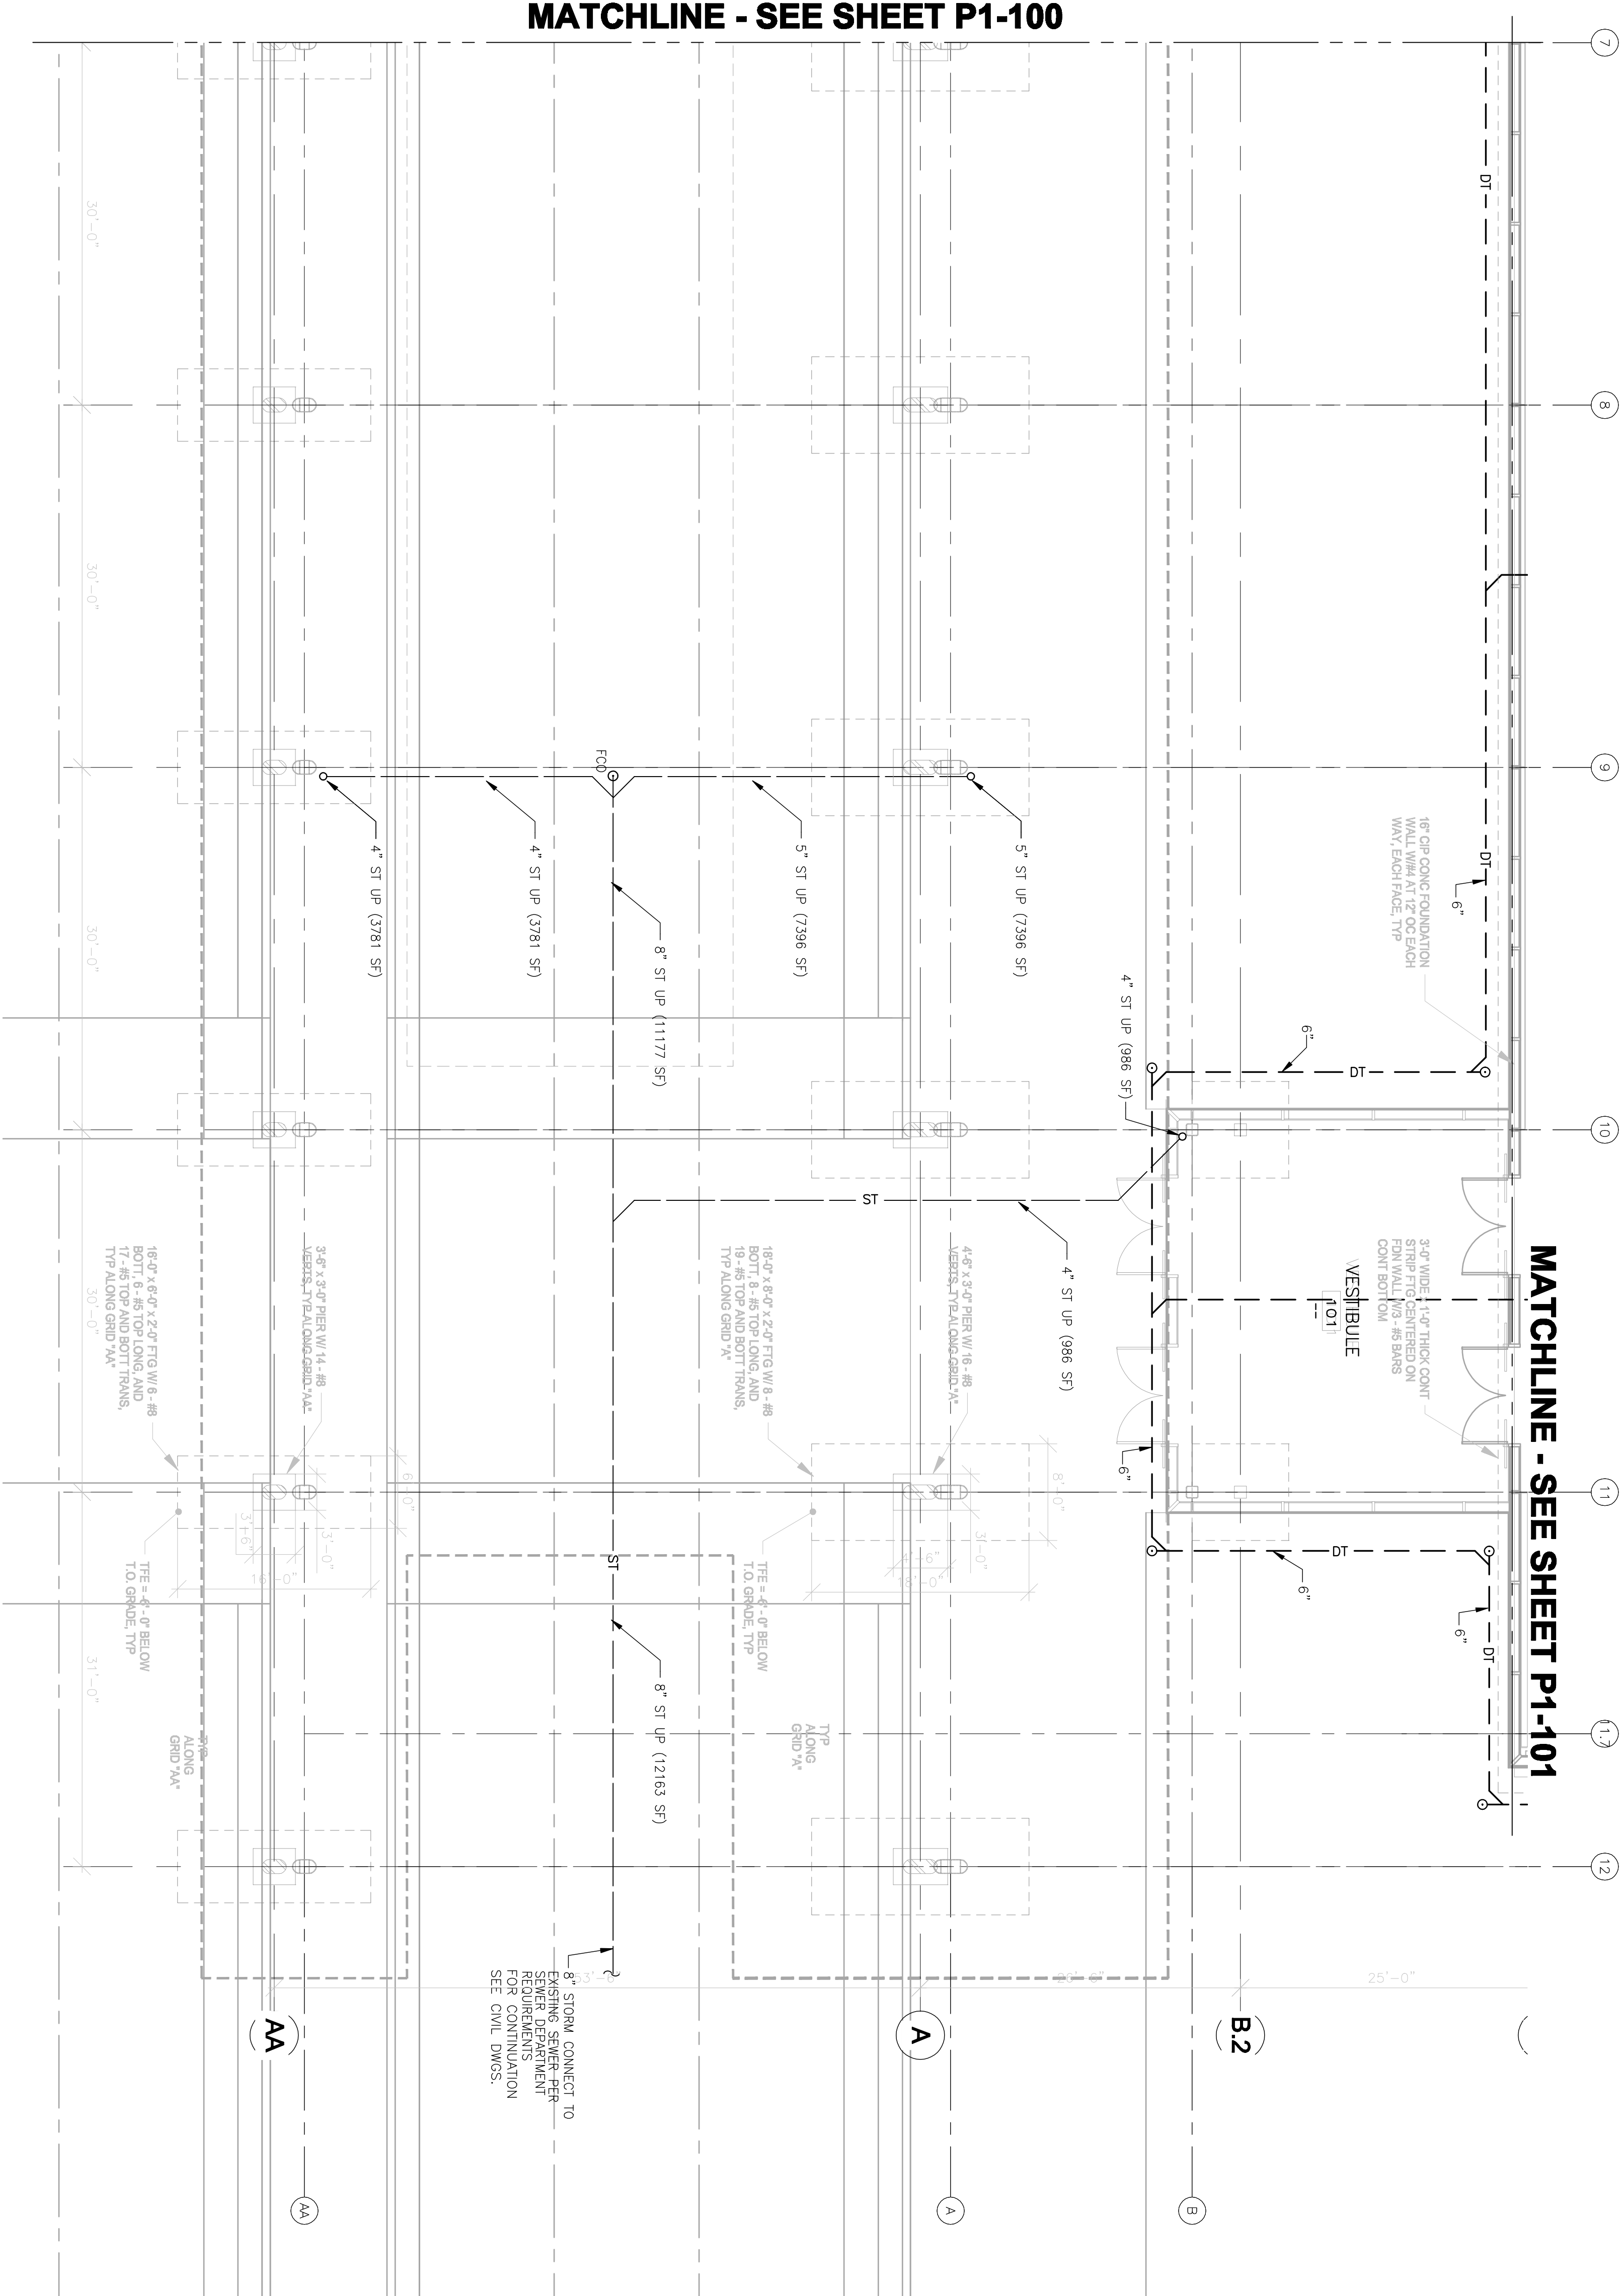

MATCHLINE - SEE SHEET P1-100

MATCHLINE - SEE SHEET P1-101

1
1/8" = 1'-0"
ENLARGED FIRST LEVEL FLOOR PLAN - AREA B

8' 4' 0' 8'
SCALE: 1/8" = 1'-0"