


REVISIONS		
NO.	DESCRIPTION	DATE

DATE ISSUED: 10-30-09
REVIEWED BY: XXX
DRAWN BY: SA
DESIGNED BY: SA

AEP PROJECT NUMBER 213-1882-091
SHEET TITLE ENLARGED FIRST FLOOR PLUMBING PLAN AREA A

SHEET NUMBER P1-10

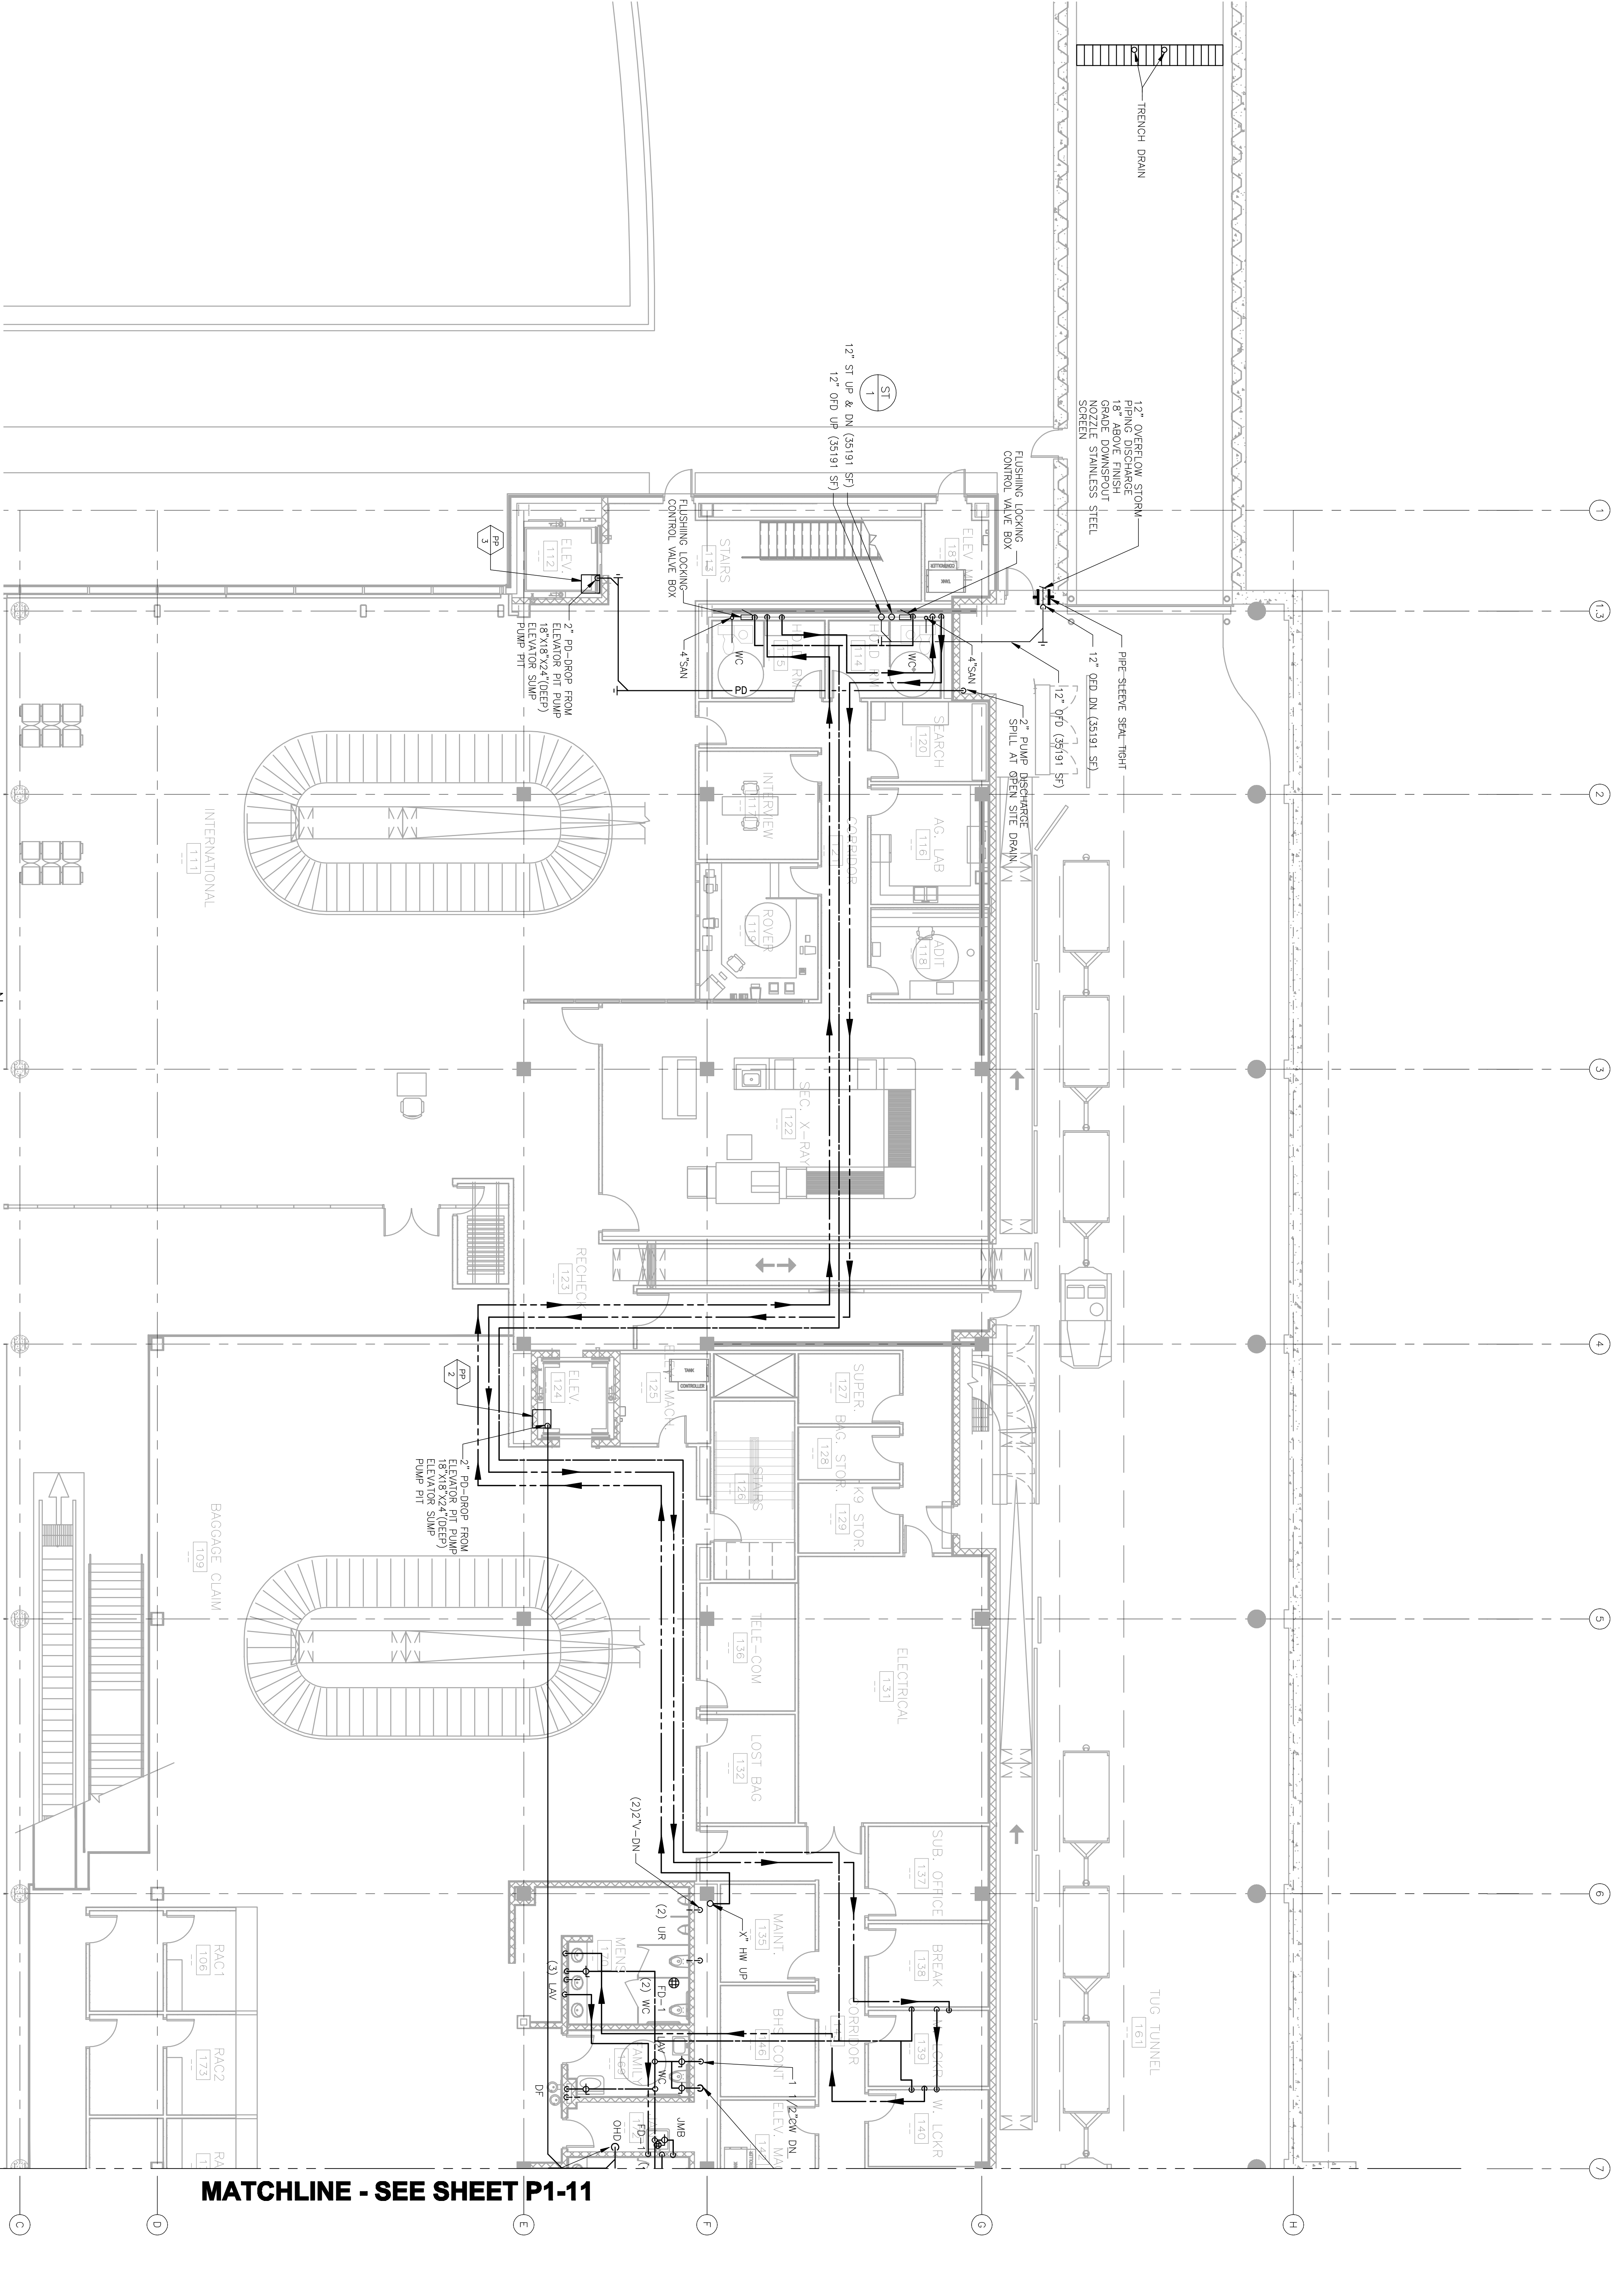

1 ENLARGED FIRST LEVEL FLOOR PLAN - AREA A
1/8" = 1'-0"

