

CONSULTANTS

REVISIONS

NO.	DESCRIPTION	DATE

DATE ISSUED: 10-30-09
REVIEWED BY: XXX
DRAWN BY: SA
DESIGNED BY: SA


AEP PROJECT NUMBER
213-1882-091
SHEET TITLE

ENLARGED
SECOND FLOOR
PLUMBING
PLAN AREA B

SHEET NUMBER
P1-13

30% NOT FOR
CONSTRUCTION

MATCHLINE - SEE SHEET P1-12

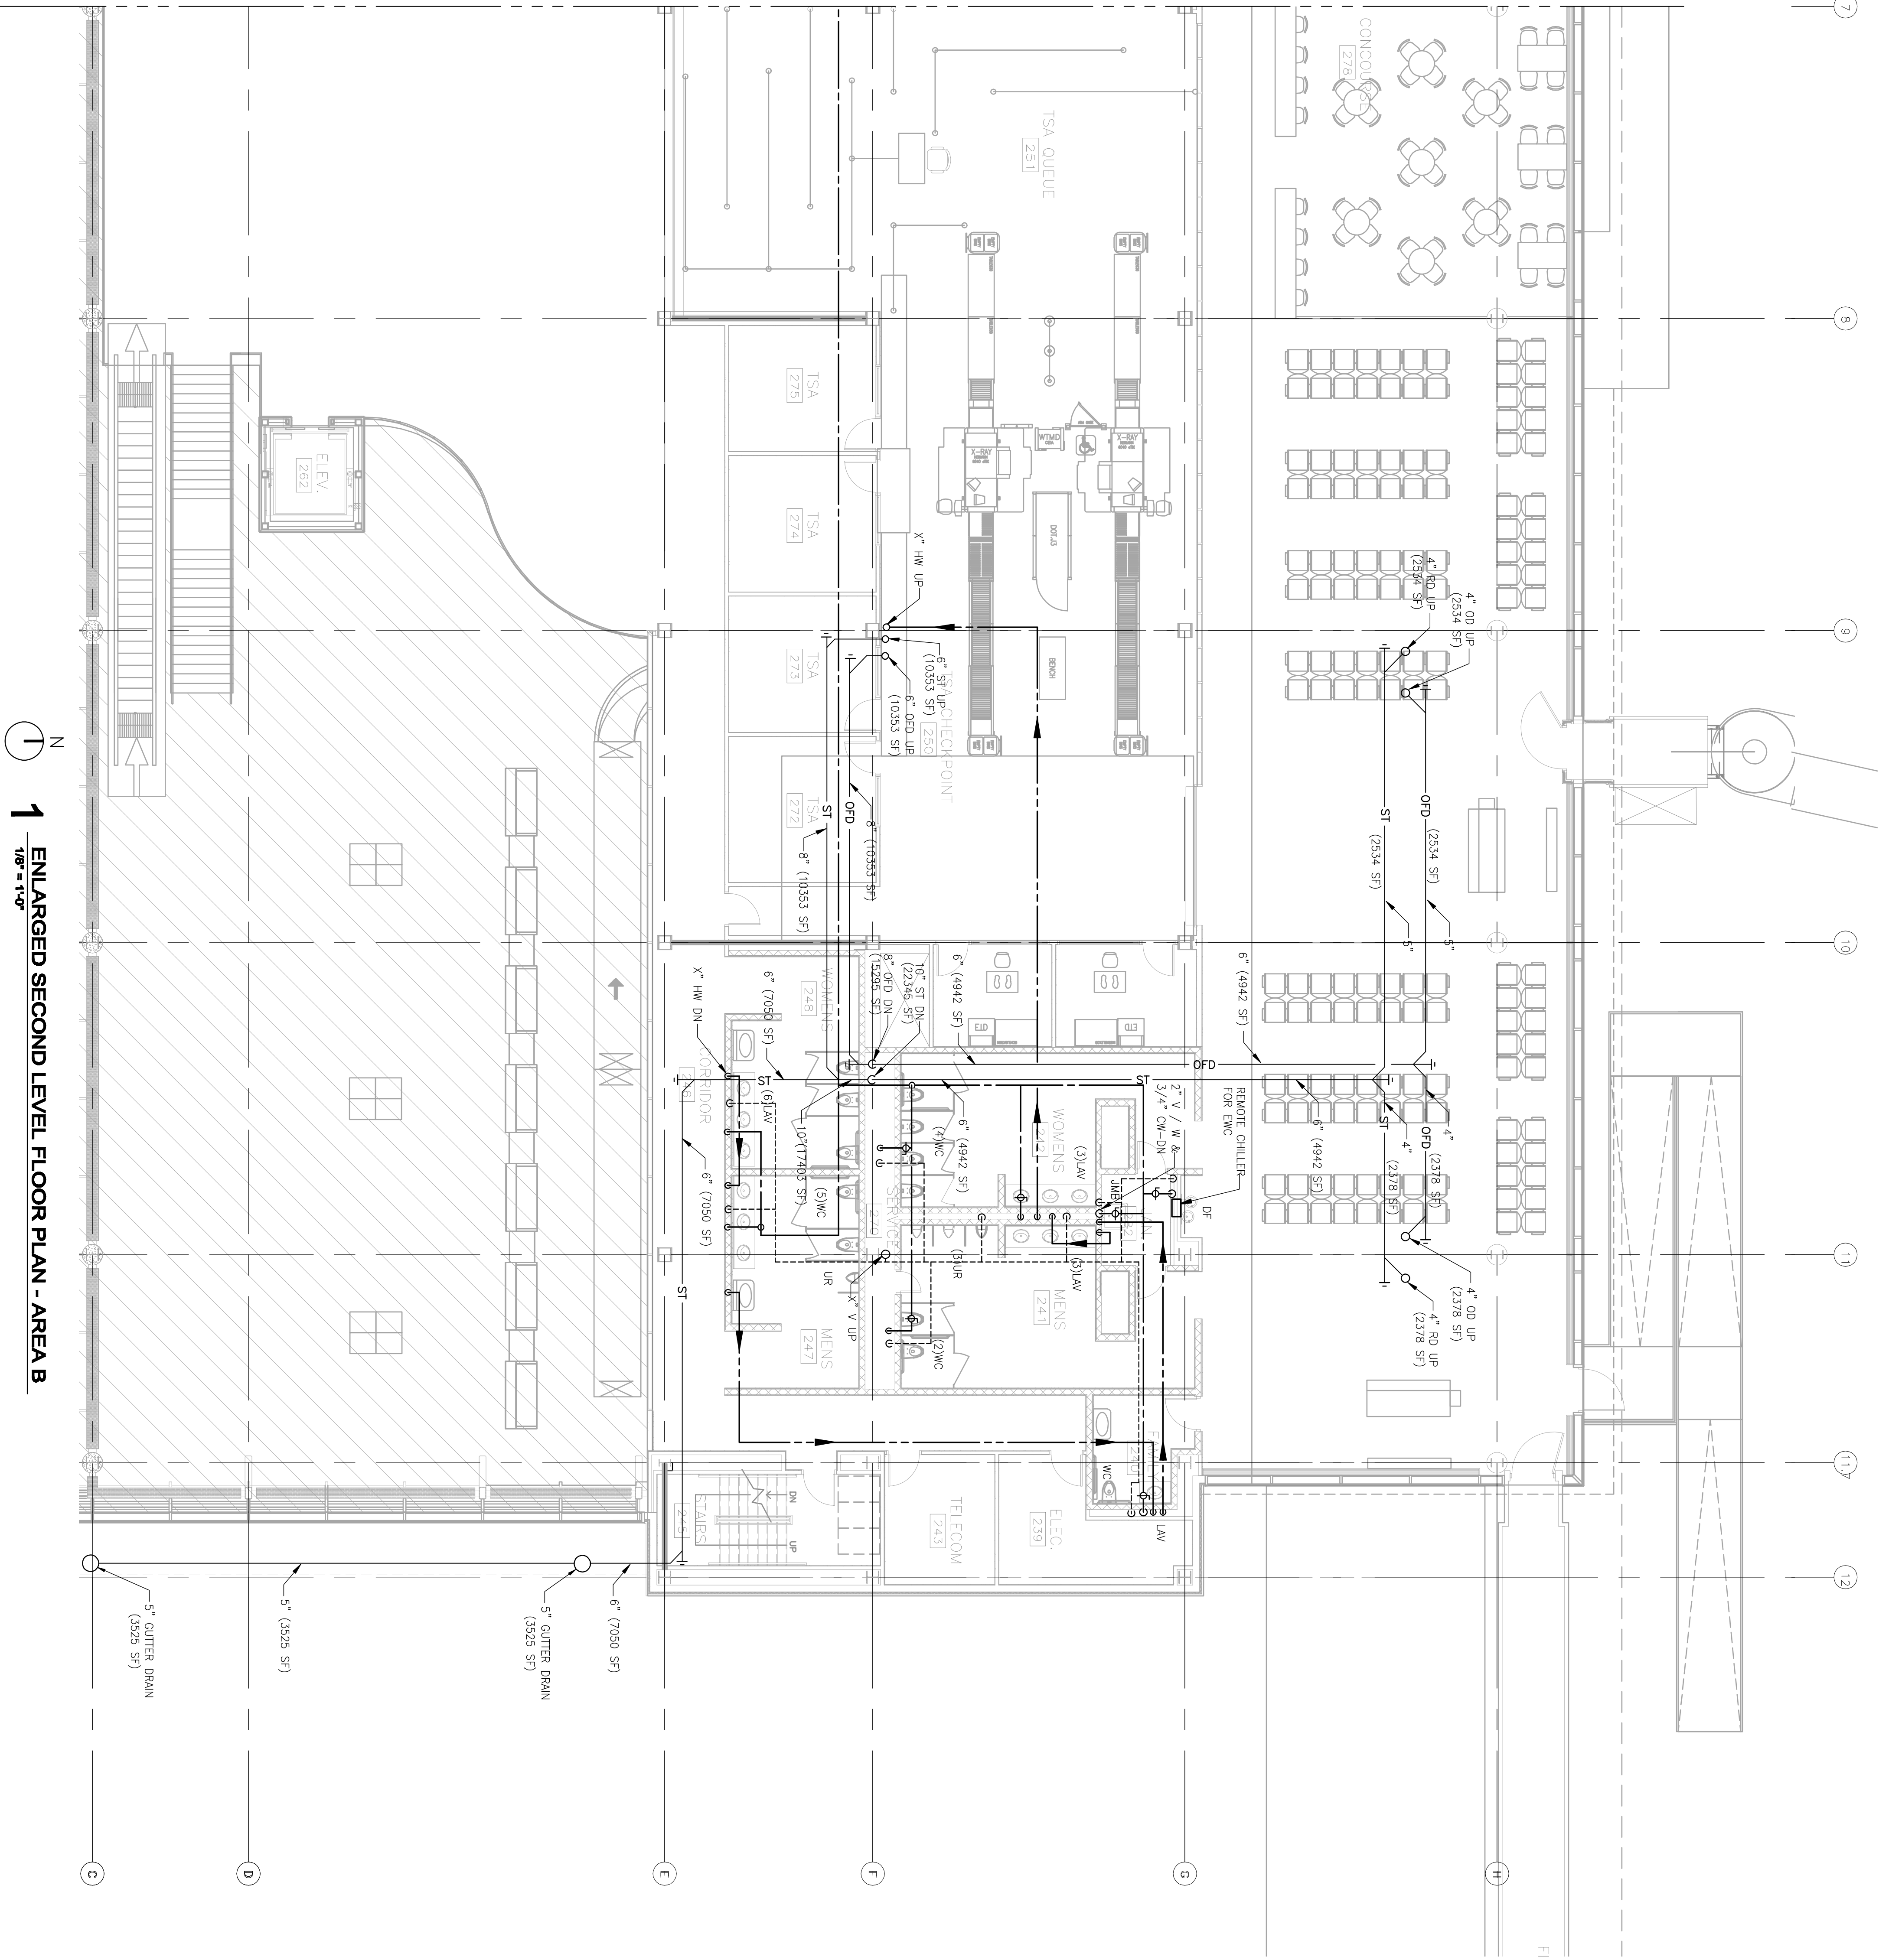

ENLARGED SECOND LEVEL FLOOR PLAN - AREA B

8' 4' 0' 8' 16'
SCALE: 1/8" = 1'-0"