



DULUTH
INTERNATIONAL
AIRPORT
DULUTH, MN

NEW TERMINAL
DESIGN

CONSULTANTS

SJA ARCHITECTS
11 E Superior Street Suite 340, Duluth MN 55802
TEL: (218) 724-8578 / FAX: (218) 724-8717
www.sjaarchitects.com

MBJ CONSULTING ENG.
601 Lake Avenue South, Suite 100, Duluth MN 55802
TEL: (218) 723-1050 / FAX: (218) 723-8038
www.mbjeng.com

BNP ASSOCIATES INC.
101 East Ridge Office Park, Suite 103, Dunbar CT 06810
TEL: (203) 726-3000 / FAX: (203) 726-4000
www.bnpside.com

COSENTINI
1 East Western Drive, Suite 103, Chicago IL 60601
TEL: (812) 670-1800 / FAX: (812) 670-1801
www.cosentini.com

APPOLD DESIGN
2482 East Pike Street, Duluth MN 55812
TEL: (218) 723-5775
www.appoldeng.com

KRAUS-ANDERSON
3716 Omega Street, Duluth MN 55807
TEL: (218) 723-5775
www.krausanderson.com

LIGHTING
XXXXXXXXXX
TEL: (203) 306-XXXX
www.3000xxx.com

REVISIONS

NO.	DESCRIPTION	DATE

DATE ISSUED: 10-30-09
REVIEWED BY: XXX
DRAWN BY: HV/SA
DESIGNED BY: SA


AEP PROJECT NUMBER
213-1882-091
© 2008 REYNOLDS, SMITH AND HILLS INC.

SHEET TITLE
ENLARGED
THIRD FLOOR
PLUMBING
PLAN AREA B

SHEET NUMBER
P1-15

30% NOT FOR
CONSTRUCTION

MATCHLINE - SEE SHEET P1-14

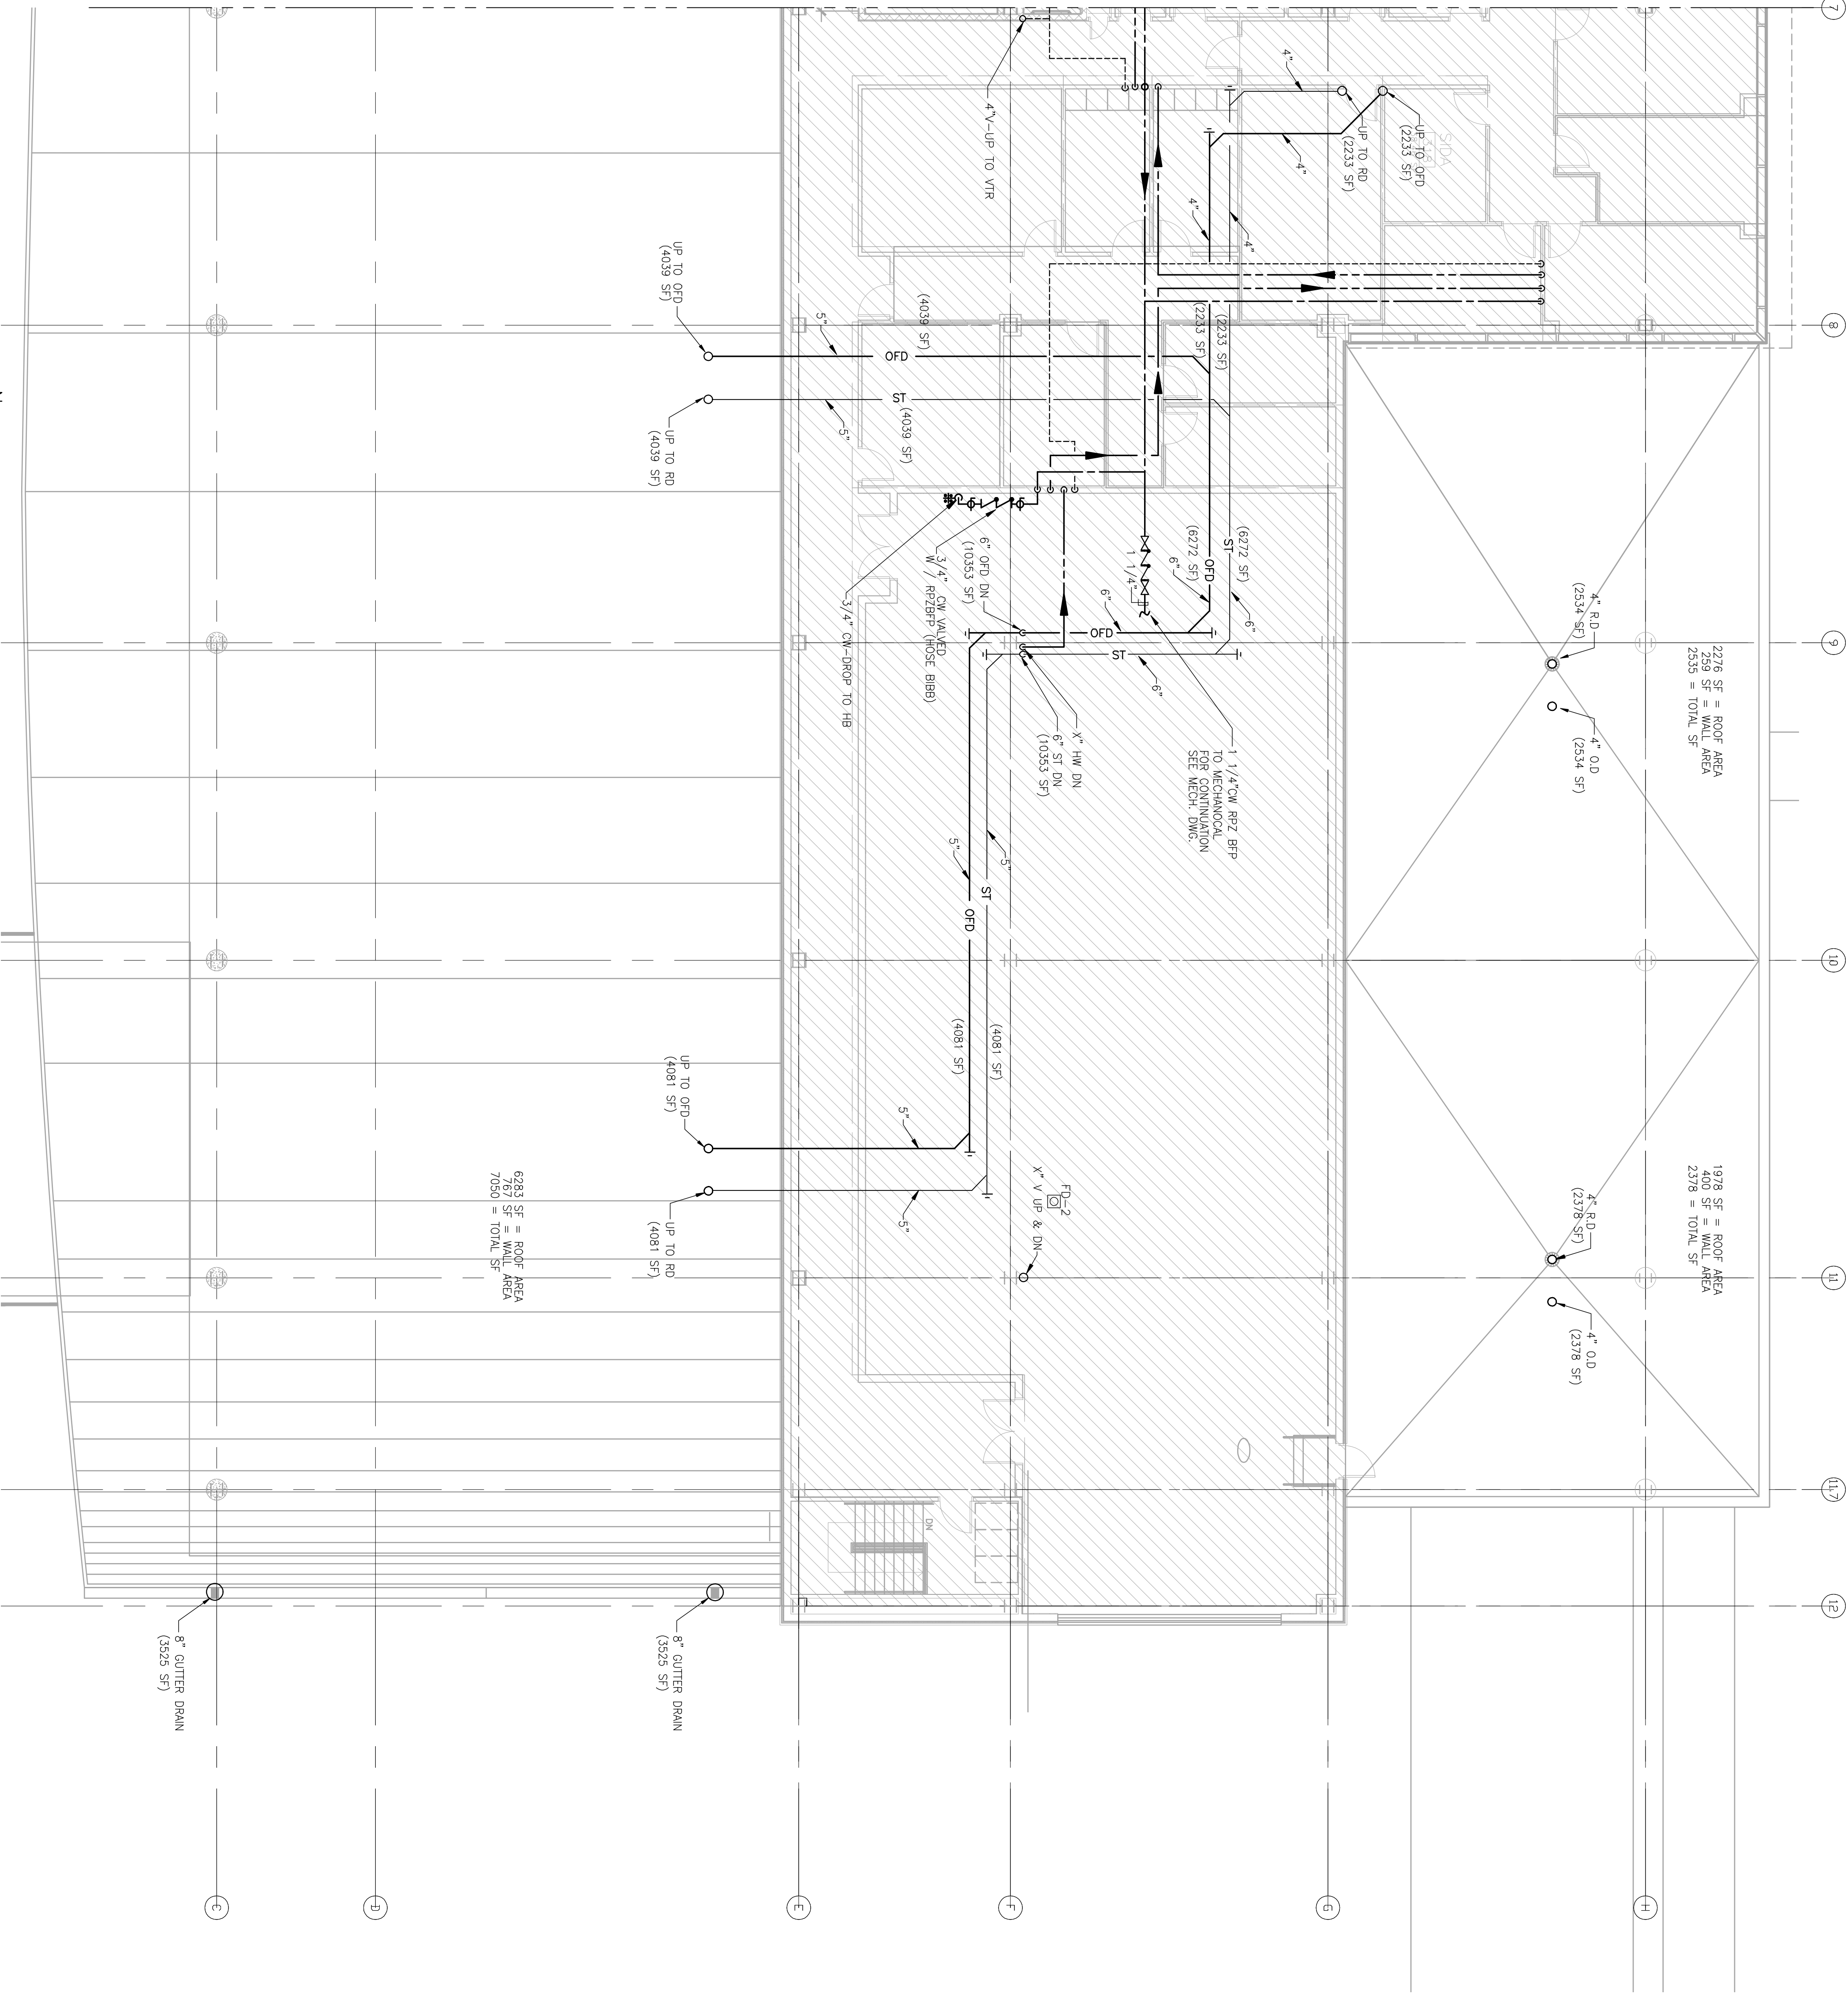

1 ENLARGED THIRD FLOOR PLAN - AREA B
1/8" = 1'-0"