

CONSULTANTS

SJA ARCHITECTS

11 E Superior Street Suite 340, Duluth MN 55802
TEL: (218) 724-8578 / FAX: (218) 724-8717
www.starkusjohnson.com

MBJ CONSULTING ENG.

501 Lake Avenue South, Suite 300, Duluth MN 55802
TEL: (218) 722-1066 / FAX: (218) 722-9306
www.mbjeng.com

BNP ASSOCIATES INC.

101 East Ridge Office Park, Suite 103, Danbury CT 06810
TEL: (203) 792-3000 / FAX: (203) 792-4900
www.bnpassociates.com

COSENTINI

1 East Wacker Drive, Suite 103, Chicago IL 60601
TEL: (312) 670-1800 / FAX: (312) 670-1801
www.cosentini.com

APPOLD DESIGN

2432 East First Street, Duluth MN 55812
TEL: (218) 591-5079
www.appoldesign.com

KRAUS-ANDERSON

3716 Onecota Street, Duluth MN 55807
TEL: (218) 722-3775
www.krausanderson.com

LIGHTING

XXXXXXXXXX
TEL: (XXX) XXX-XXXX
www.XXXXXXXX.com

REVISIONS

NO.	DESCRIPTION	DATE

DATE ISSUED: 10-30-09

REVIEWED BY: SBS/TC

DRAWN BY: MKG/MI

DESIGNED BY: SBS/TC

AEP PROJECT NUMBER

213-1882-091

© 2006 REYNOLDS, SMITH AND HILLS INC.


SHEET TITLE

WALL SECTIONS


SHEET NUMBER

A402


**30% NOT FOR
CONSTRUCTION**

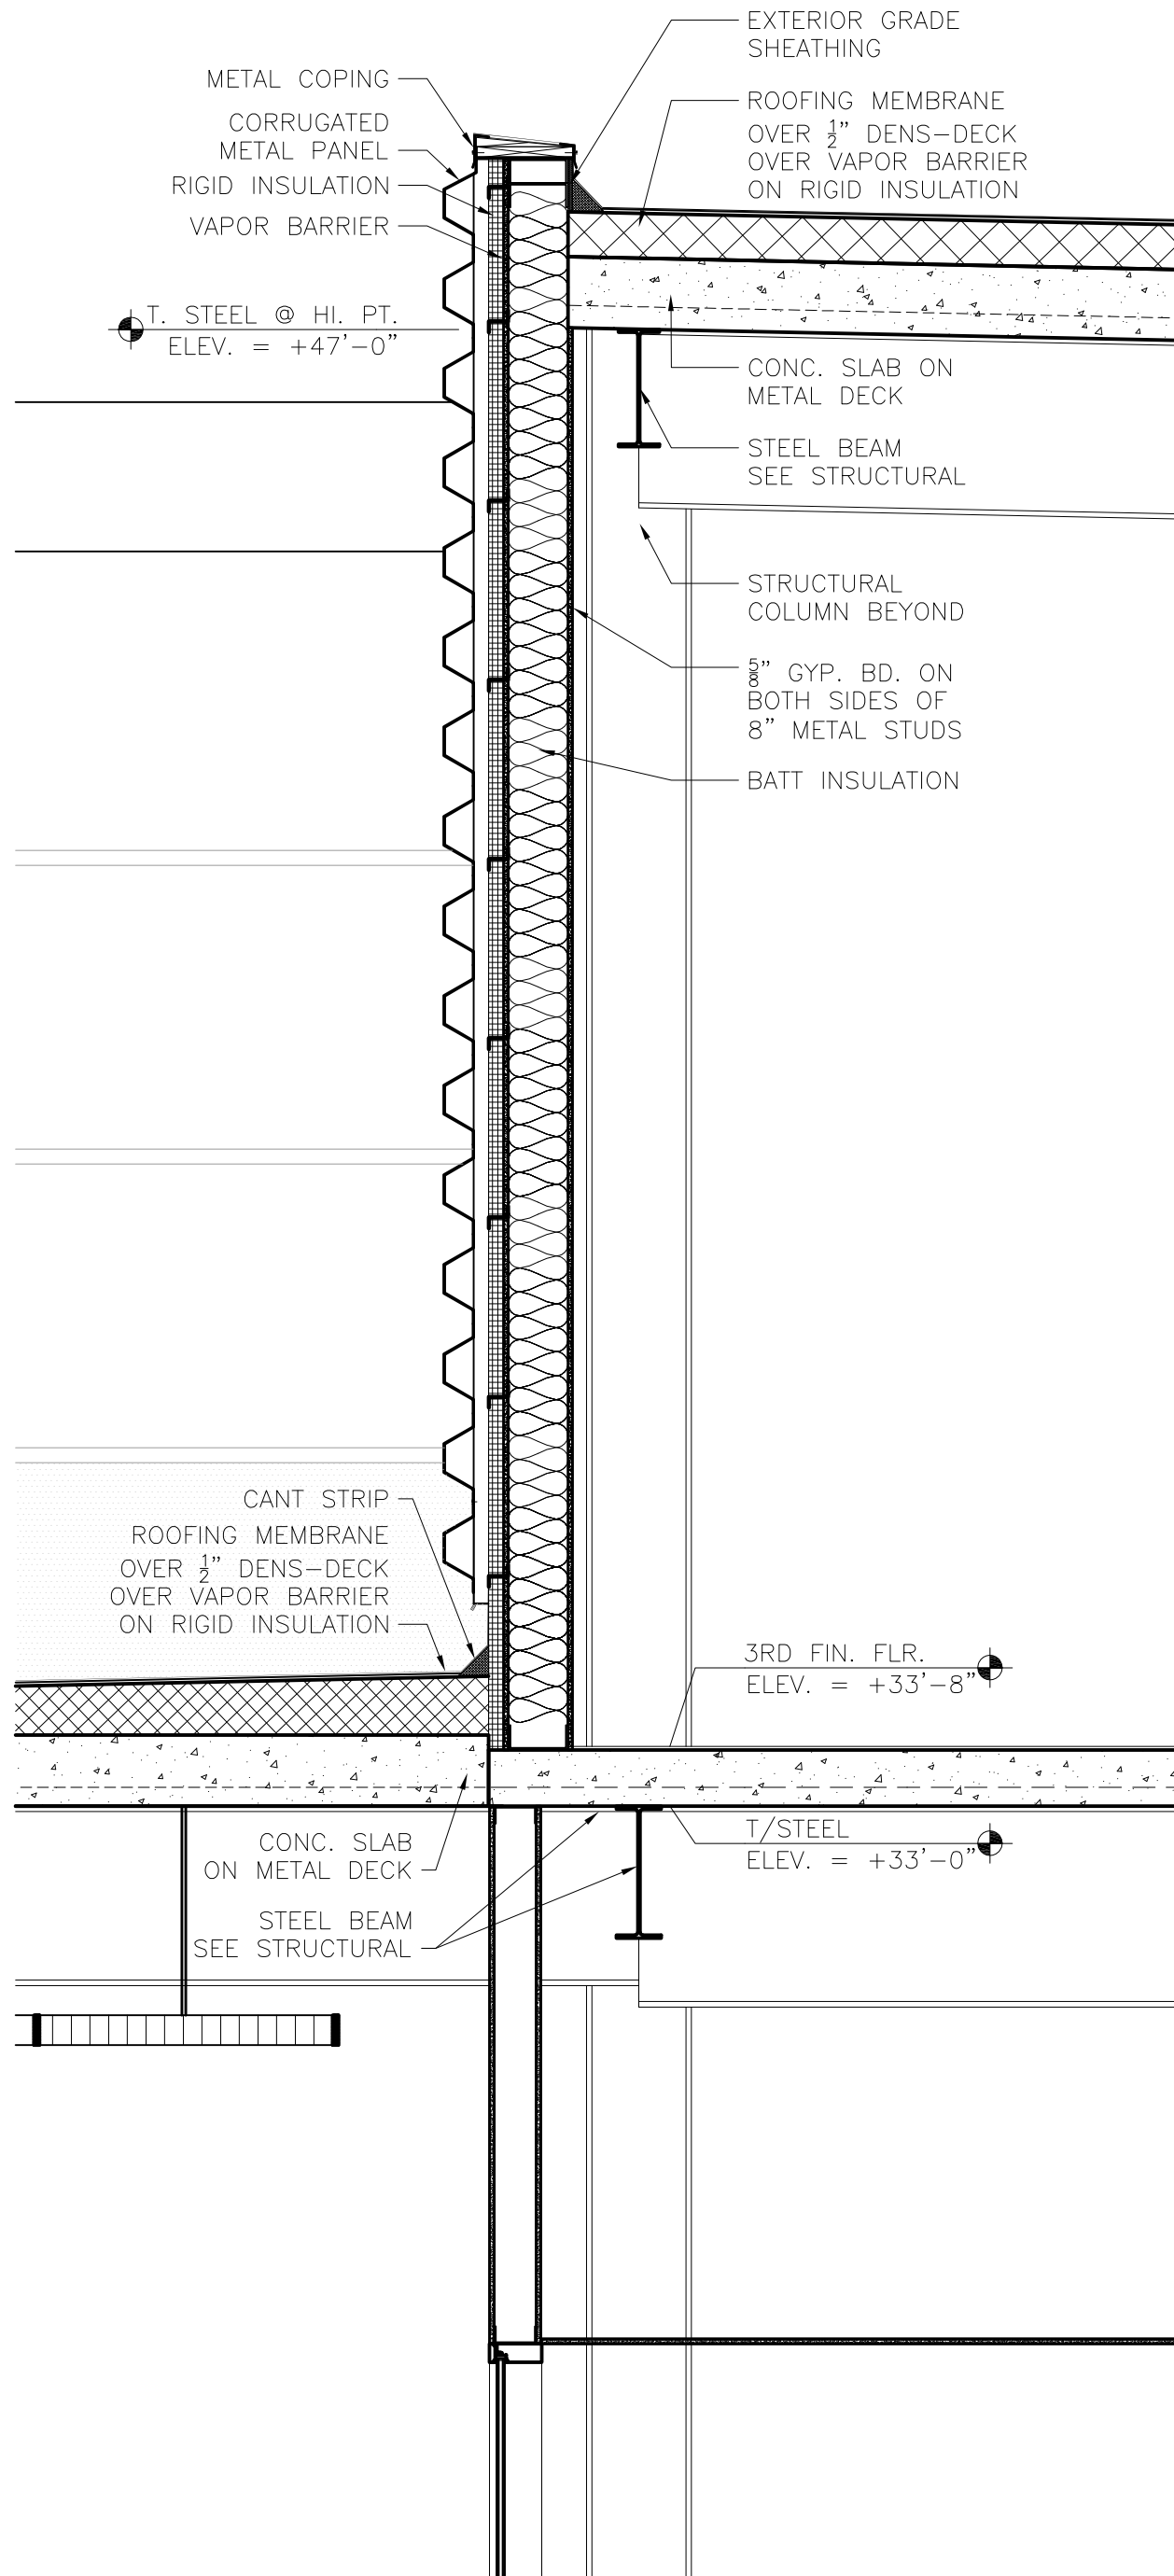

3 WALL SECTION @ CORE WALL
1/2" = 1'-0"

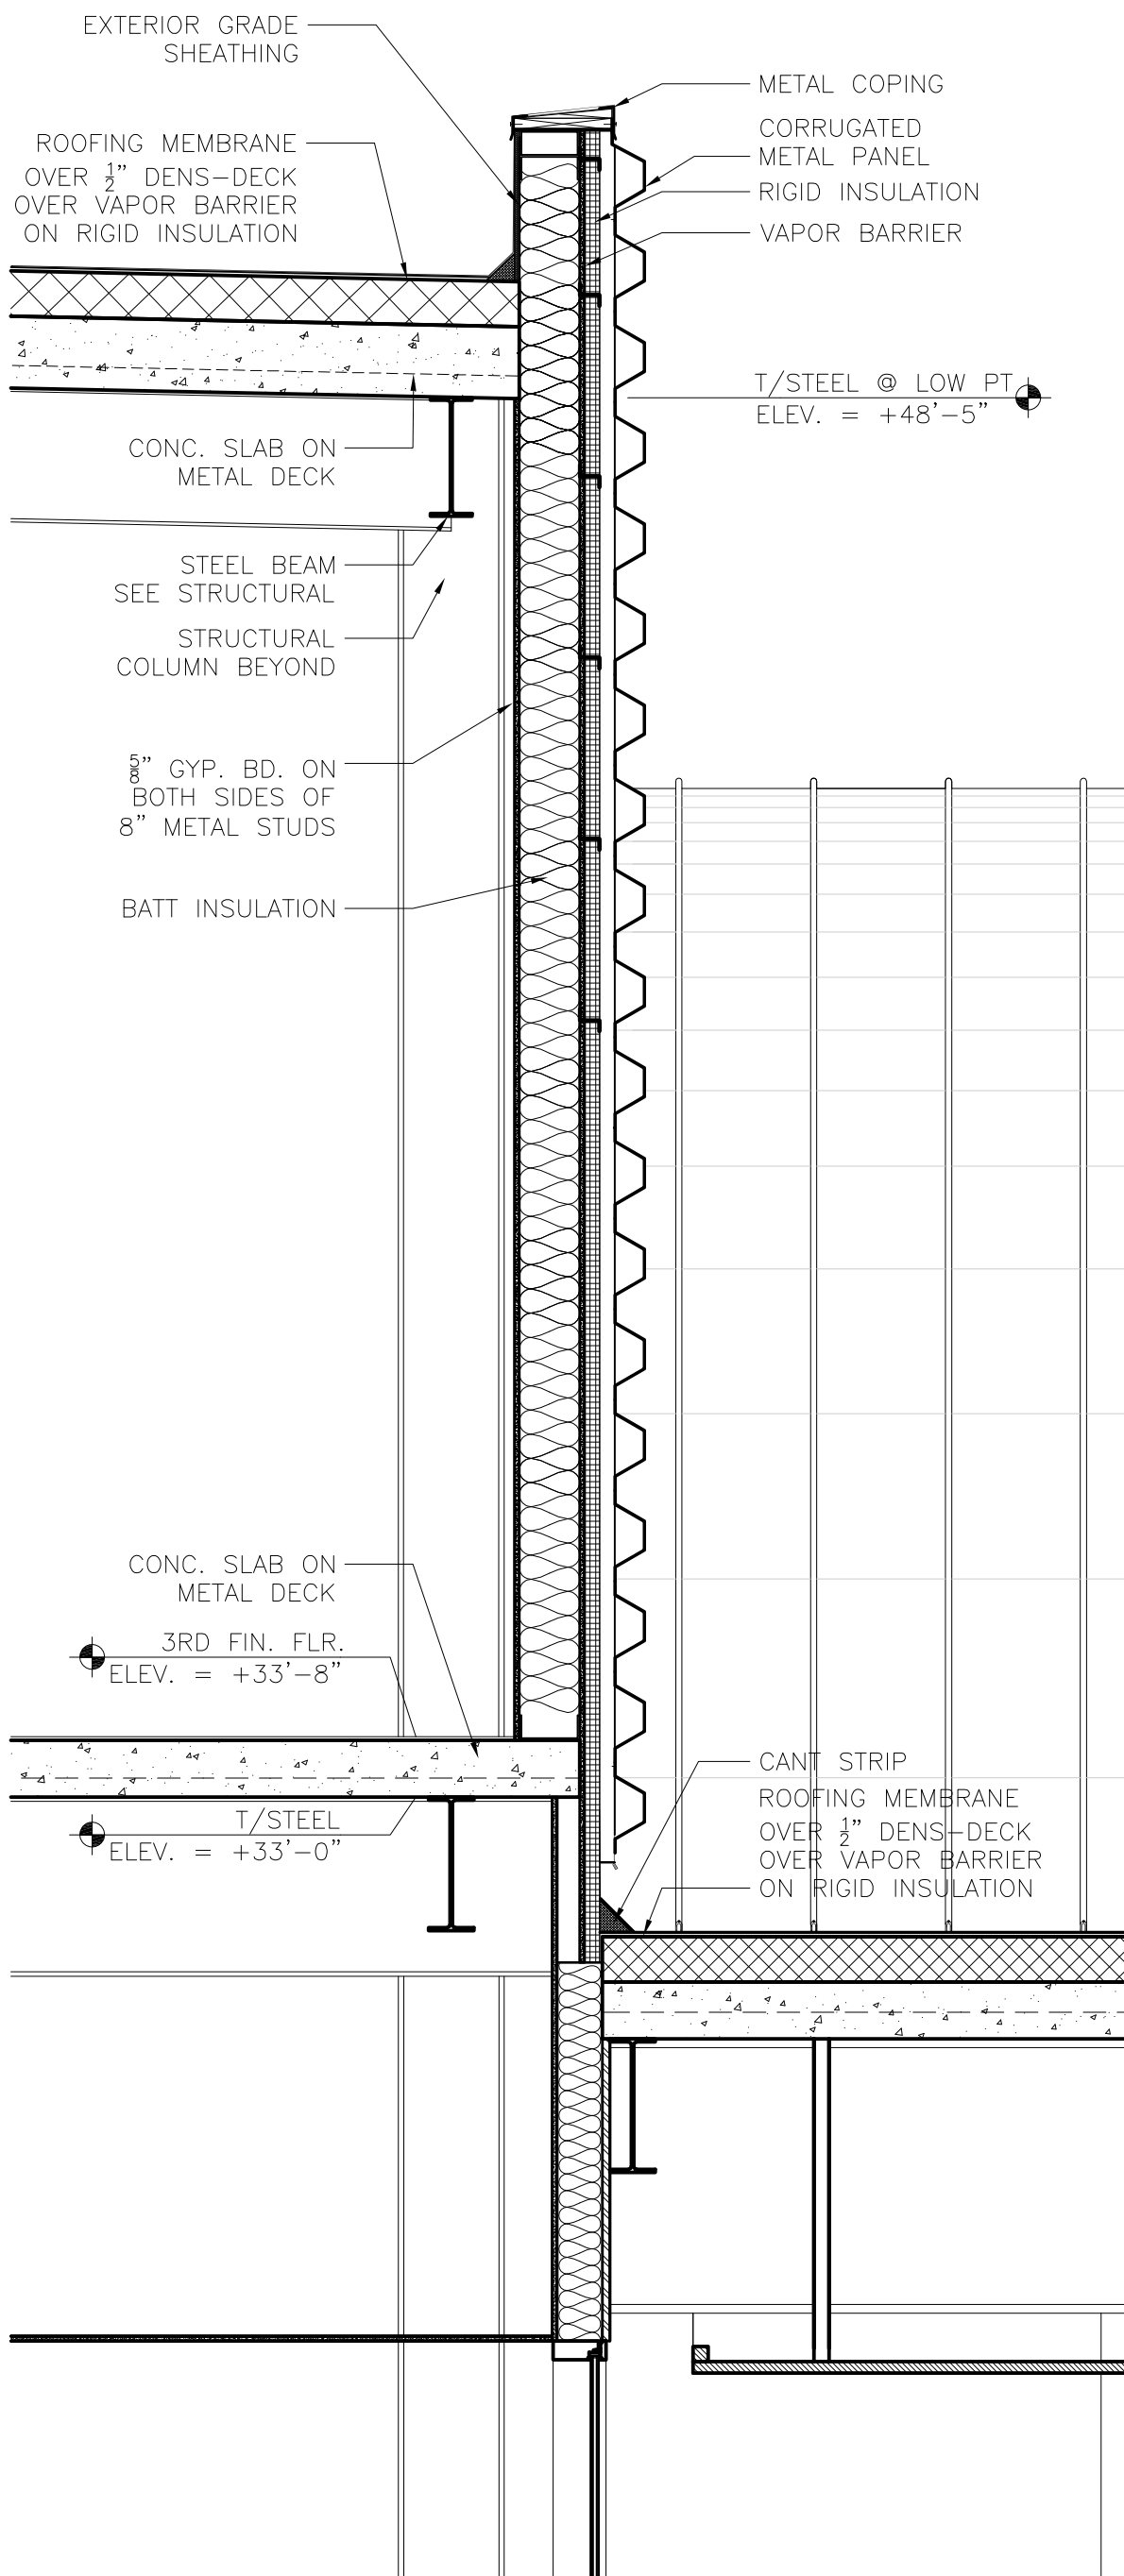

2 WALL SECTION @ CORE WALL
1/2" = 1'-0"

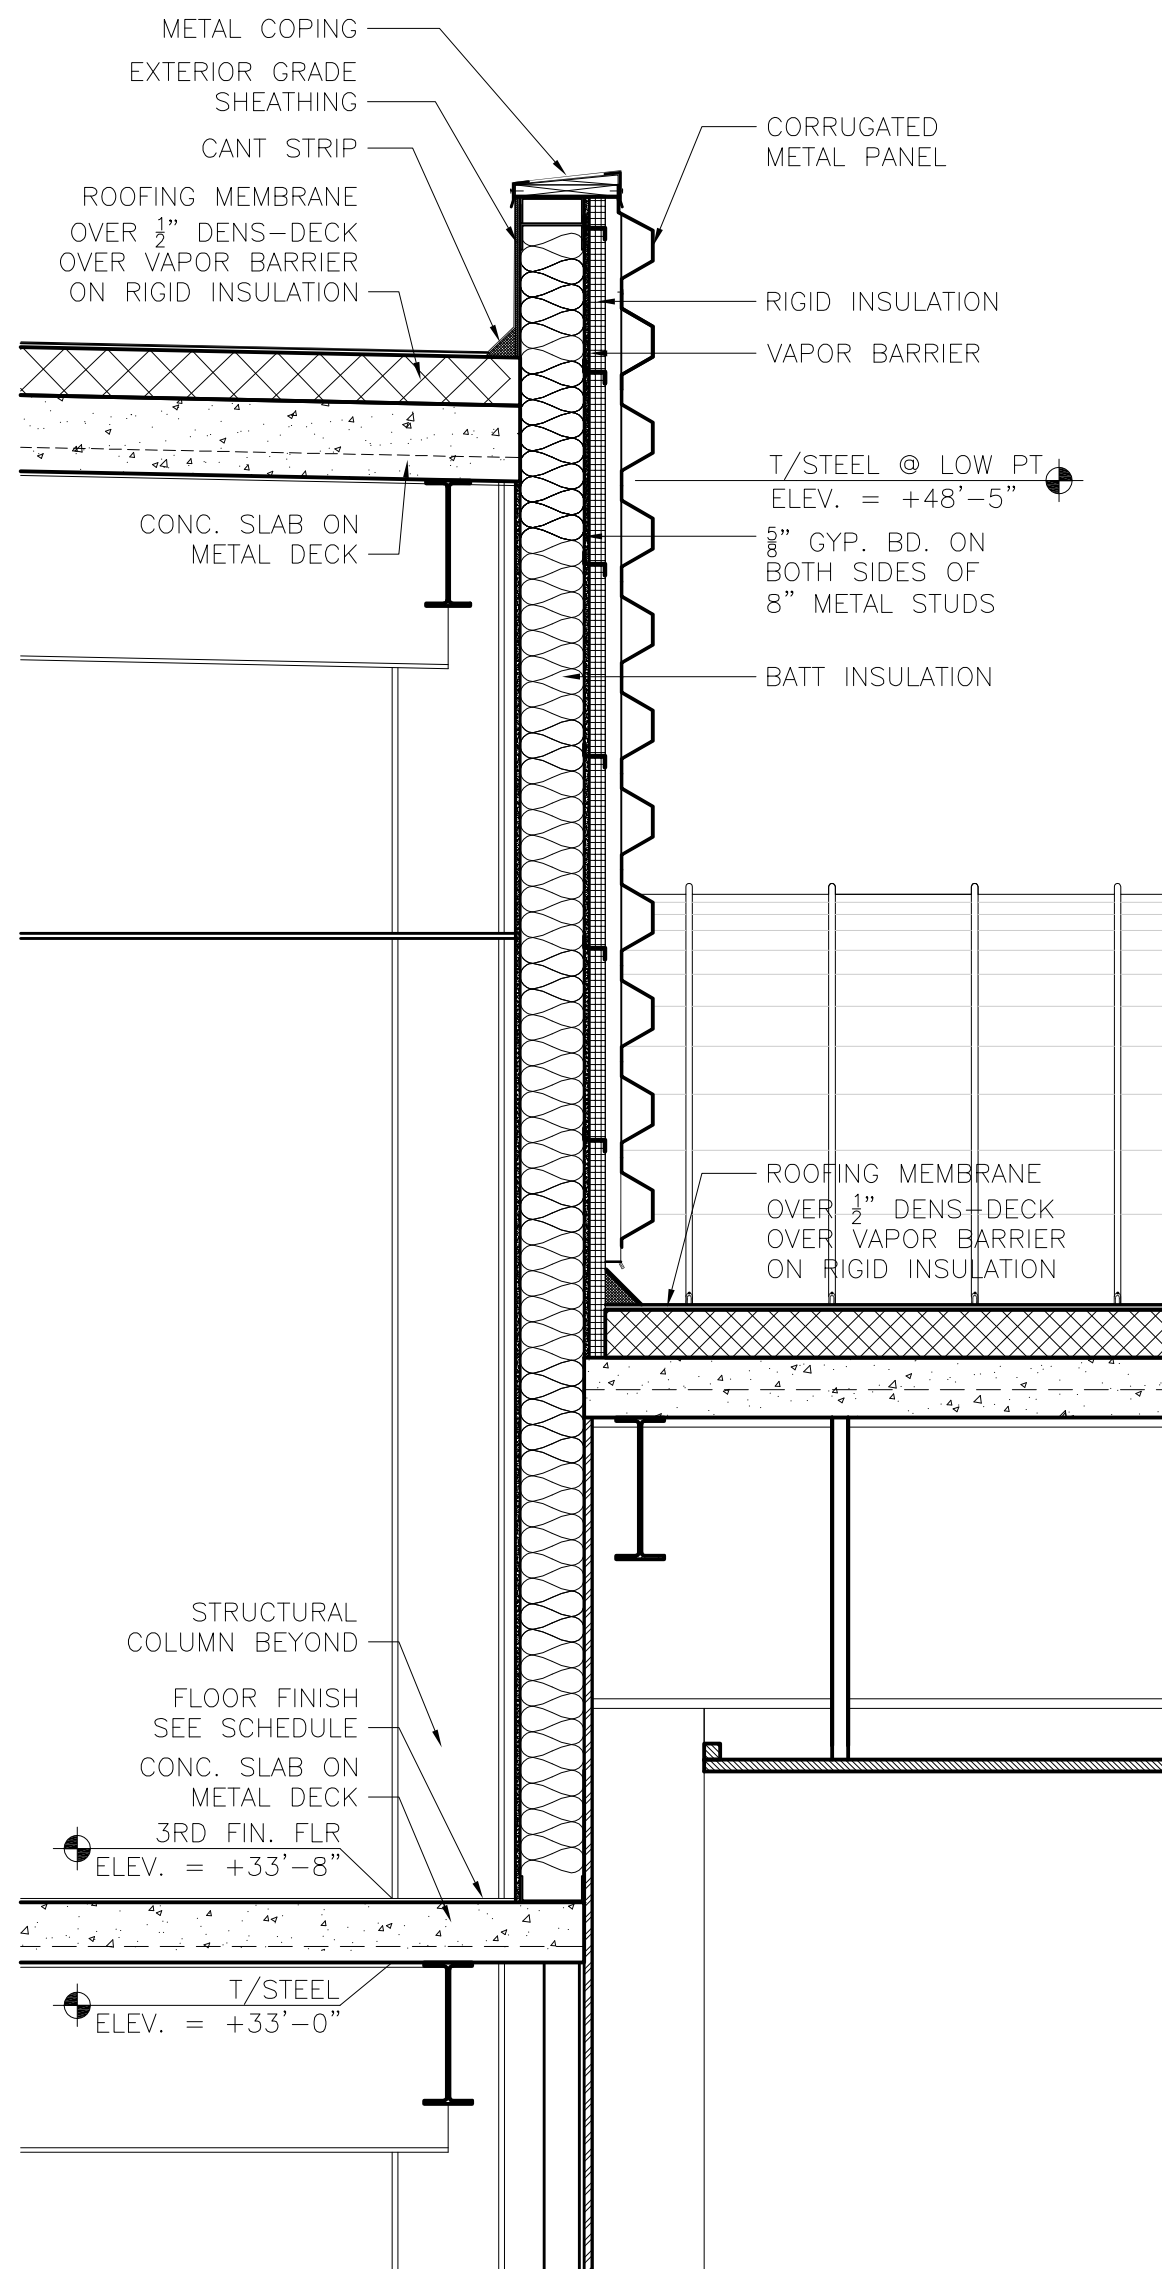

1 WALL SECTION @ CORE WALL
1/2" = 1'-0"