


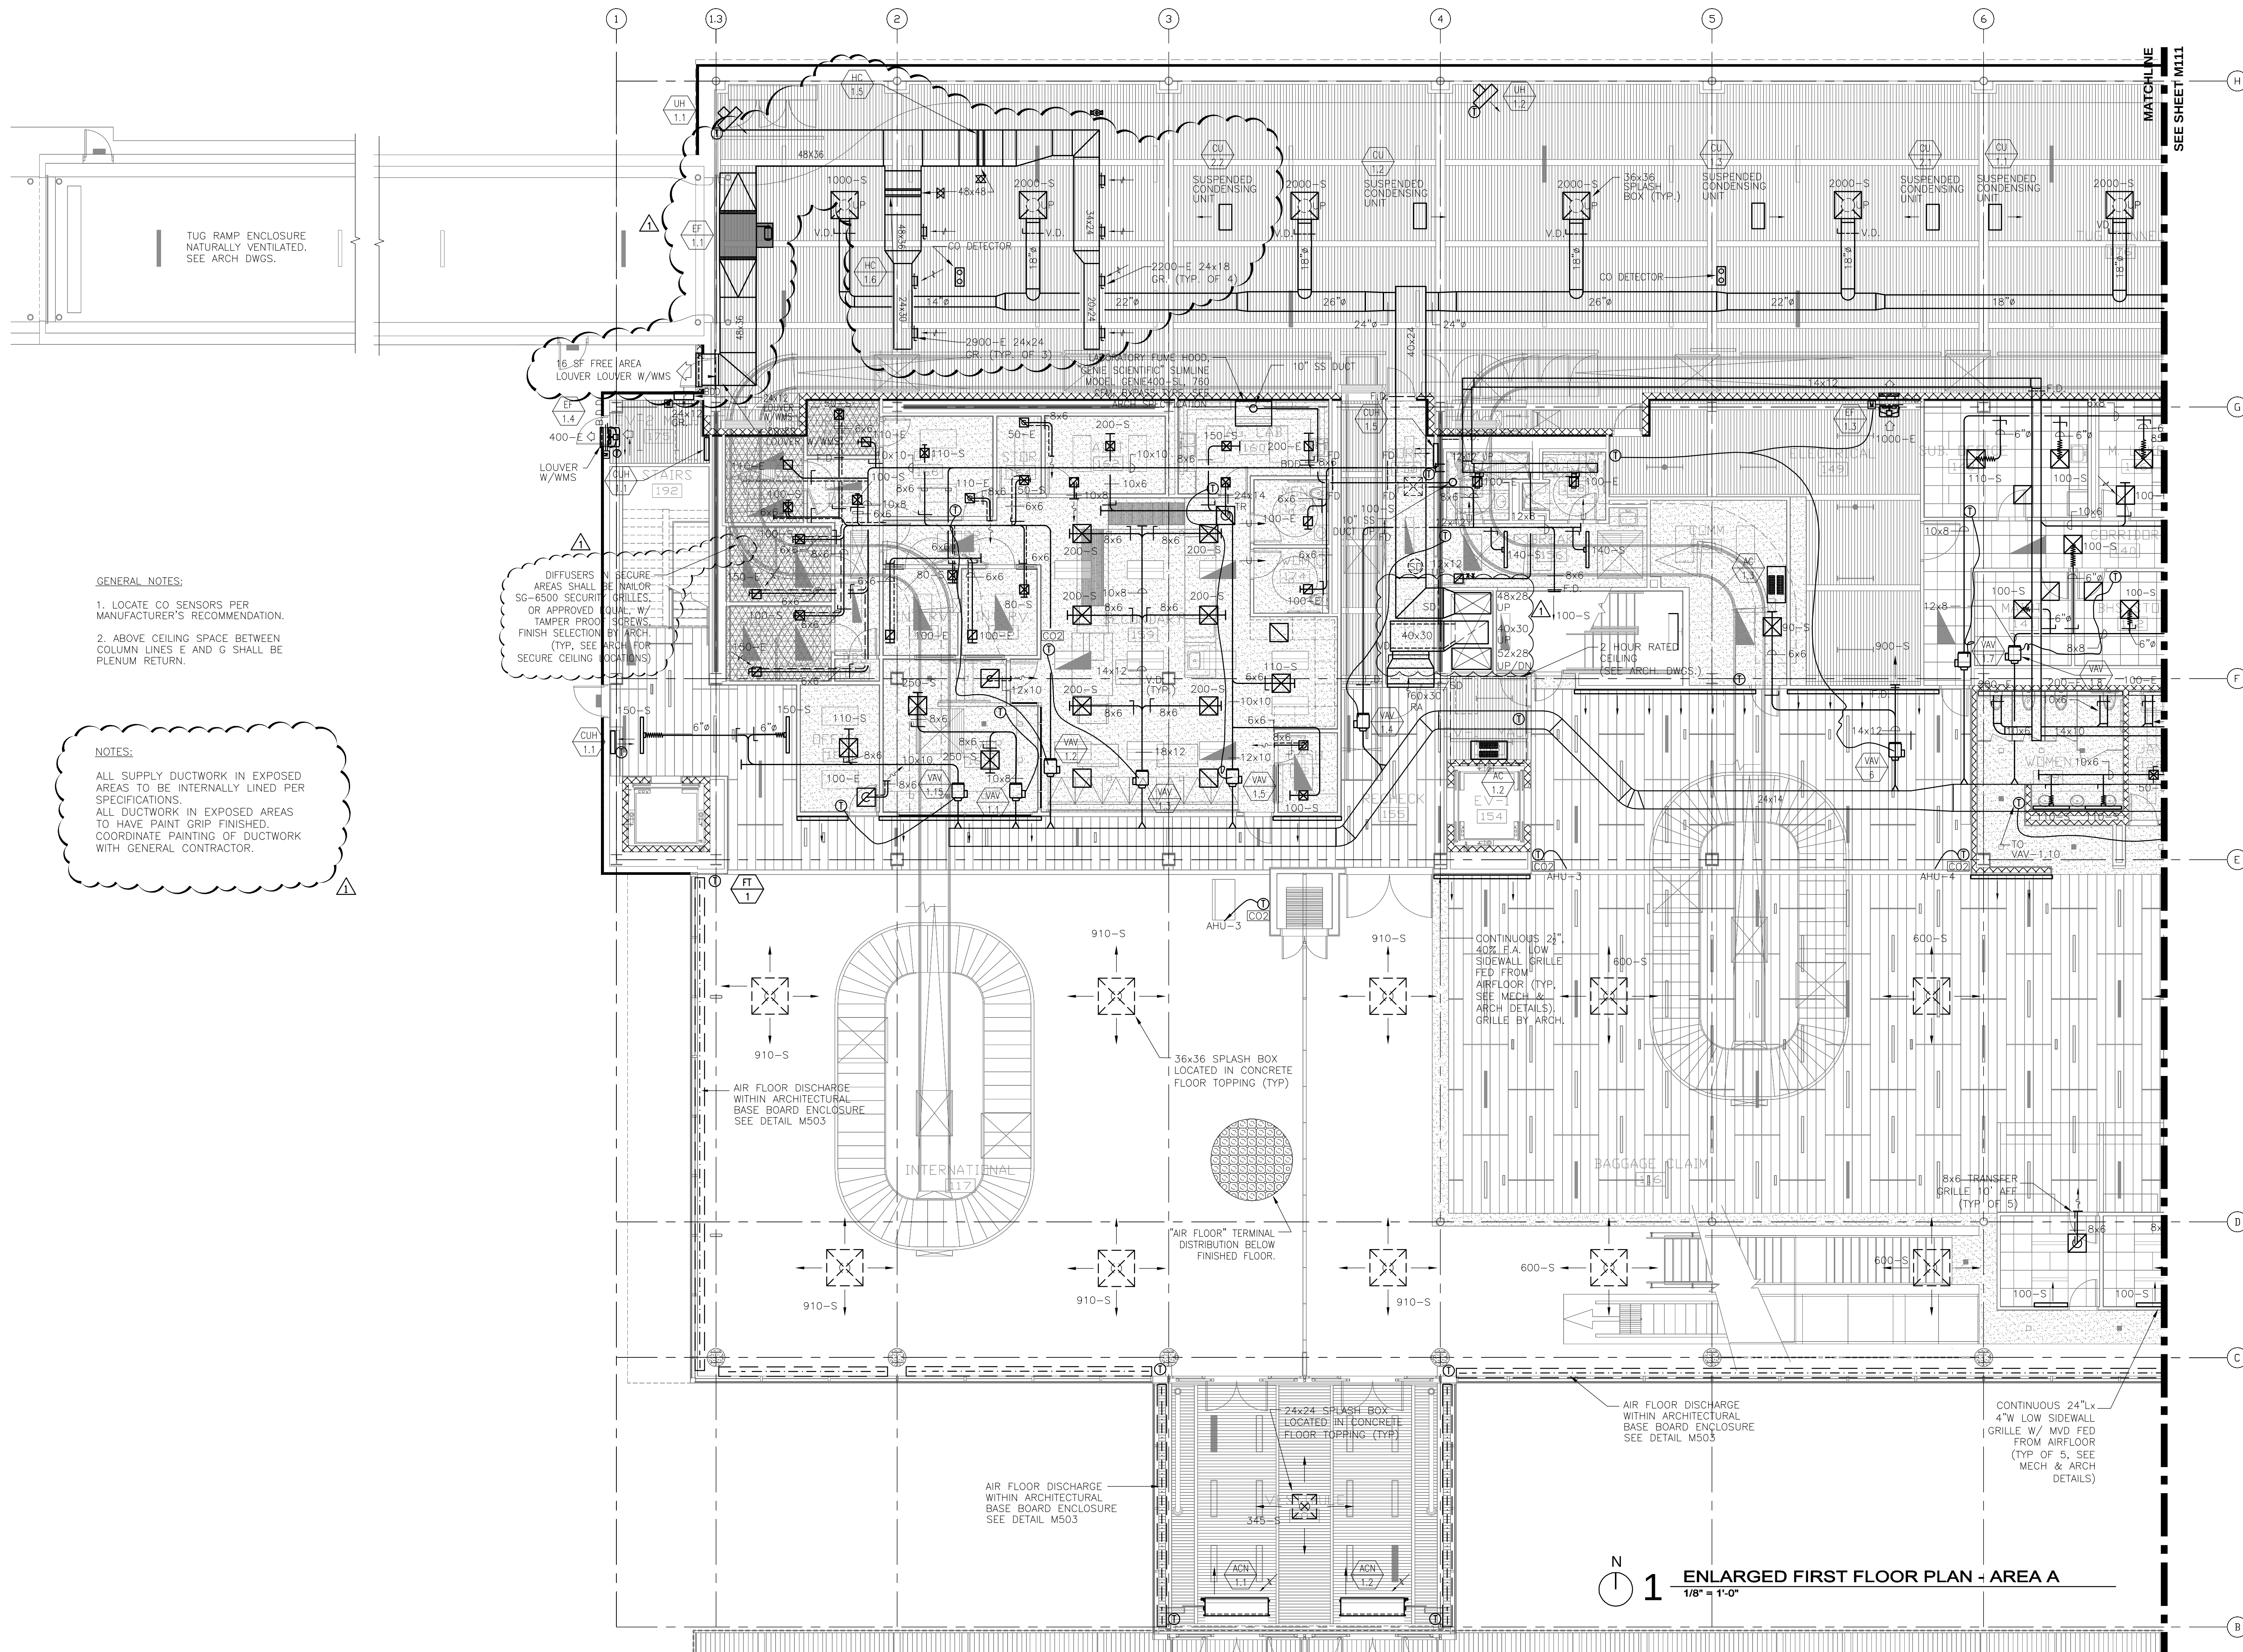

GENERAL NOTES:

1. LOCATE CO SENSORS PER MANUFACTURER'S RECOMMENDATION.
2. ABOVE CEILING SPACE BETWEEN COLUMN LINES E AND G SHALL BE PLENUM RETURN.

NOTES:

ALL SUPPLY DUCTWORK IN EXPOSED AREAS TO BE INTERNALLY LINED PER SPECIFICATIONS.

ALL DUCTWORK IN EXPOSED AREAS TO HAVE PAINT GRIP FINISHED.

COORDINATE PAINTING OF DUCTWORK WITH GENERAL CONTRACTOR.



Reynolds, Smith and Hills, Inc.
4525 Airport Approach Rd, Ste A
Duluth, Minnesota 55811
218-722-1227 Fax: 218-722-1052
www.rsandh.com



DULUTH INTERNATIONAL AIRPORT
DULUTH, MN

NEW PASSENGER TERMINAL

CONSULTANTS

Interior Architects:
SJA ARCHITECTS
11 E Superior Street Se 340, Duluth MN 55802
TEL: (218) 724-8578 / FAX: (218) 724-8717

Structural Engineers:
MBJ CONSULTING ENG.
501 Lake Avenue South, Suite 300, Duluth MN 55802
TEL: (218) 722-1056 / FAX: (218) 722-9306

M/E/P/FP Engineers:
COSENTINI ASSOCIATES INC.
1 South Wacker Drive, 37th Floor, Chicago IL 60606
TEL: (312) 201-7408 / FAX: (312) 201-0031

Baggage Handling Systems Consultants:
BNP ASSOCIATES INC.
101 East Ridge Office Park, Suite 103, Danbury CT 06810
TEL: (203) 792-3000 / FAX: (203) 792-4900

Landscape Consultants:
APPOLD DESIGN
2432 East First Street, Duluth MN 55812
TEL: (218) 591-5079

ENGINEER CERTIFICATION
I hereby certify that the engineering plans, specifications or report was prepared by me or under my direct supervision and that I am a duly licensed Professional Engineer under the laws of the State of Minnesota.
Print Name: Douglas C. Moss

Signature: *[Signature]*

Date: 08/16/10
Reg. No.: 21067

REVISIONS		
NO.	DESCRIPTION	DATE
1	ADDENDUM 1	6.11.10
	CONFORMANCE SET	7.12.10
3	PERMIT REVISIONS	7.23.10
	BUILDING PERMIT	8.16.10
	100% REVIEW	8.16.10
	BID PACKAGE 2A	1.24.11
Δ	BP2A ADDENDUM 2	2.25.11

DATE ISSUED: 02-25-11
REVIEWED BY: MXB
DRAWN BY: JEK
DESIGNED BY: MXB

AEP PROJECT NUMBER
213-1882-091
© 2010 REYNOLDS, SMITH AND HILLS, INC.

SHEET TITLE
ENLARGED FIRST FLOOR MECHANICAL PLAN AREA A

SHEET NUMBER

M110

BID PACKAGE 2A
ADDENDUM 2

1 ENLARGED FIRST FLOOR PLAN - AREA A
1/8" = 1'-0"