




Reynolds, Smith and Hills, Inc.
4525 Airport Approach Rd, Ste A
Duluth, Minnesota 55811
218-722-1227 Fax: 218-722-1052
www.rsandh.com

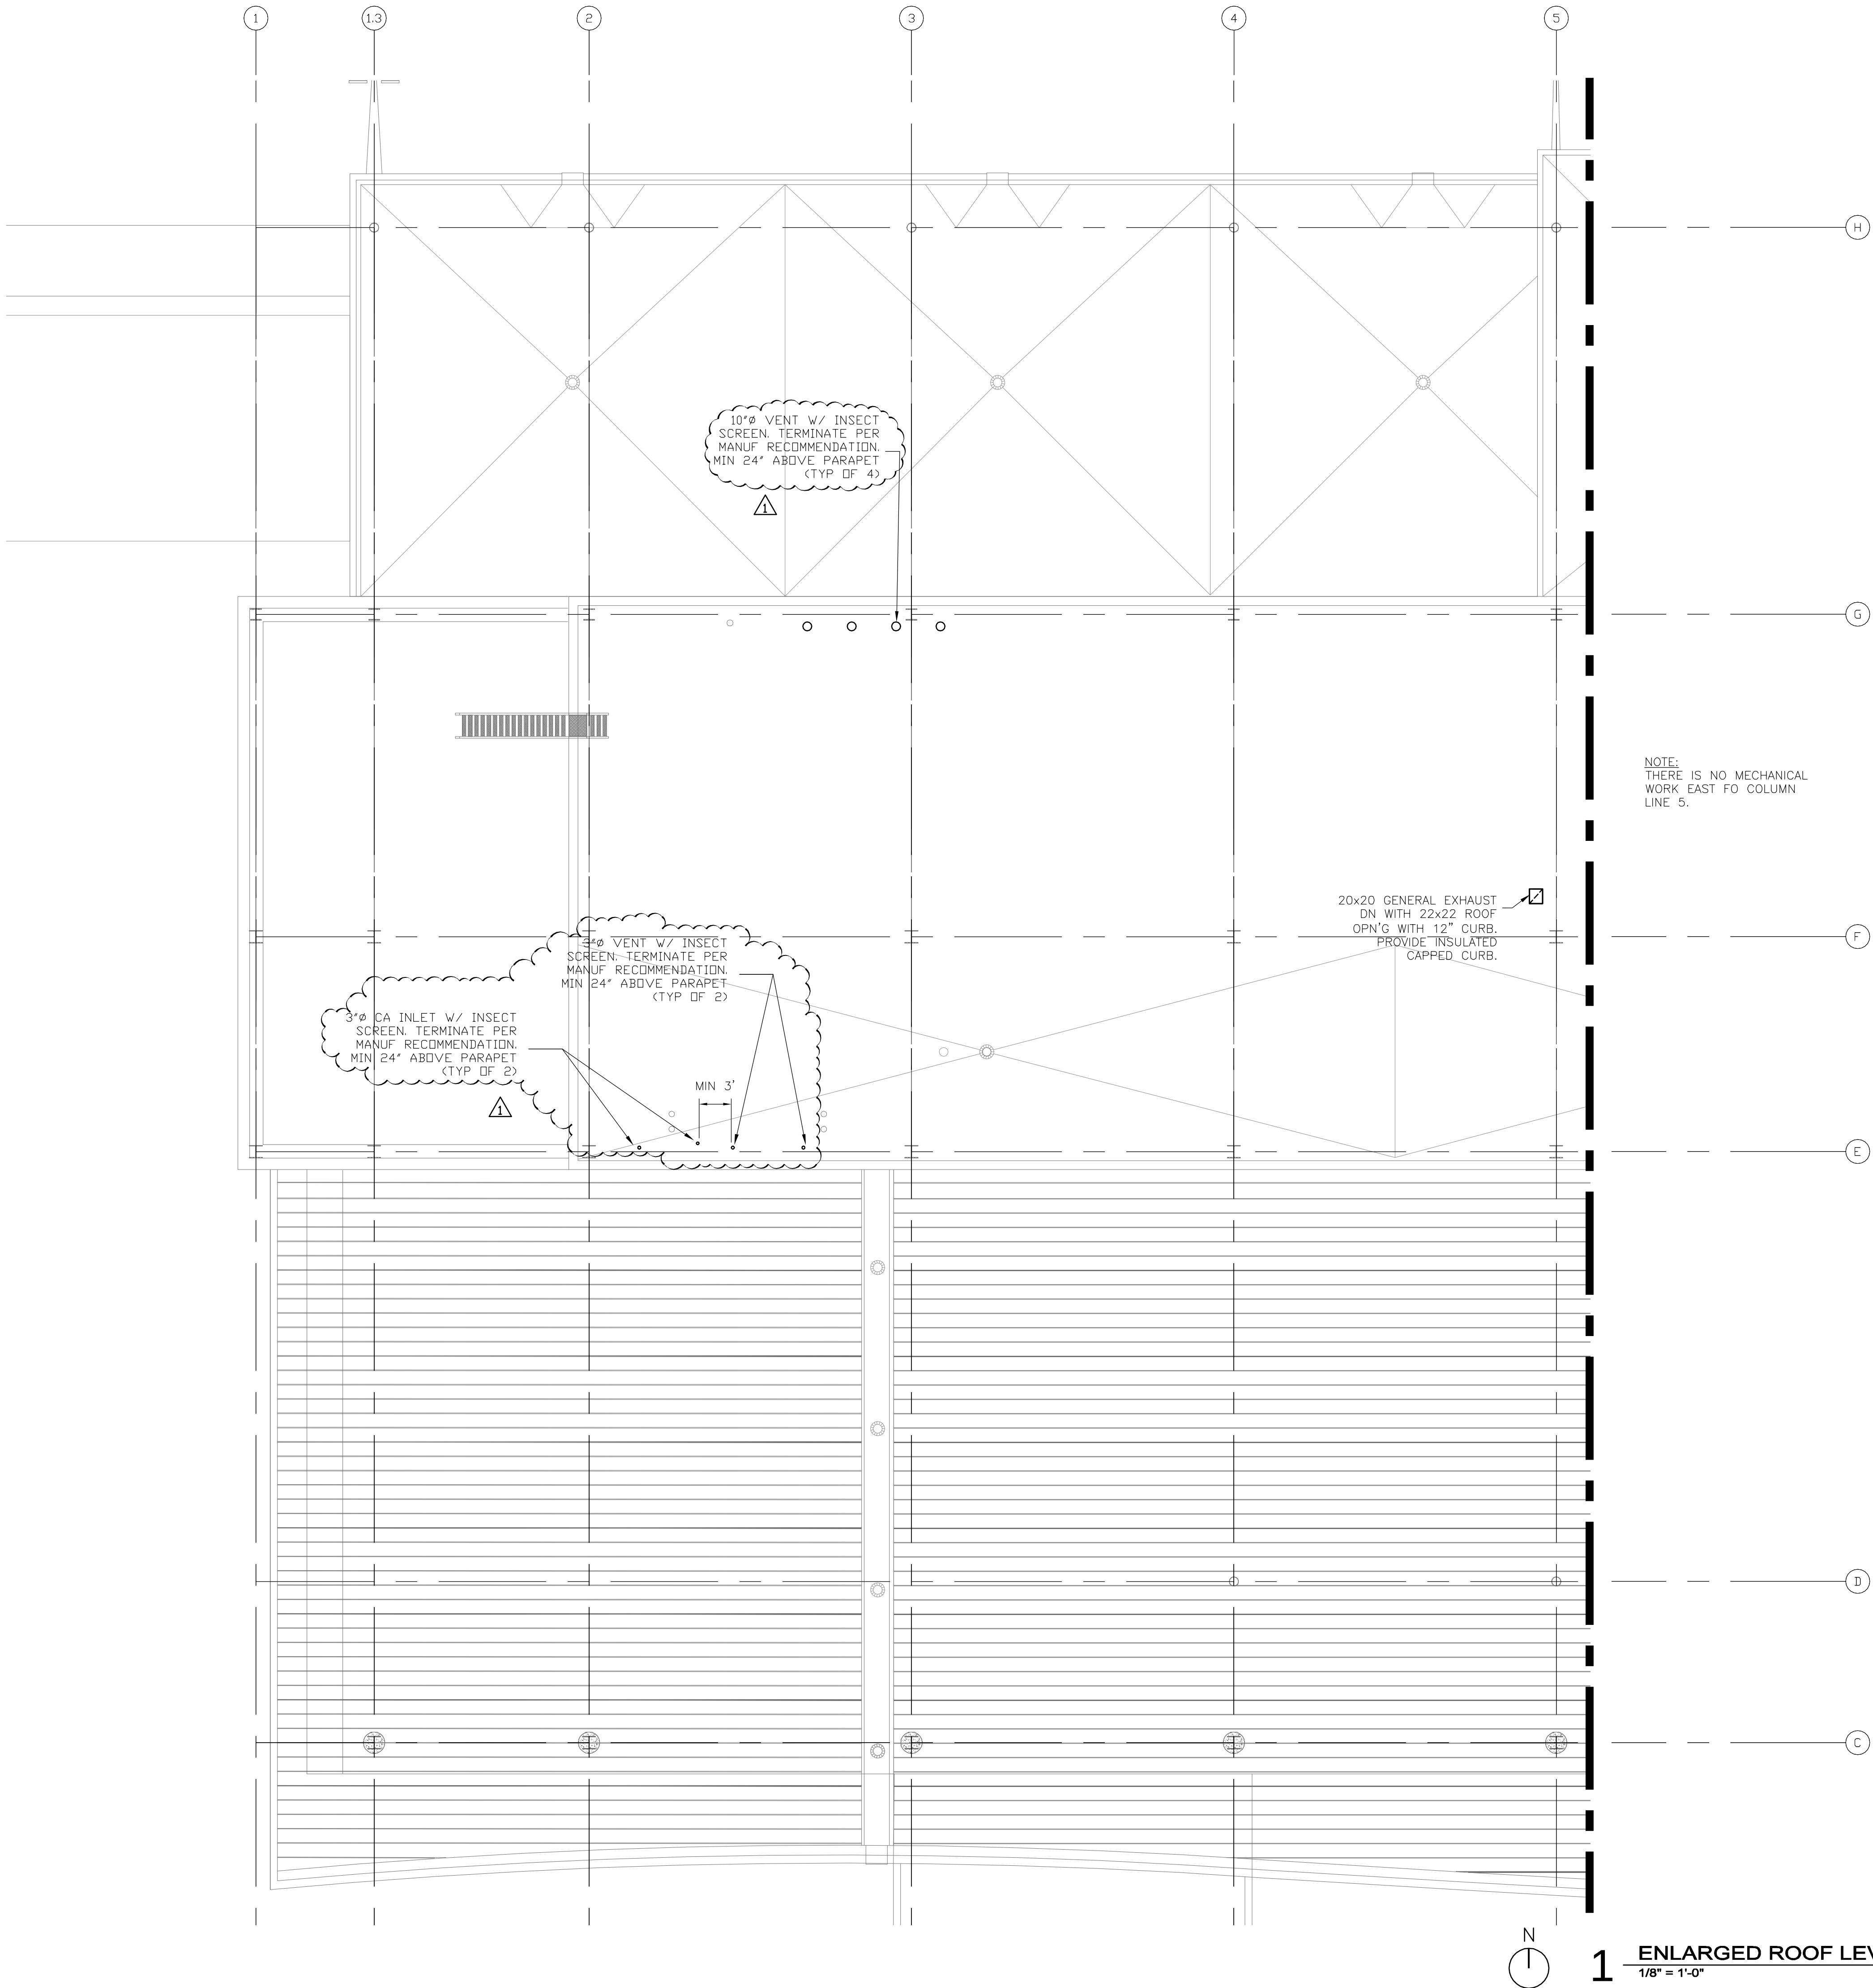

DULUTH
INTERNATIONAL
AIRPORT
DULUTH, MN

NEW PASSENGER
TERMINAL

CONSULTANTS

Interior Architects:
SJA ARCHITECTS
11 E Superior Street Se 340, Duluth MN 55802
TEL: (218) 724-8578 / FAX: (218) 724-8717

Structural Engineers:
MBJ CONSULTING ENG.
501 Lake Avenue South, Suite 300, Duluth MN 55802
TEL: (218) 722-1056 / FAX: (218) 722-9306

M/E/P/F/P Engineers:
COSENTINI ASSOCIATES INC.
1 South Wacker Drive, 37th Floor, Chicago IL 60606
TEL: (312) 201-7408 / FAX: (312) 201-0031

Baggage Handling Systems Consultants:
BNP ASSOCIATES INC.
101 East Ridge Office Park, Suite 103, Danbury CT 06810
TEL: (203) 792-3000 / FAX: (203) 792-4900

Landscaping Consultants:
APPOLD DESIGN
2432 East First Street, Duluth MN 55812
TEL: (218) 591-5079

ENGINEER CERTIFICATION
I hereby certify that the
engineeringh plans, specifications
or report was prepared by me or
under my direct supervision and
that I am a duly licensed
Professional Engineer under the
laws of the State of Minnesota.
Print Name: Douglas C. Moss

Signature: *Doug C. Moss*

Date: 08/16/10
Reg. No.: 21067

REVISIONS		
NO.	DESCRIPTION	DATE
1	ADDENDUM 1	6.11.10
	CONFORMANCE SET	7.12.10
3	PERMIT REVISIONS	7.23.10
	BUILDING PERMIT	8.16.10
	100% REVIEW	12.17.10
	BID PACKAGE 2A	1.24.11
△	BP2A ADDENDUM 2	2.25.11

DATE ISSUED: 02-25-11
REVIEWED BY: MXB
DRAWN BY: MB/JH
DESIGNED BY: MXB

AEP PROJECT NUMBER
213-1882-091
© 2010 REYNOLDS, SMITH AND HILLS INC.

SHEET TITLE
**ENLARGED
ROOF LEVEL
MECHANICAL PLAN
AREA A**

SHEET NUMBER

M116

BID PACKAGE 2A
ADDENDUM 2