


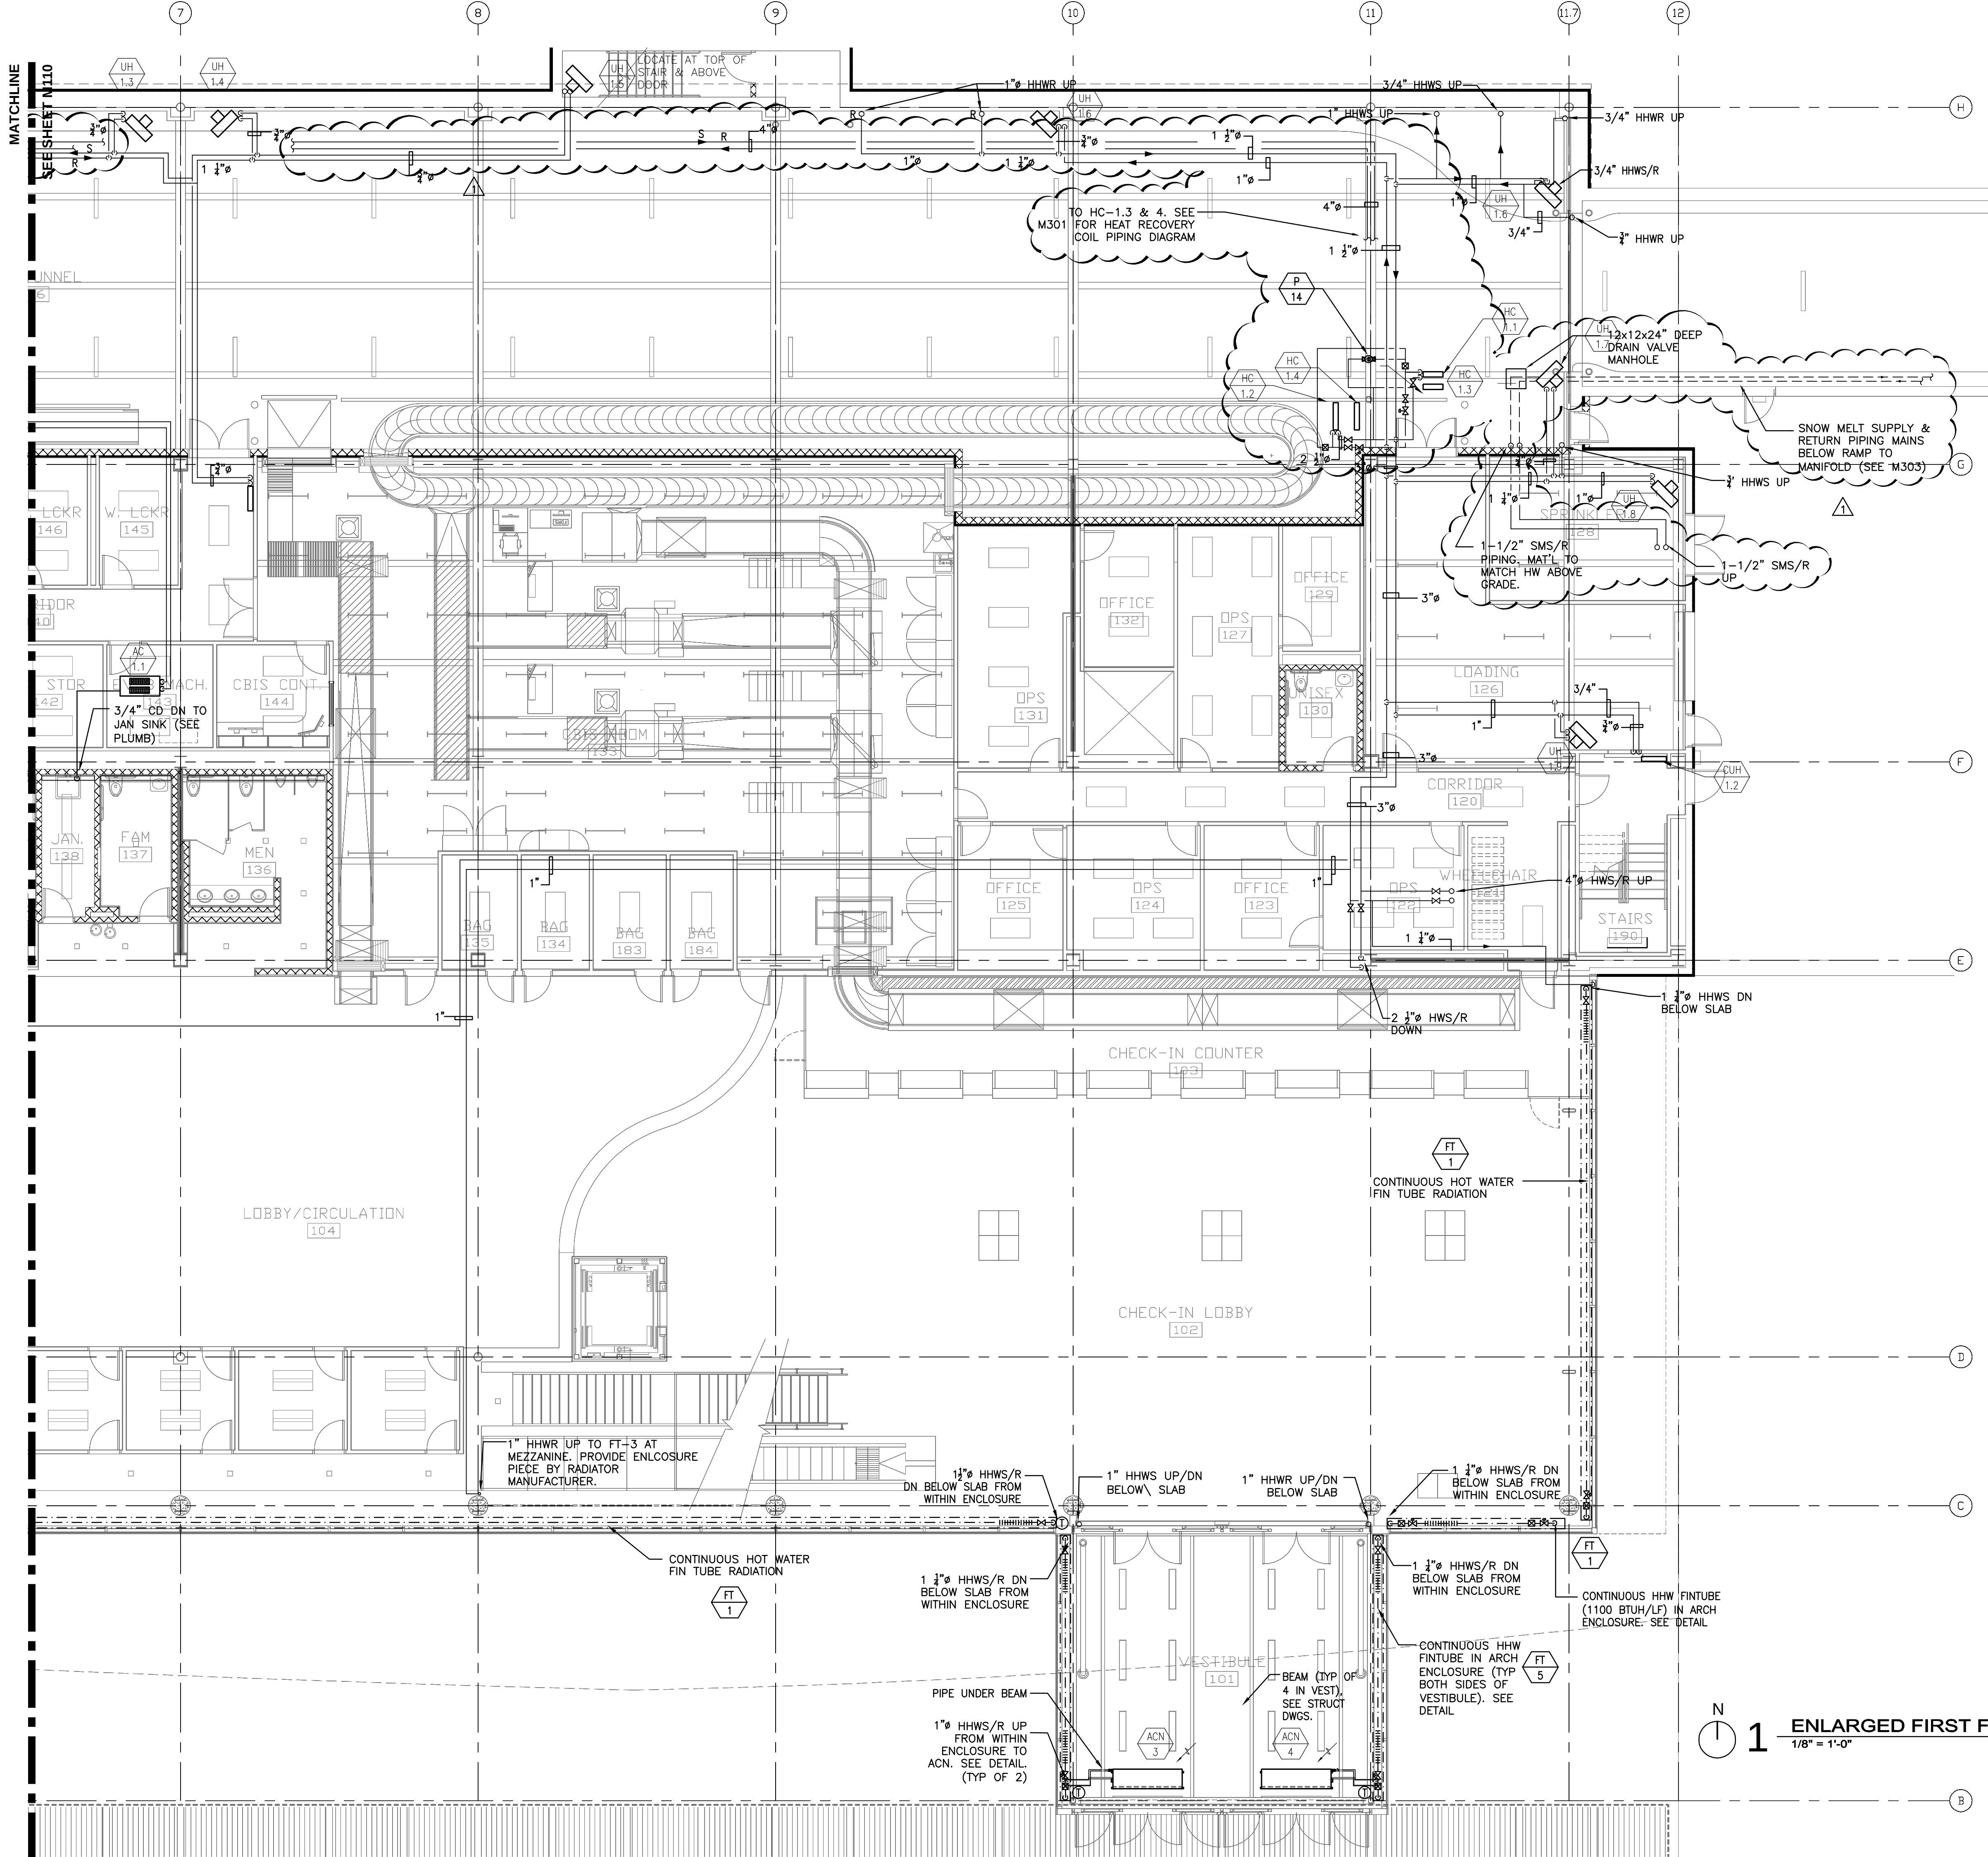

GENERAL NOTES:

1. SEE M109 FOR BELOW GRADE PIPING IN THIS AREA.
2. EXPOSED PIPING IN MAIN ENTRANCE VESTIBULES TO HAVE 0.04" ALUMINUM JACKET WITH POLISHED FINISH & PRE-FORMED ELBOWS.
3. EXPOSED PIPING IN MAIN ENTRANCE VESTIBULES TO HAVE 0.04" ALUMINUM JACKET WITH POLISHED FINISH & PRE-FORMED ELBOWS.



Reynolds, Smith and Hills, Inc.
4525 Airport Approach Rd, Ste A
Duluth, Minnesota 55811
218-722-1227 Fax: 218-722-1052
www.rsandh.com

DULUTH AIRPORT AUTHORITY

DULUTH INTERNATIONAL AIRPORT
DULUTH, MN

NEW PASSENGER TERMINAL

CONSULTANTS

Interior Architects:
SJA ARCHITECTS
11 E Superior Street Se 340, Duluth MN 55802
TEL: (218) 724-8578 / FAX: (218) 724-8717

Structural Engineers:
MBJ CONSULTING ENG.
501 Lake Avenue South, Suite 300, Duluth MN 55802
TEL: (218) 722-1056 / FAX: (218) 722-9306

M/E/P/FP Engineers:
COSENTINI ASSOCIATES INC.
1 South Wacker Drive, 37th Floor, Chicago IL 60606
TEL: (312) 201-7408 / FAX: (312) 201-0031

Baggage Handling Systems Consultants:
BNP ASSOCIATES INC.
101 East Ridge Office Park, Suite 103, Danbury CT 06810
TEL: (203) 792-2000 / FAX: (203) 792-4900

Landscape Consultants:
APPOLD DESIGN
2432 East First Street, Duluth MN 55812
TEL: (218) 591-5079

ENGINEER CERTIFICATION
I hereby certify that the engineering plans, specifications or report was prepared by me or under my direct supervision and that I am a duly licensed Professional Engineer under the laws of the State of Minnesota.
Print Name: Douglas C. Moss

Signature: *[Signature]*

Date: 08/16/10
Reg. No.: 21067

REVISIONS		
NO.	DESCRIPTION	DATE
1	ADDENDUM 1	6.11.10
	CONFORMANCE SET	7.12.10
3	PERMIT REVISIONS	7.23.10
	BUILDING PERMIT	8.16.10
	100% REVIEW	12.17.10
	BID PACKAGE 2A	1.24.11
Δ	BP2A ADDENDUM 2	2.25.11

DATE ISSUED: 02-25-11
REVIEWED BY: MXB
DRAWN BY: JEH
DESIGNED BY: MXB

AEP PROJECT NUMBER
213-1882-091
© 2010 REYNOLDS, SMITH AND HILLS, INC.

SHEET TITLE
ENLARGED FIRST FLOOR MECHANICAL PIPING PLAN AREA B

SHEET NUMBER
MP111
BID PACKAGE 2A
ADDENDUM 2