


MATCHLINE
SEE SHEET M112

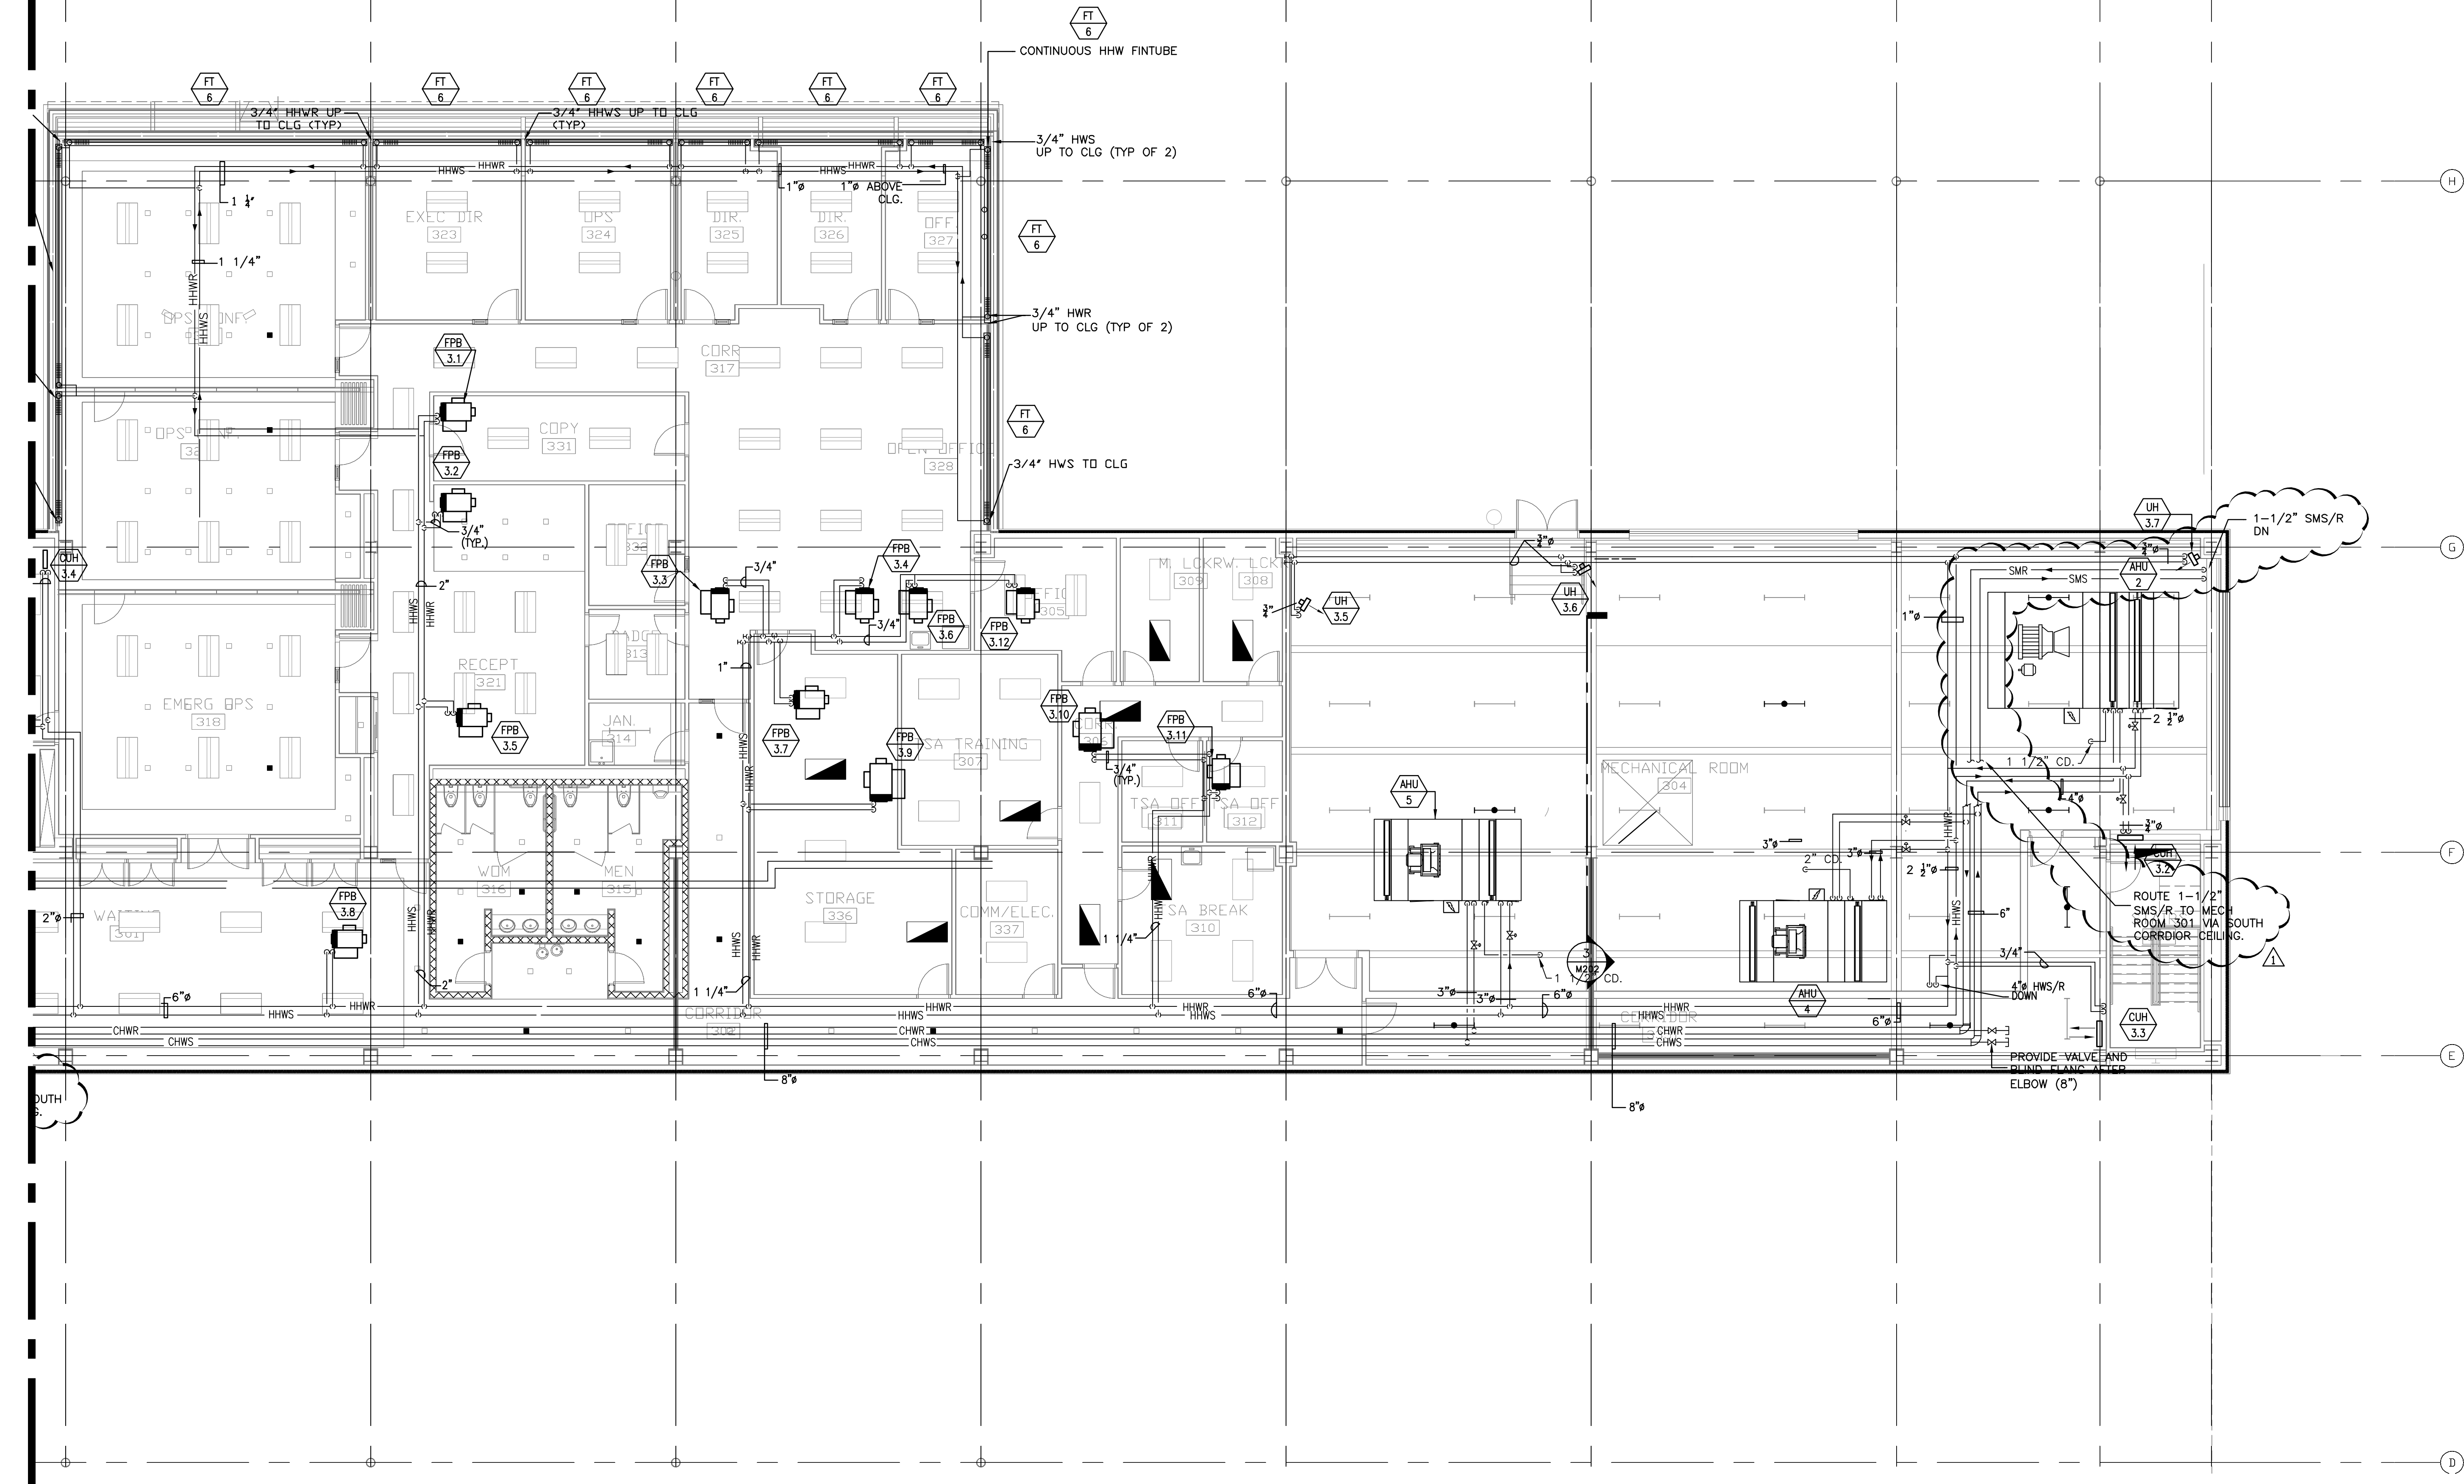

GENERAL NOTES:

1. PERIMETER FINTUBE SHALL BE CONTROLLED AS FIRST STAGE OF HEATING THROUGH DDC INTERLOCK WITH RESPECTIVE ZONE FPB.

RS&H
IMPROVING YOUR WORLD

Reynolds, Smith and Hills, Inc.

4525 Airport Approach Rd, Ste A
Duluth, Minnesota 55811
218-722-1227 Fax: 218-722-1052
www.rsandh.com



DULUTH AIRPORT
AUTHORITY

DULUTH
INTERNATIONAL
AIRPORT
DULUTH, MN

NEW PASSENGER
TERMINAL

CONSULTANTS

Interior Architects:

SJA ARCHITECTS

11 E Superior Street Ste 340, Duluth MN 55802
TEL: (218) 724-8578 / FAX: (218) 724-8717

Structural Engineers:

MBJ CONSULTING ENG.

501 Lake Avenue South, Suite 300, Duluth MN 55802
TEL: (218) 722-1056 / FAX: (218) 722-9306

M/E/P/F Engineers:

COSENTINI ASSOCIATES INC.

1 South Wacker Drive, 37th Floor, Chicago IL 60606
TEL: (312) 201-7408 / FAX: (312) 201-0031

Baggage Handling Systems Consultants:

BNP ASSOCIATES INC.

101 East Ridge Office Park, Suite 103, Danbury CT 06810
TEL: (203) 792-3000 / FAX: (203) 792-4900

Landscaping Consultants:

APPOLD DESIGN

2432 East First Street, Duluth MN 55812
TEL: (218) 591-5079

ENGINEER CERTIFICATION

I hereby certify that the engineering plans, specifications or report was prepared by me or under my direct supervision and that I am a duly licensed Professional Engineer under the laws of the State of Minnesota. Print Name: Douglas C. Moss

Signature: *Douglas C. Moss*

Date: 08/16/10
Reg. No.: 21067

REVISIONS

NO.	DESCRIPTION	DATE
1	ADDENDUM 1	6.11.10
2	CONFORMANCE SET	7.12.10
3	PERMIT REVISIONS	7.23.10
	BUILDING PERMIT	8.16.10
	100% REVIEW	12.17.10
	BID PACKAGE 2A	1.24.11
△	BP2A ADDENDUM 2	2.25.11

DATE ISSUED: 02-25-11

REVIEWED BY: MXB

DRAWN BY: MB/JEH

DESIGNED BY: MXB

AEP PROJECT NUMBER

213-1882-091

© 2010 REYNOLDS, SMITH AND HILLS, INC.


SHEET TITLE

ENLARGED
THIRD FLOOR
MECHANICAL PIPING
PLAN AREA B

SHEET NUMBER

MP115

 BID PACKAGE 2A
ADDENDUM 2



1 ENLARGED THIRD LEVEL MECHANICAL PLAN - AREA B
1/8" = 1'-0"