



DULUTH AIRPORT
AUTHORITY

DULUTH
INTERNATIONAL
AIRPORT
DULUTH, MN

NEW PASSENGER
TERMINAL

CONSULTANTS

Interior Architects:
SJA ARCHITECTS

11 E Superior Street, Suite 400, Duluth, MN 55802
TEL: (218) 724-8578 / FAX: (218) 724-8717

Structural Engineer:
MBJ CONSULTING ENG.

501 Lake Avenue South, Suite 200, Duluth, MN 55802
TEL: (218) 722-1056 / FAX: (218) 722-3036

Mechanical Engineer:
COSENTINI ASSOCIATES INC.

1 South Water Drive, 37th Floor, Chicago, IL 60606
TEL: (312) 201-7488 / FAX: (312) 201-0031

Baggage Handling Systems Consultants:
BNP ASSOCIATES INC.

801 East Ridge Office Park, Suite 103, Danbury, CT 06810
TEL: (203) 792-5000 / FAX: (203) 792-4900

Landscape Architect:
APPOLO DESIGN

2432 East The Street, Duluth, MN 55812
TEL: (218) 591-5579

ENGINEER CERTIFICATION
I hereby certify that the engineering plans, specifications, and reports were prepared by me or under my direct supervision and that I am a duly Licensed Professional Engineer under the laws of the State of Minnesota.

Print Name: Douglas C. Mass

Signature: *Douglas C. Mass*

Date: 08/16/10 Reg. No.: 21067

REVISIONS

NO.	DESCRIPTION	DATE
1	ADDENDUM 1	6.11.10
2	CONFORMANCE SET	7.13.10
3	PERMIT REVISIONS	7.23.10
4	BUILDING PERMIT	8.16.10
5	REV 017	9.24.10
6	BID PACKAGE 2A	01.24.11
7	REV 018	2.25.11

DATE ISSUED: 02-25-11

REVIEWED BY: RDJ

DRAWN BY: SA

DESIGNED BY: SA

A&P PROJECT NUMBER

213-1882-091


SHEET TITLE

ENLARGED
FIRST FLOOR
PLUMBING
PLAN AREA A

SHEET NUMBER

P110

BID PACKAGE 2A
ADDENDUM 2

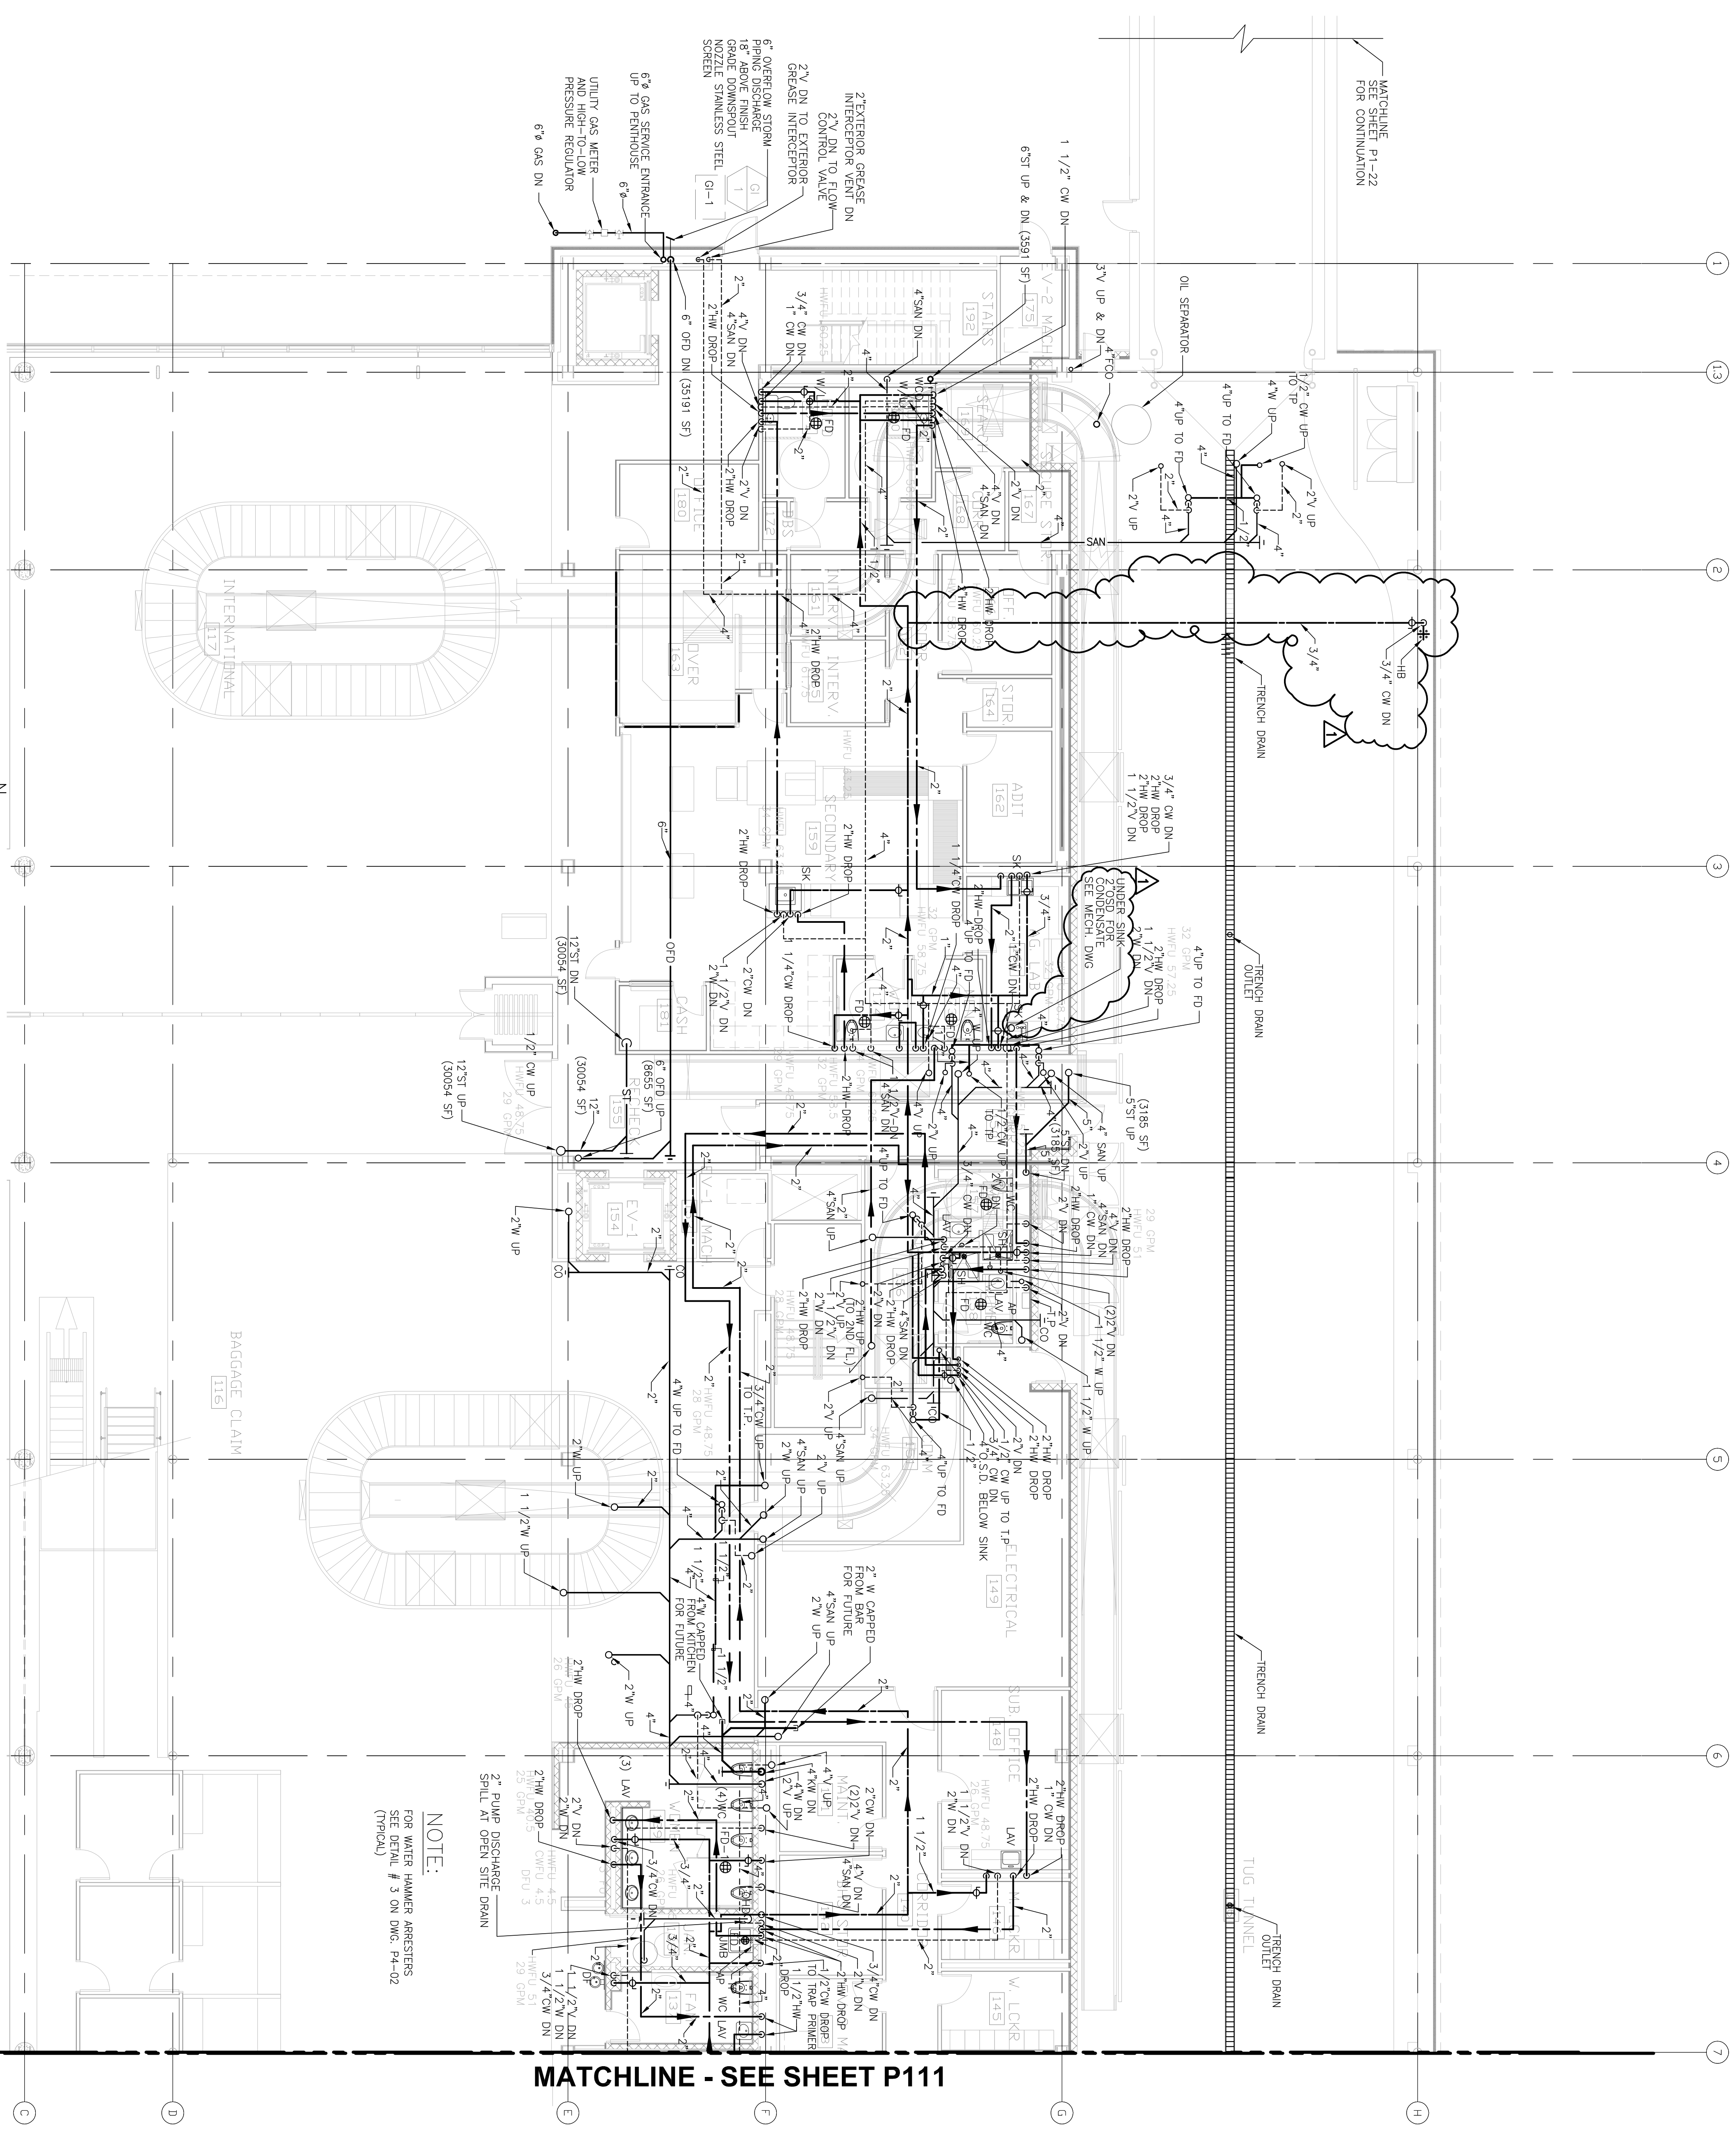

MATCHLINE - SEE SHEET P111

NOTE:
FOR WATER HAMMER ARRESTERS
SEE DETAIL # 3 ON DWG. P4-02
(TYPICAL)

ENLARGED FIRST FLOOR PLAN - AREA A
SCALE: 1/8" = 1'-0"